




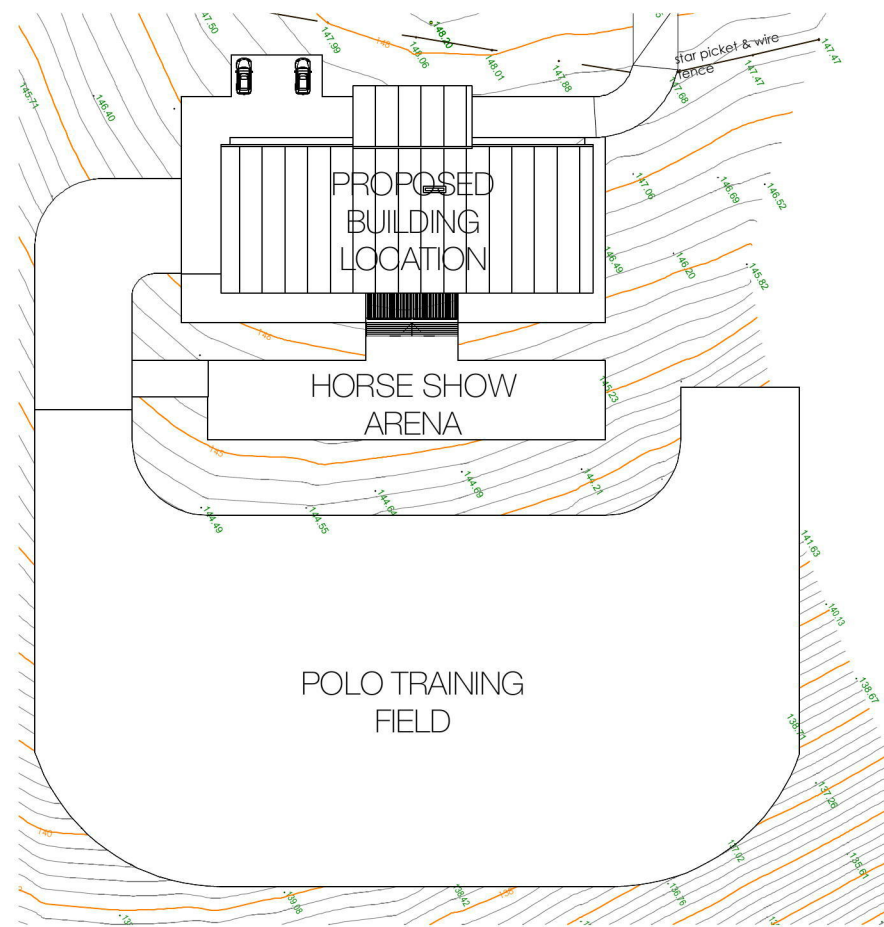


1 Notification - Plan
1 : 1000

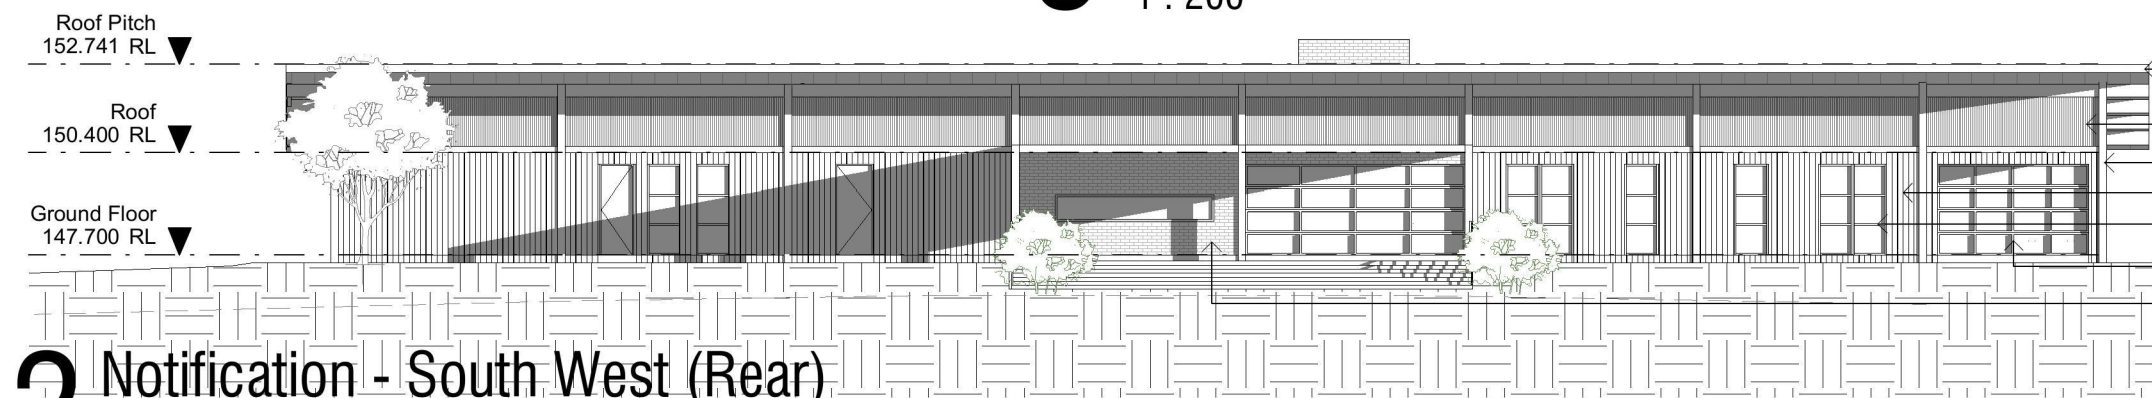


2 Notification - South West (Rear)
1 : 200

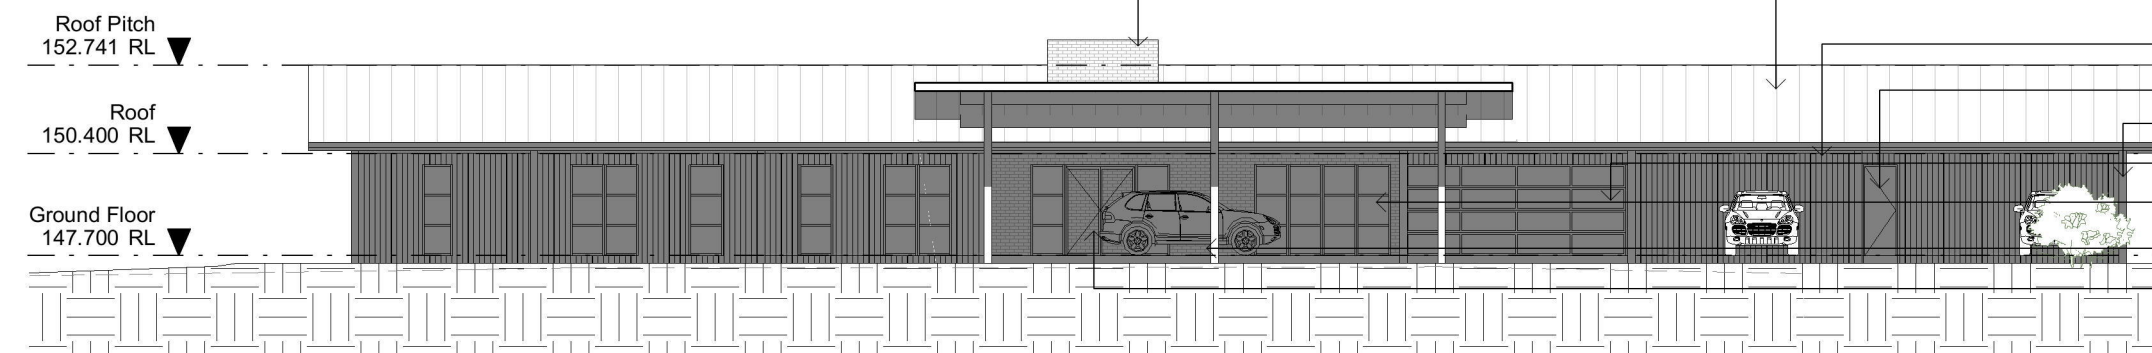

4 Notification - South East (Entry)
1 : 200

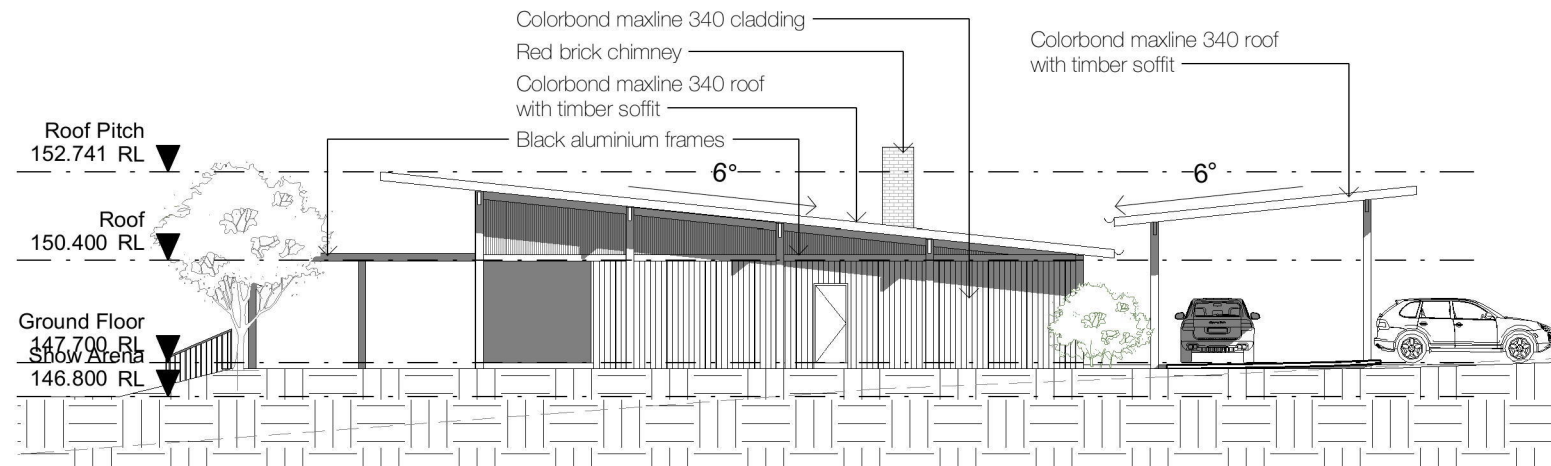

3 Notification - North East (End)
1 : 200

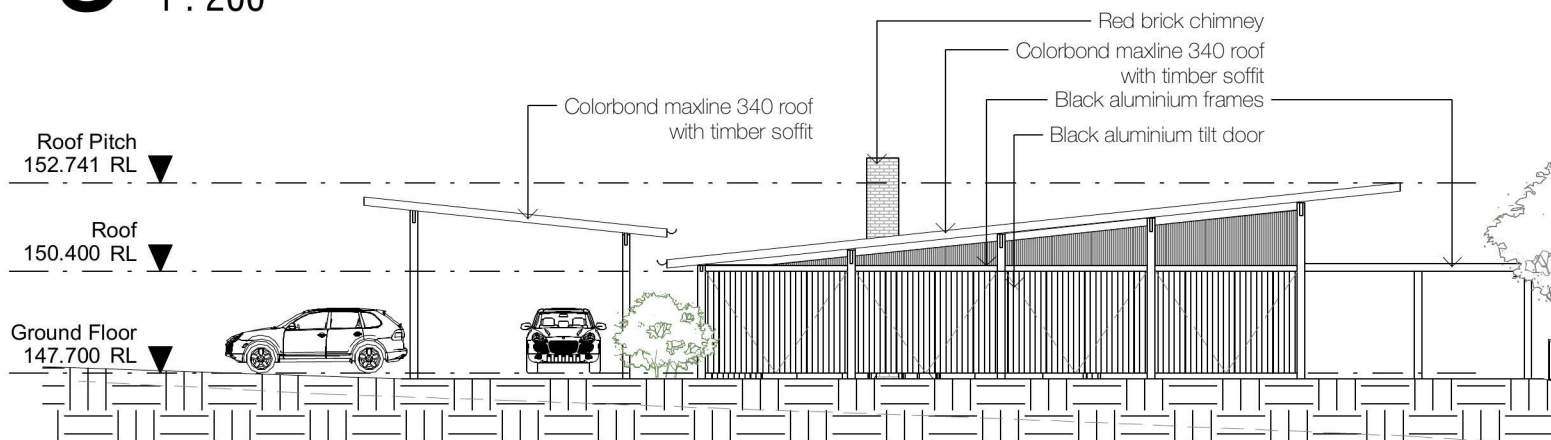

5 Notification - South West (End)
1 : 200

COPYRIGHT APPLIES TO THIS DOCUMENT AND DESIGN AND IS THE PROPERTY OF RALPH FERRIS & SONS PTY LTD. - REPRODUCTION OF ANY KIND IS NOT PERMITTED WITHOUT OUR CONSENT.

CONTRACTORS TO VERIFY ALL DIMENSIONS AND SETOUTS ON SITE BEFORE COMMENCING WORK.

SHOULD ANY DISCREPANCIES BE FOUND, PLEASE NOTIFY THE AUTHOR IMMEDIATELY SO THAT INSTRUCTION MAY BE ISSUED.

FIGURED DIMENSIONS ARE TO BE USED. DO NOT SCALE FROM THIS DRAWING.

TO BE READ IN CONJUNCTION WITH ENGINEER'S DOCUMENTS.

THE NOMINATED RESPONSIBLE ARCHITECT FOR RALPH FERRIS & SONS PTY LTD. TRADING AS DDC ARCHITECTURE + INTERIOR DESIGN IS GEOFF FERRIS-SMITH REGISTRATION 8334, ACN: 145 390 389

REVISION SCHEDULE		
issue#	date	description
3	09/07/2019	Council DA Submission



DDC ARCHITECTURE
+ INTERIOR DESIGN

Unit 3, 112 Russell Street
Emu Plains NSW 2750

02 4728 6500

PROJECT TITLE	EQUESTRIAN FACILITY
CLIENT	Dean Bouzianis
ADDRESS	101 Dharug Close, Mulgoa
DRAWING TITLE	NOTIFICATION PLAN

SCALE	As indicated @ A3
-------	-------------------

DRAWING NUMBER	17072 - DA-801
----------------	----------------

ISSUE	DATE
3	9/07/2019 11:08:13 AM

DA