




Beaurepaires

BEAUREPAIRES PENRITH

20 Woodriff Street,
Penrith NSW

<u>SHEET</u>	<u>REV</u>	<u>TITLE</u>
01	B	TITLE / STORE LOCATION
02	B	SITE PLAN
03-05	B	FLOOR PLAN
06	B	WALL FINISHES
07	B	REFLECTED CEILING PLAN
08	B	ELECTRICAL AND DATA PLAN
09-12	B	ELEVATIONS
13-14	B	EXISTING CONDITIONS

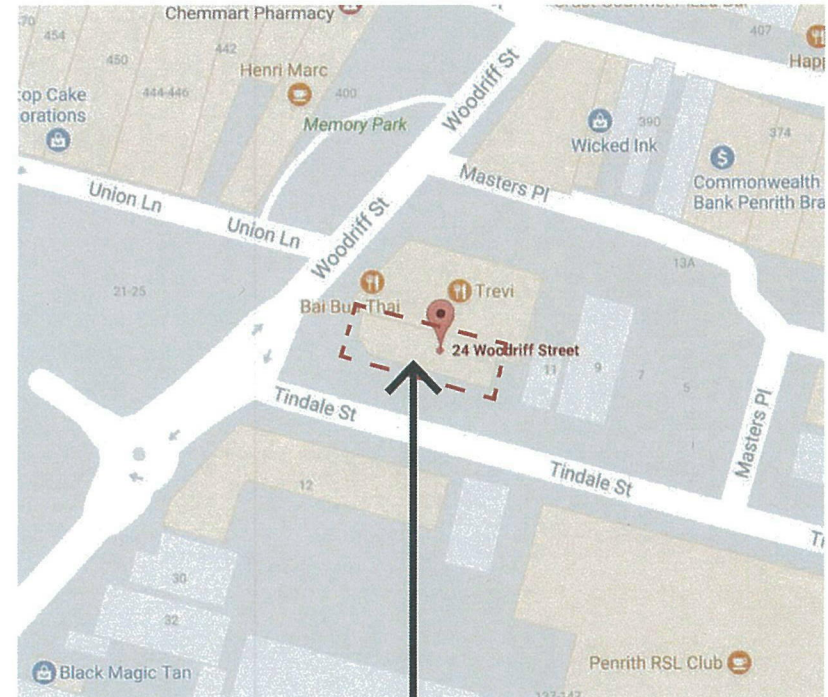

LOCATION PLAN

BEAUREPAIRES
BUILDING



File Name:
Beaurepaires_Penrith.ai

File Path:
1.Client Folder\Goodyear & Dunlop Tyres\Projects\GDT...\Montage_Artwork_Drawings

Description:
Site Plan

Page:
1

Issue:
B

Date:
24.07.17

Approved for Production ☒ Drawing No.

Approved, subject to Centre/Council ☒ Drawn by: rv


Approved with changes ☒ Approved:

Not Approved ☐ Date: / / 2017


FOREFRONT
CONCEPTS • BRANDING • DESIGN



WOODRIF ST ELEVATION
A3 SCALE 1:100

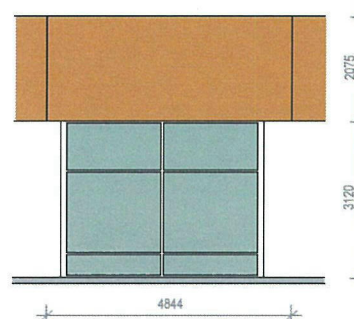

WOODRIF/TINDALE ST ELEVATION
A3 SCALE 1:100

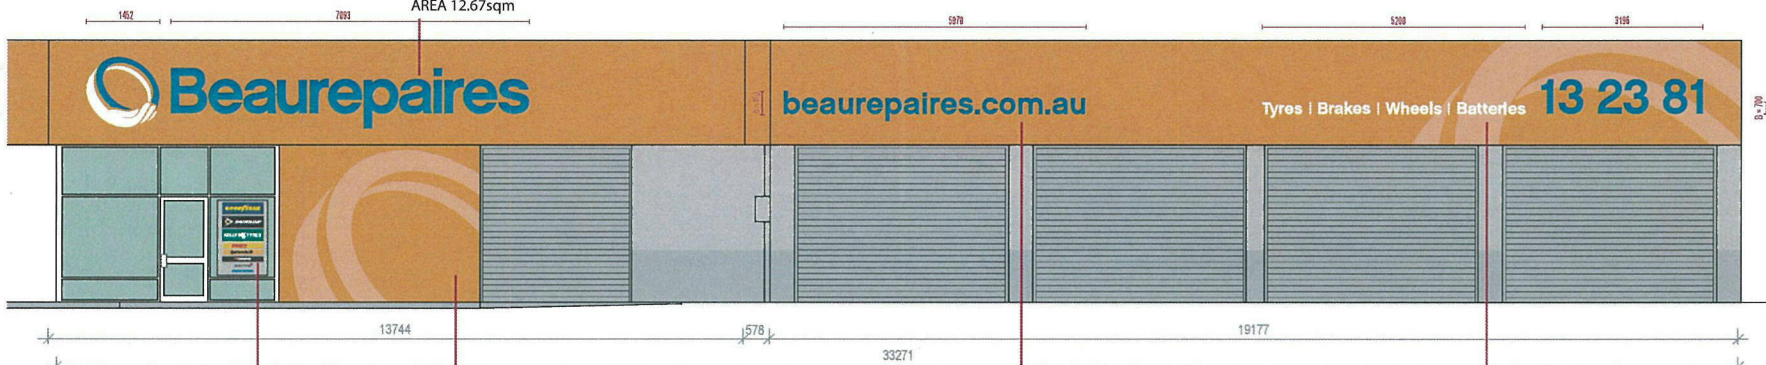


TINDALE ST ELEVATION
A3 SCALE 1:100

PARTNER BRANDS SIGN
PANEL SIZE
1000mm X 1500mm
VINYL ACRYLIC


SIGN 3
WATERMARK
VINYL DECAL WATERMARK
3716mm w x 3120mm h
AREA 11.6sqm

SIGN 4
WEB SITE -
NON ILLUMINATED ACRYLIC LETTERING
6170mm w x 793mm h
AREA 4.9sqm

SIGN 5
PHONE NUMBER / SERVICES / WATERMARK
NON ILLUMINATED ACRYLIC LETTERING
AND VINYL DECAL WATERMARK
9676mm w x 2075mm h
AREA 20sqm

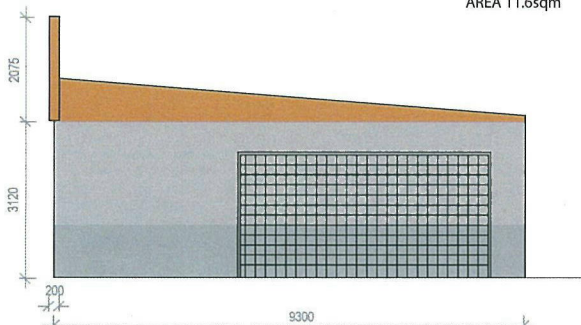

REAR ELEVATION
A3 SCALE 1:100

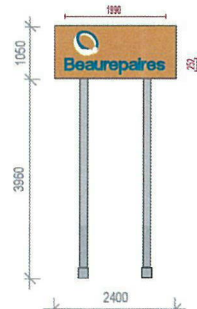

PYLON
A3 SCALE 1:100

SIGN 6
PYLON SIGN -
ILLUMINATED LIGHTBOX
2400mm w x 1050mm h
AREA 2.5sqm

ALL ORANGE SURFACE TO BE
4mm ORANGE 210 Alucobond
UNLESS INDICATED OTHERWISE

EP01
DULUX BEAUREPAIRS ORANGE
EXTERIOR GRADE ACRYLIC
WITH ANTI GRAFITTI COATING

EP02
DULUX MITON MOON
EXTERIOR GRADE ACRYLIC
WITH ANTI GRAFITTI COATING

EP03
DULUX KLUTE
EXTERIOR GRADE ACRYLIC
WITH ANTI GRAFITTI COATING

SITE INFORMATION

**20 Woodriff Street
Penrith NSW 2750**

SITE AREA: 952 SQM APPROX

BUILDING AREA: 349 SQM

CONTRACTOR / SHOPFITTER TO CONFIRM DIMENSIONS ON SITE PRIOR TO PRODUCTION



File Name:
Beaurepairs_Penrith.ai

File Path:
1.Client Folder\Goodyear & Dunlop Tyres\Projects\GDT...\nMontage_Artwork_Drawings

Description:
New External Elevations/Signage

Page:
9

Issue:
B

Date:
24.07.17

Approved for Production
Approved, subject to Centre/Council
Approved with changes
Not Approved

Drawing No.

Drawn by: rv

Approved:

Date: / / 2017

FOREFRONT
CONCEPTS • BRANDING • DESIGN