


ELEVATIONS:

DO NOT SCALE DRAWINGS, FIGURED DIMENSIONS TAKE PRECEDENCE

BUILDER SHALL CHECK AND VERIFY ALL DIMENSIONS ON SITE AND REPORT ANY DISCREPANCIES TO THE BUILDING DESIGNER PRIOR TO THE COMMENCEMENT OF WORK


CONTRACTOR MUST VERIFY ALL DIMENSIONS ON SITE BEFORE COMMENCING ANY WORK OR PREPARING SHOP DRAWINGS WHICH MUST BE APPROVED BY THE BUILDING DESIGNER BEFORE MANUFACTURE. ANY EXTRA ENTAILED IN WORK SHOWN ON THIS DRAWING MUST BE CLAIMED AND APPROVED BEFORE PROCEEDING.

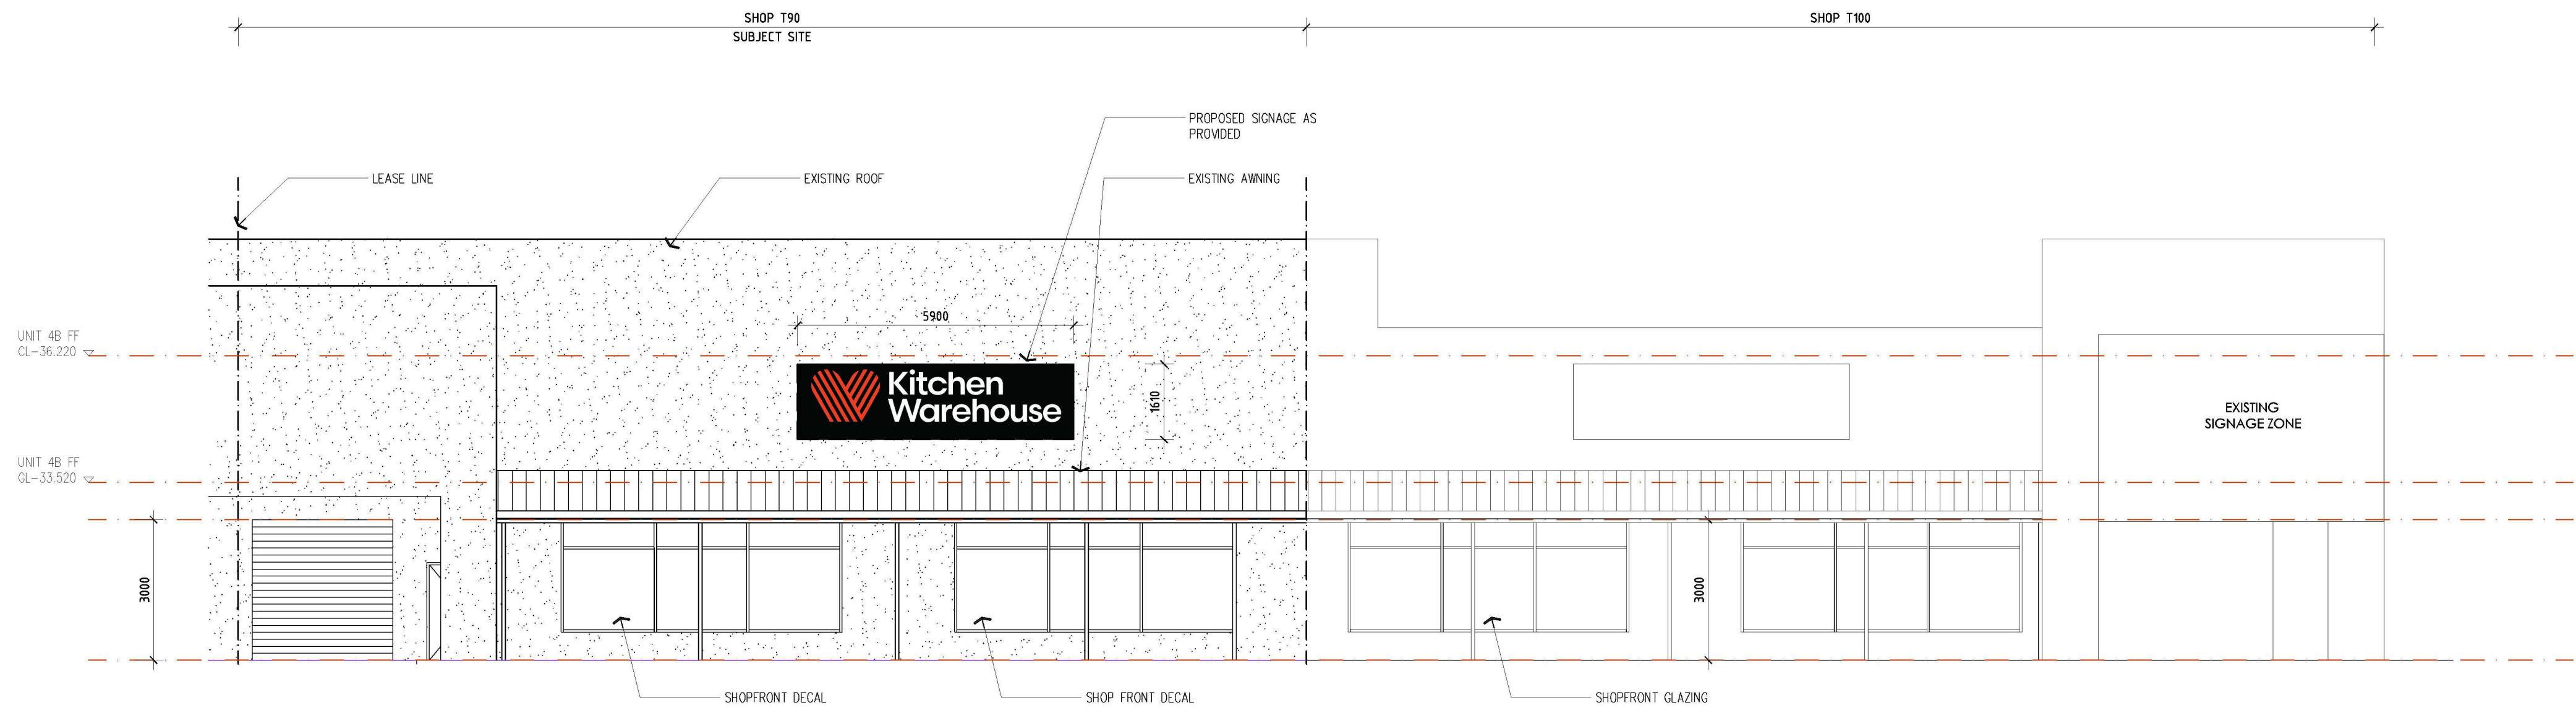


PROPOSED SOUTH ELEVATION



PROPOSED EXTERNAL SIGN DETAILS

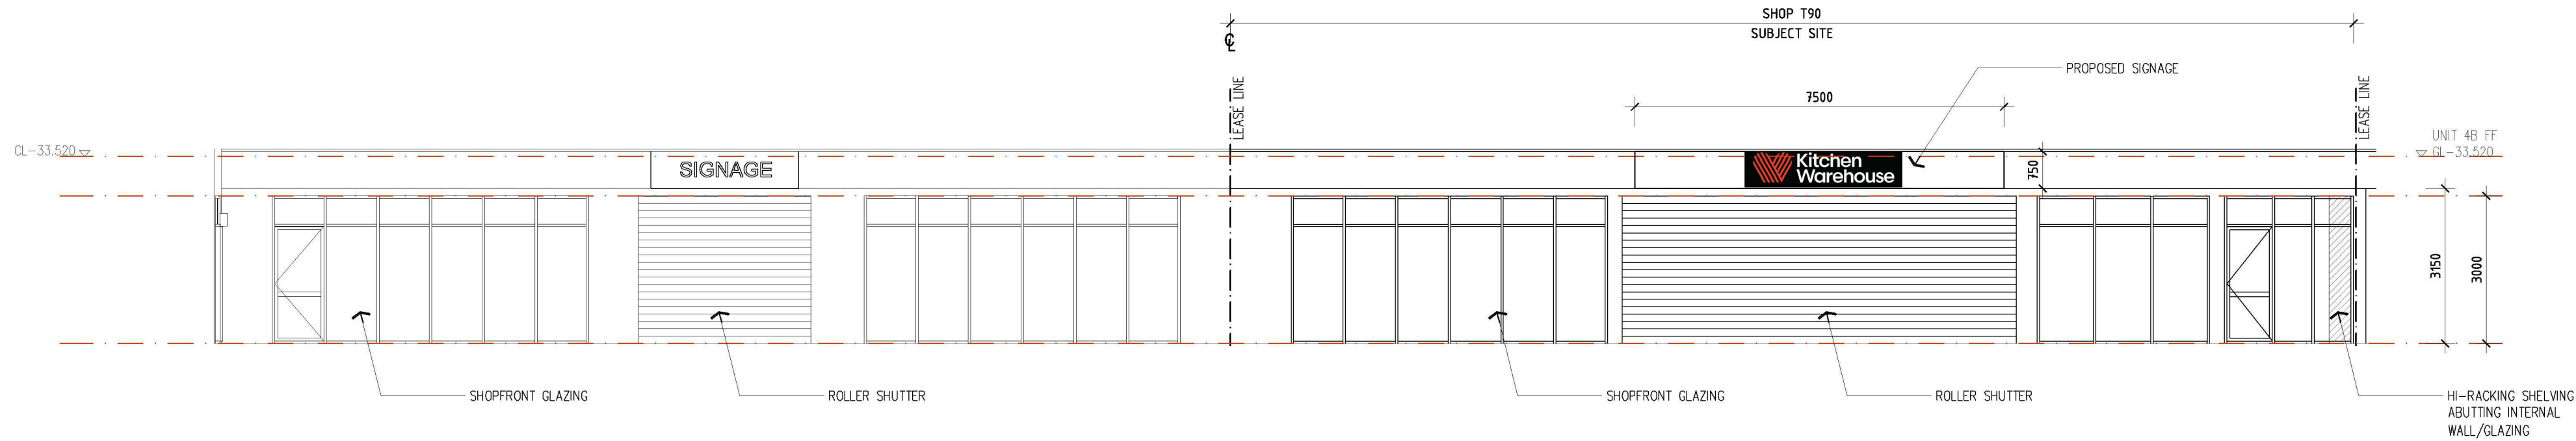

PROPOSED NORTHERN ELEVATION

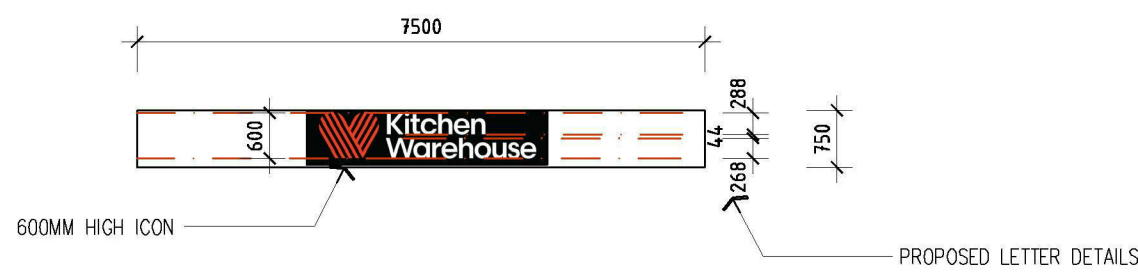


PROPOSED INTERNAL SIGN DETAILS

Rev:	Date:	Issue:

KITCHEN WAREHOUSE

Drawing Title:	ELEVATIONS
Date: 12th March 2019	Council: PENRITH
Scale: 1:100 @ A1	Job No: 001

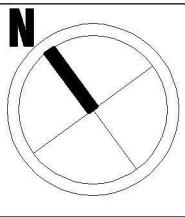

metro building designers	m: 0411 840 192
Glenn Nielsen	e: mail@metrobd.com.au
	w: www.metrobd.com.au

Project Address:	SHOP T90
	HARVEY NORMAN CENTRE
	MULGOA, PENRITH 2750


Drawing:	A04
----------	-----

ELEVATIONS:


DO NOT SCALE DRAWINGS, FIGURED DIMENSIONS TAKE PRECEDENCE

BUILDER SHALL CHECK AND VERIFY ALL DIMENSIONS ON SITE AND REPORT ANY DISCREPANCIES TO THE BUILDING DESIGNER PRIOR TO THE COMMENCEMENT OF WORK


CONTRACTOR MUST VERIFY ALL DIMENSIONS ON SITE BEFORE COMMENCING ANY WORK OR PREPARING SHOP DRAWINGS WHICH MUST BE APPROVED BY THE BUILDING DESIGNER BEFORE MANUFACTURE. ANY EXTRA ENTAILED IN WORK SHOWN ON THIS DRAWING MUST BE CLAIMED AND APPROVED BEFORE PROCEEDING.

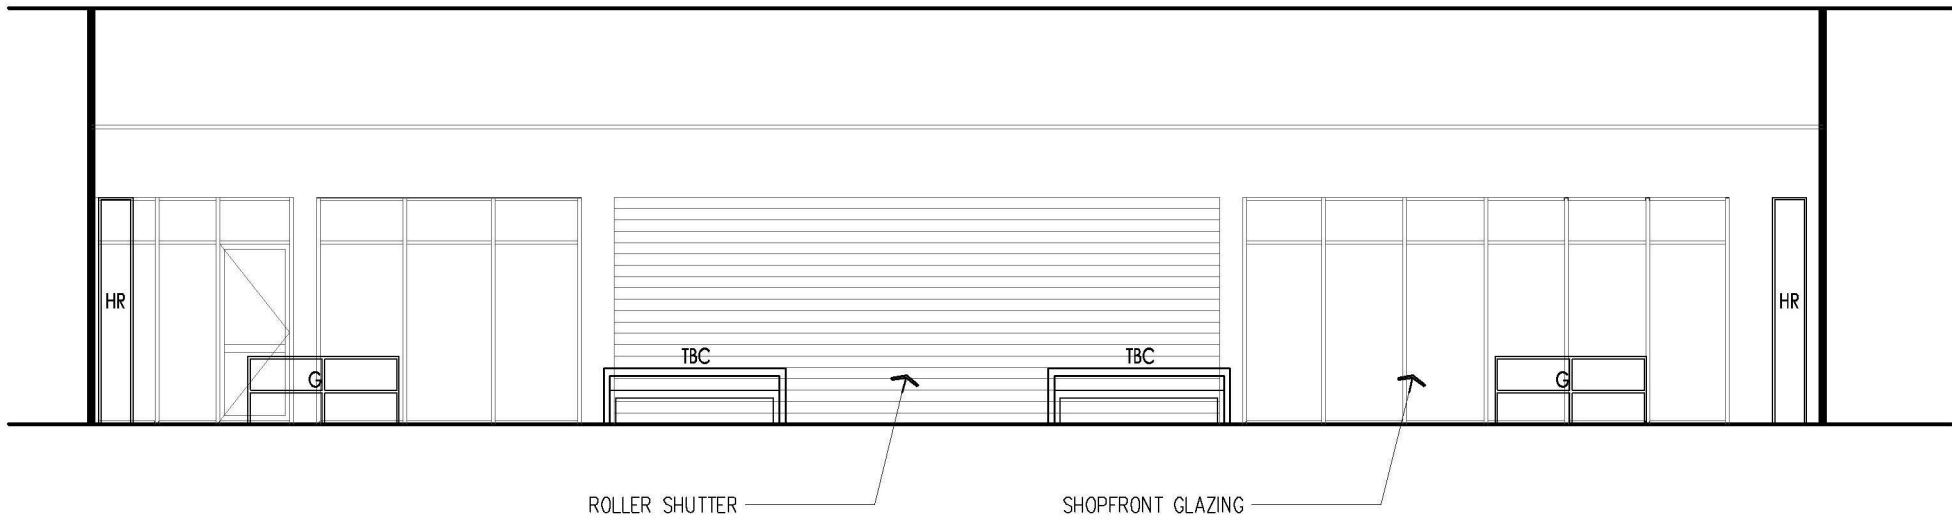


INTERNAL ELEVATION X-X

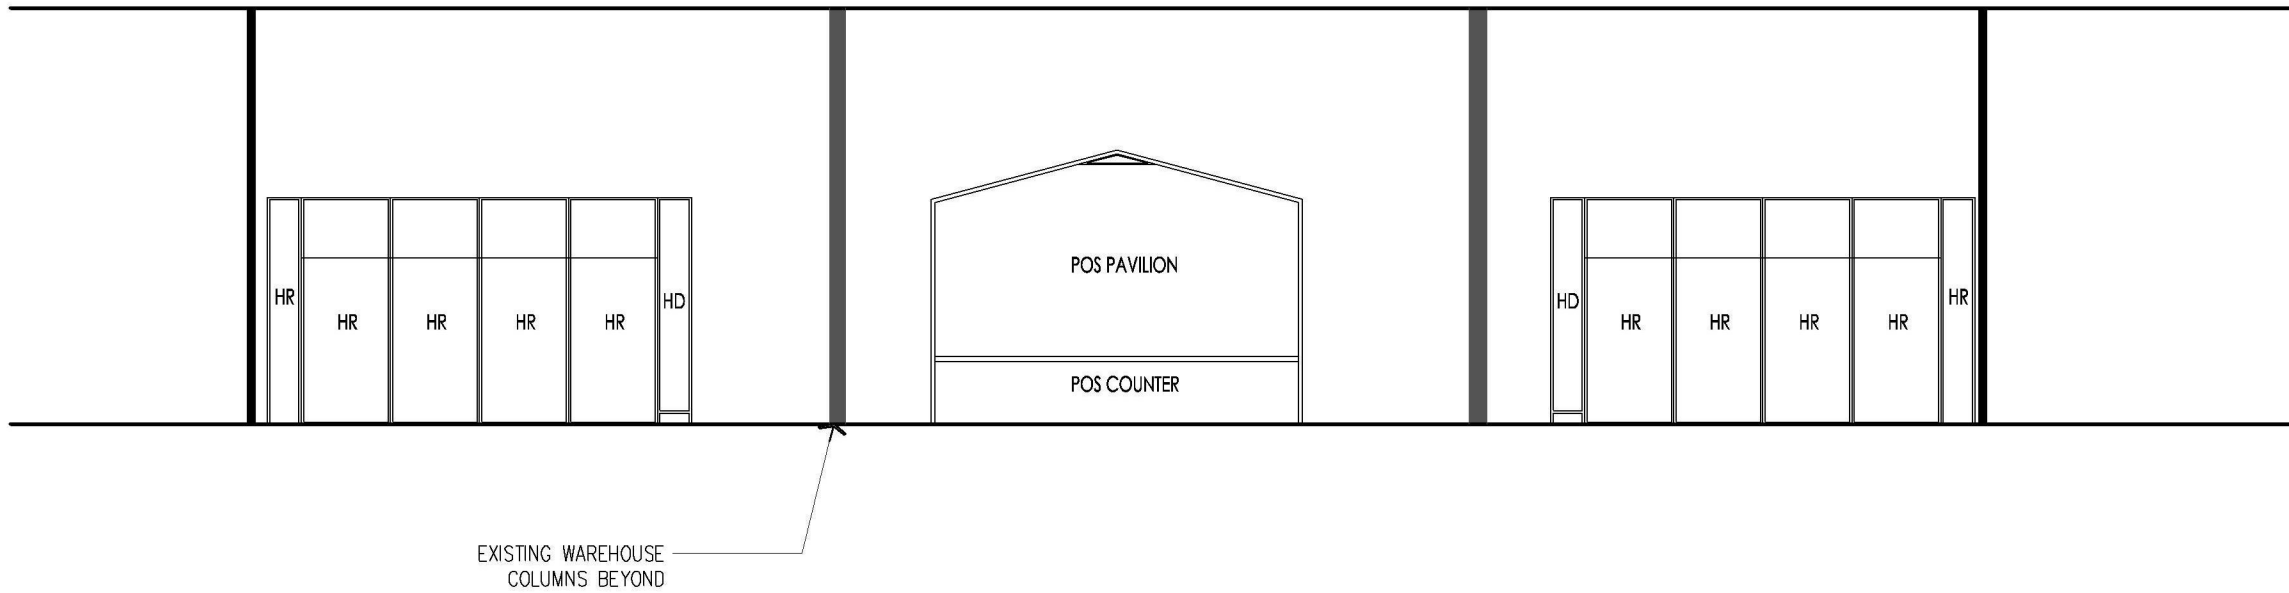


INTERNAL ELEVATION Y-Y

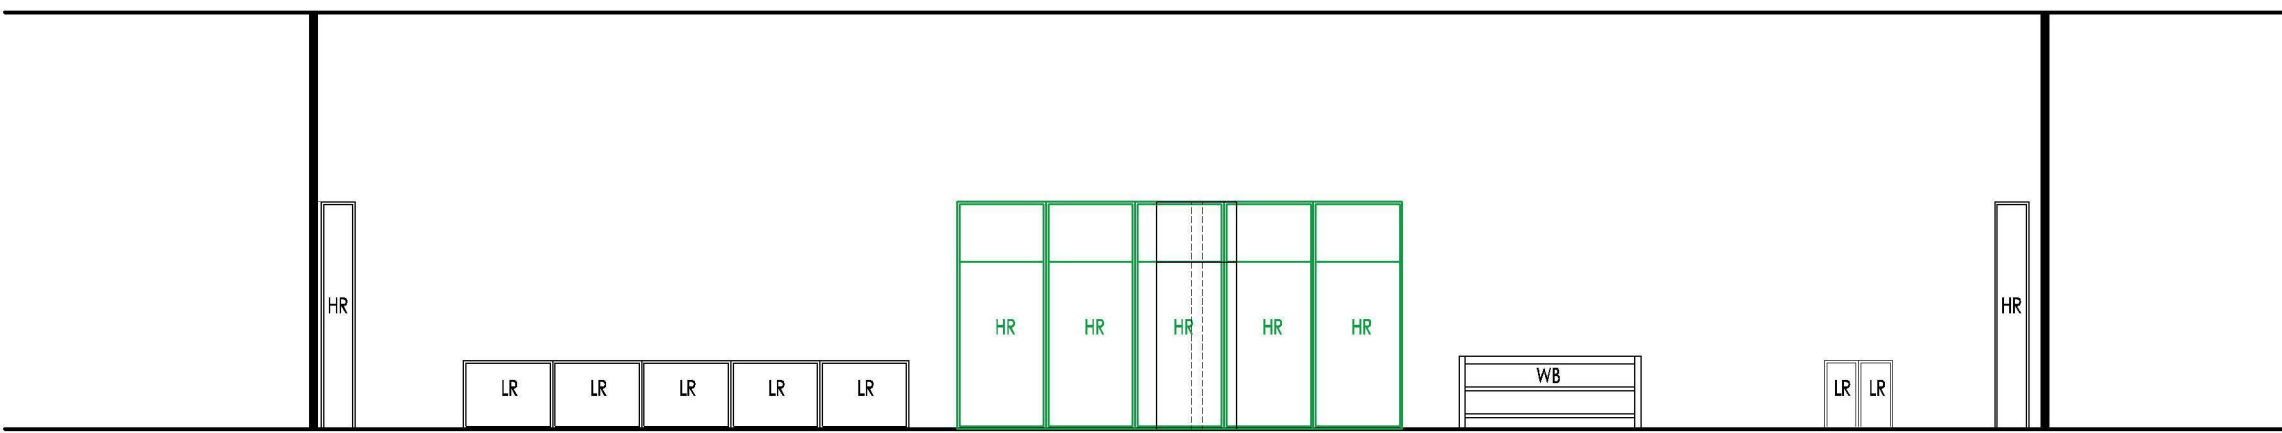


INTERNAL ELEVATION Z-Z

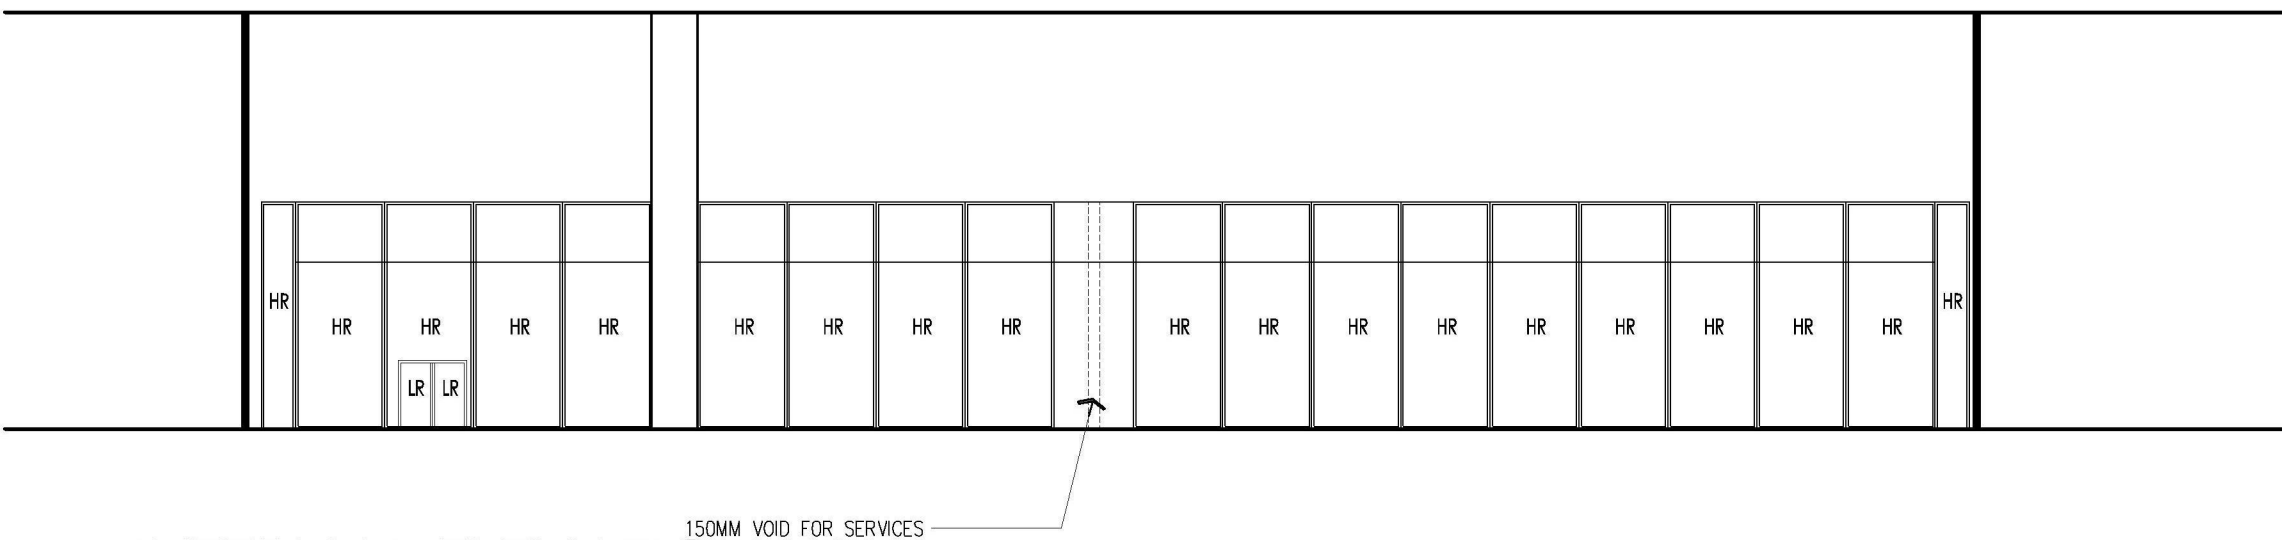


INTERNAL ELEVATION W-W

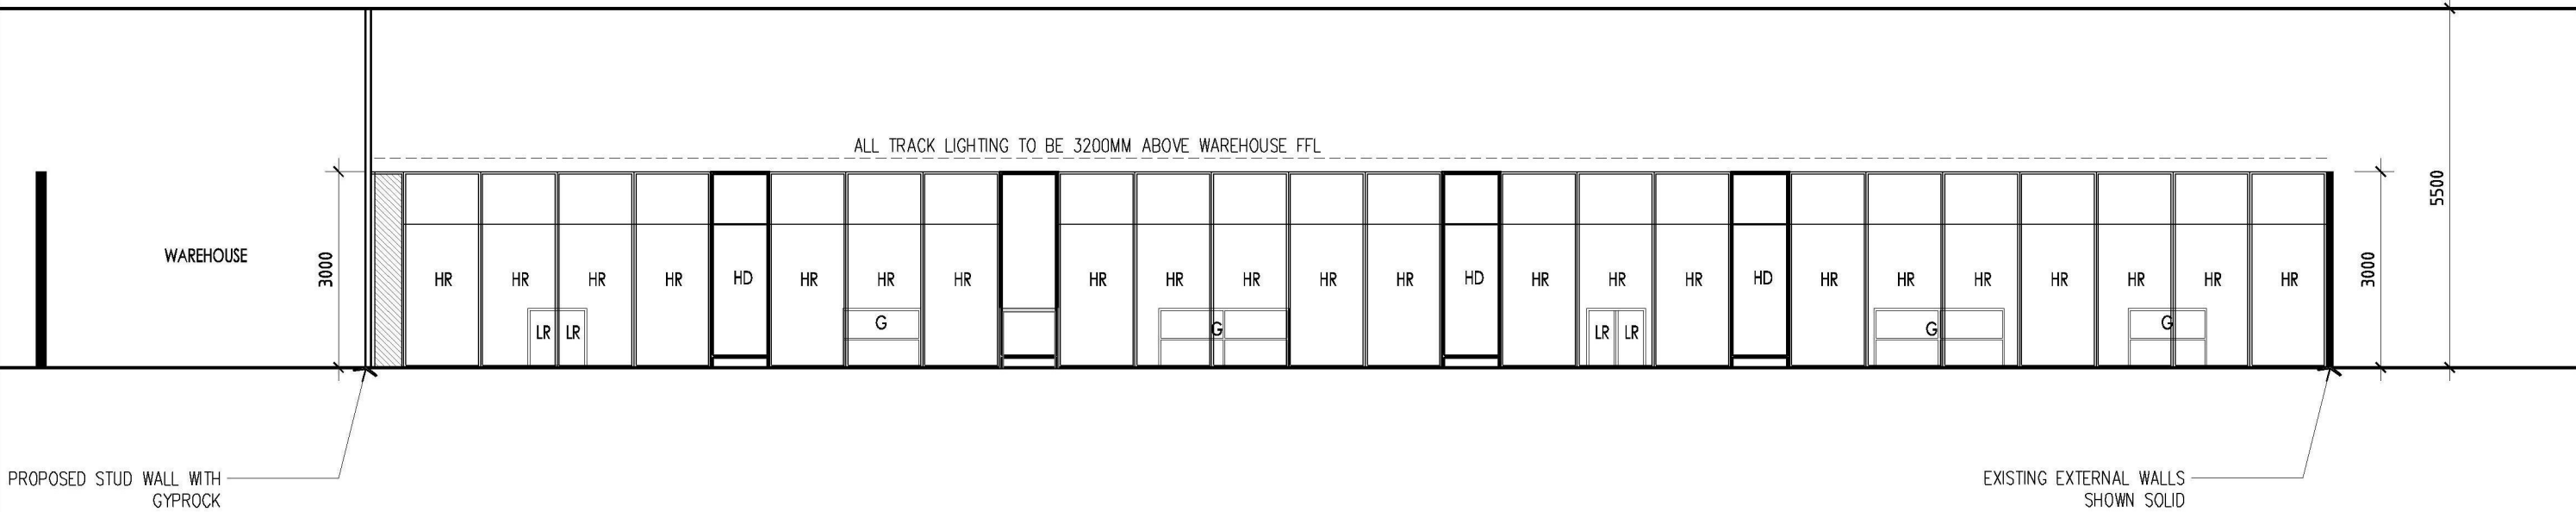


INTERNAL ELEVATION V-V

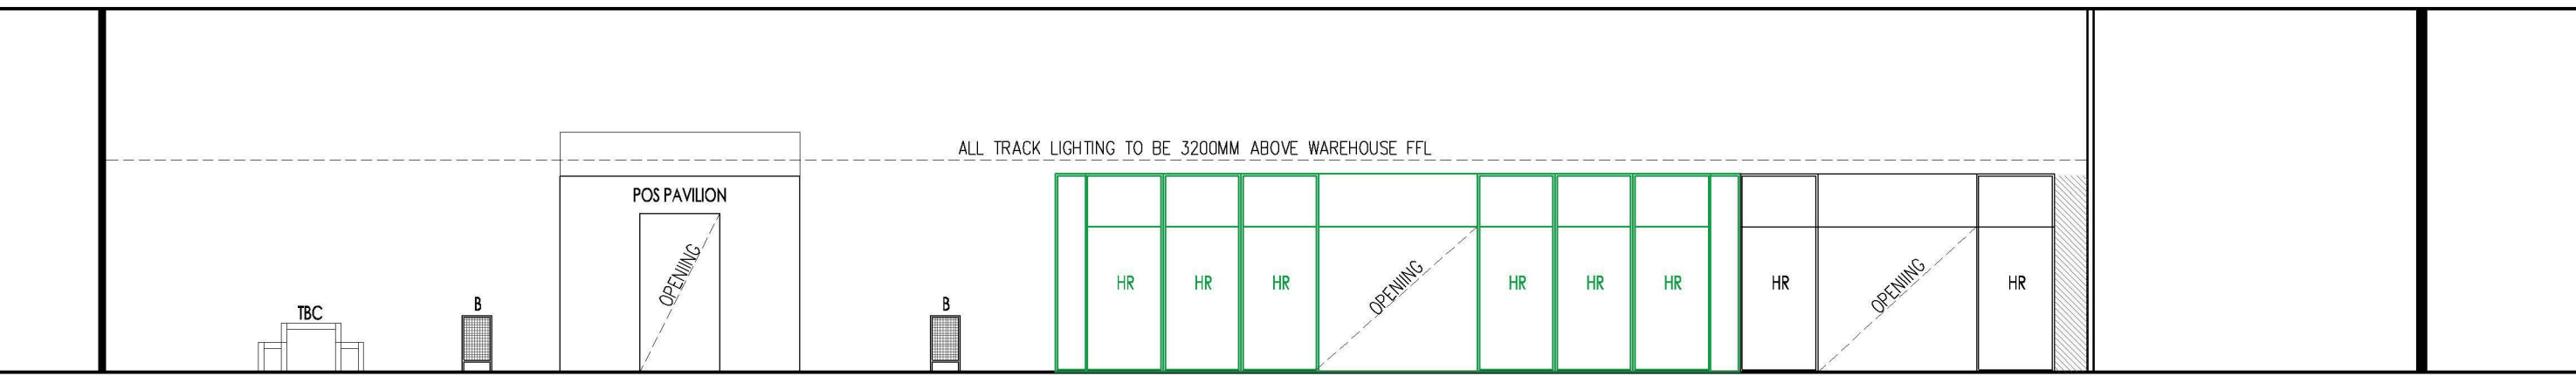

INTERNAL ELEVATION U-U

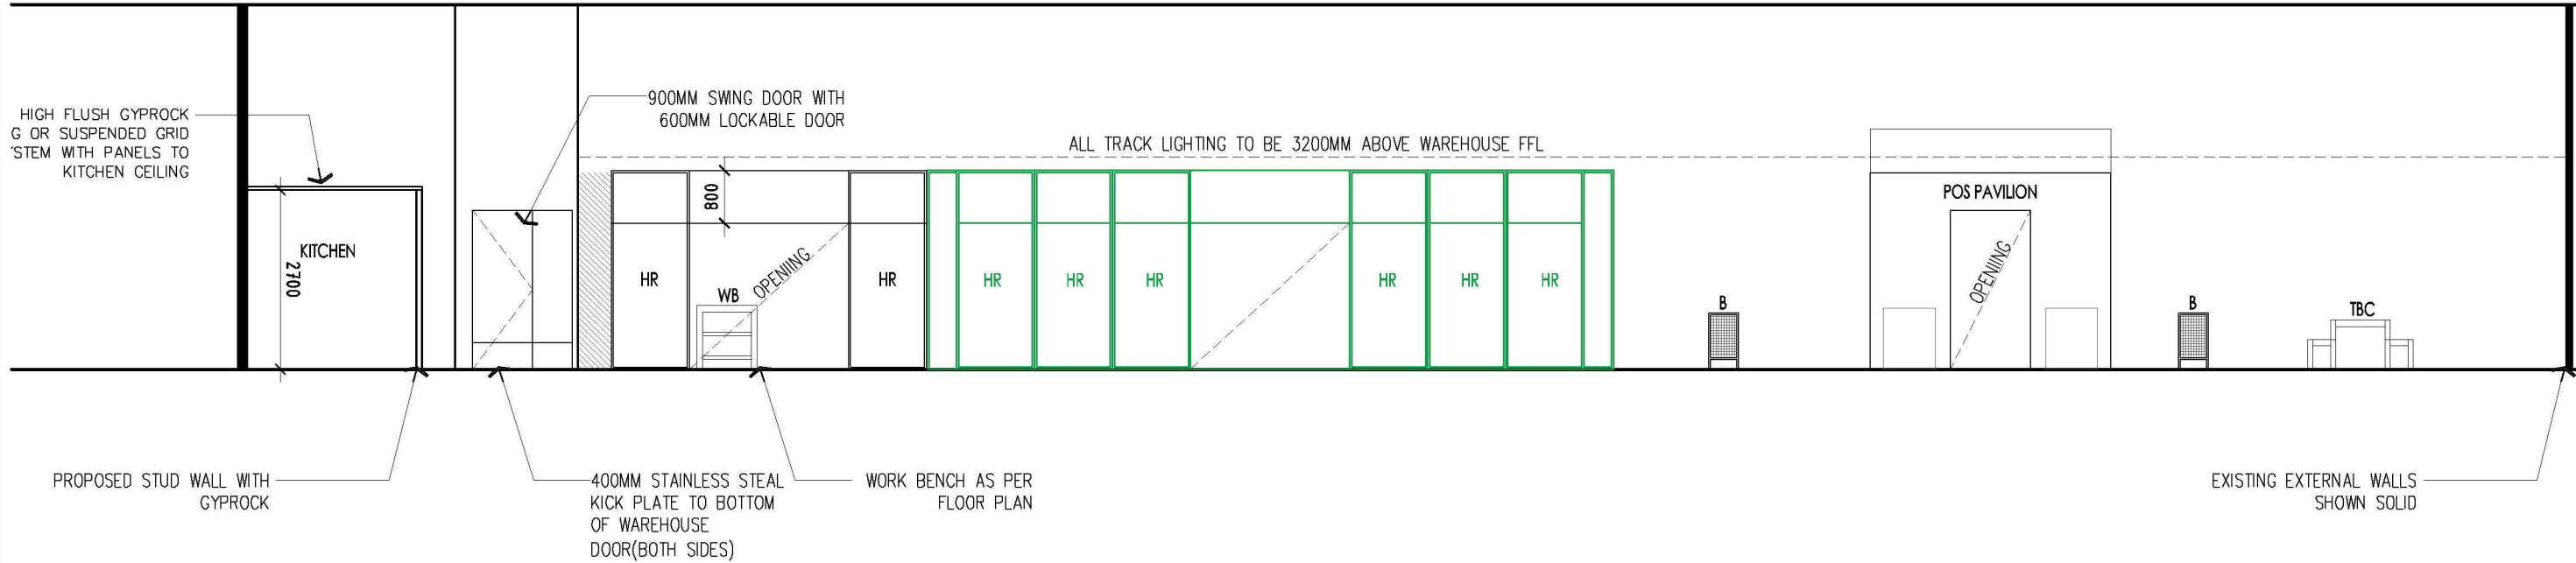

INTERNAL ELEVATION T-T

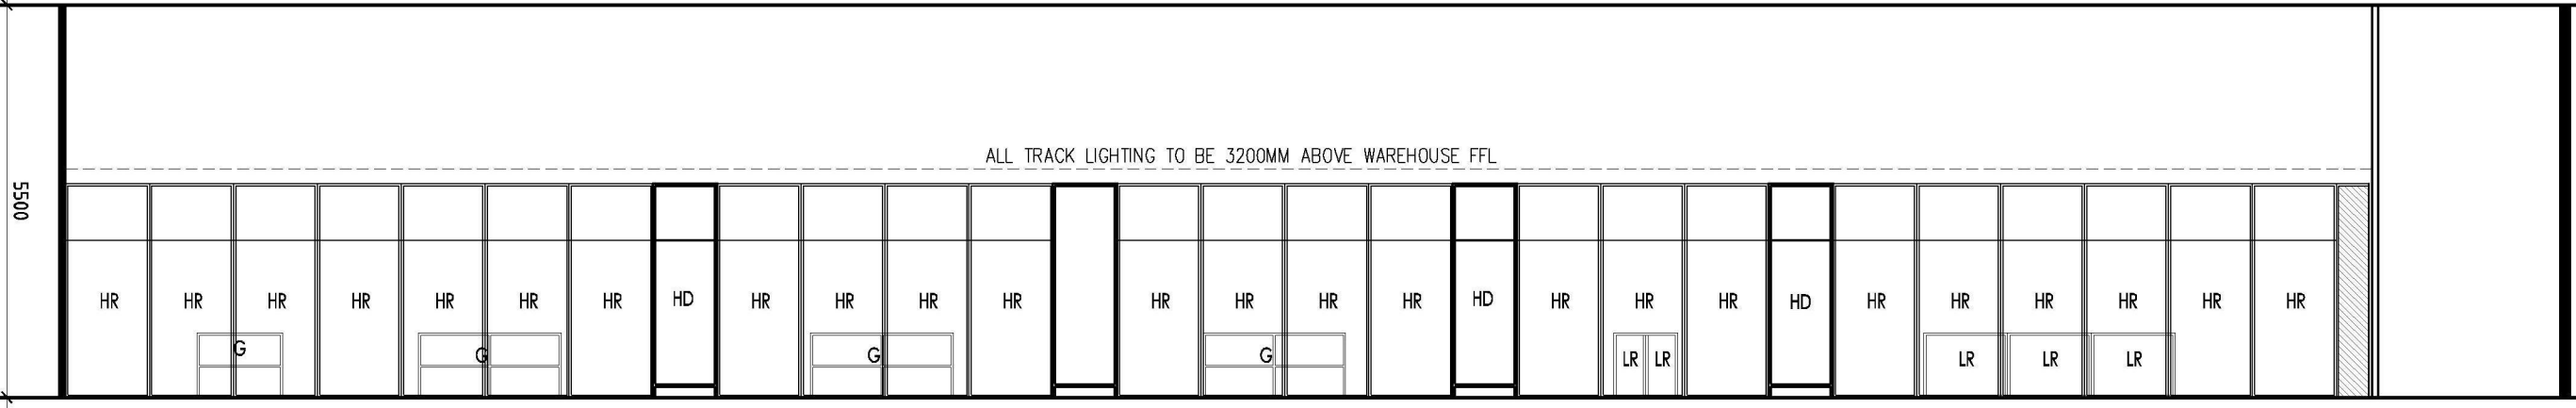

INTERNAL ELEVATION S-S

Rev:	Date:	Issue:

KITCHEN WAREHOUSE

Drawing Title:	ELEVATIONS
Date: 12th March 2019	Council: PENRITH
Scale: 1:100 @ A1	Job No: 001


Kitchen Warehouse

metro building designers	m: 0411 840 192
Glenn Nielsen	e: mail@metrobd.com.au
	w: www.metrobd.com.au

Project Address:
SHOP T90
HARVEY NORMAN CENTRE
MULGOA, PENRITH 2750

Drawing:
A03

PLAN OF
GROSS LETTABLE AREA RETAIL (G.L.A.R)
SHOP T 90/T90A, HARVEY NORMAN CENTRE
MULGOA ROAD, PENRITH

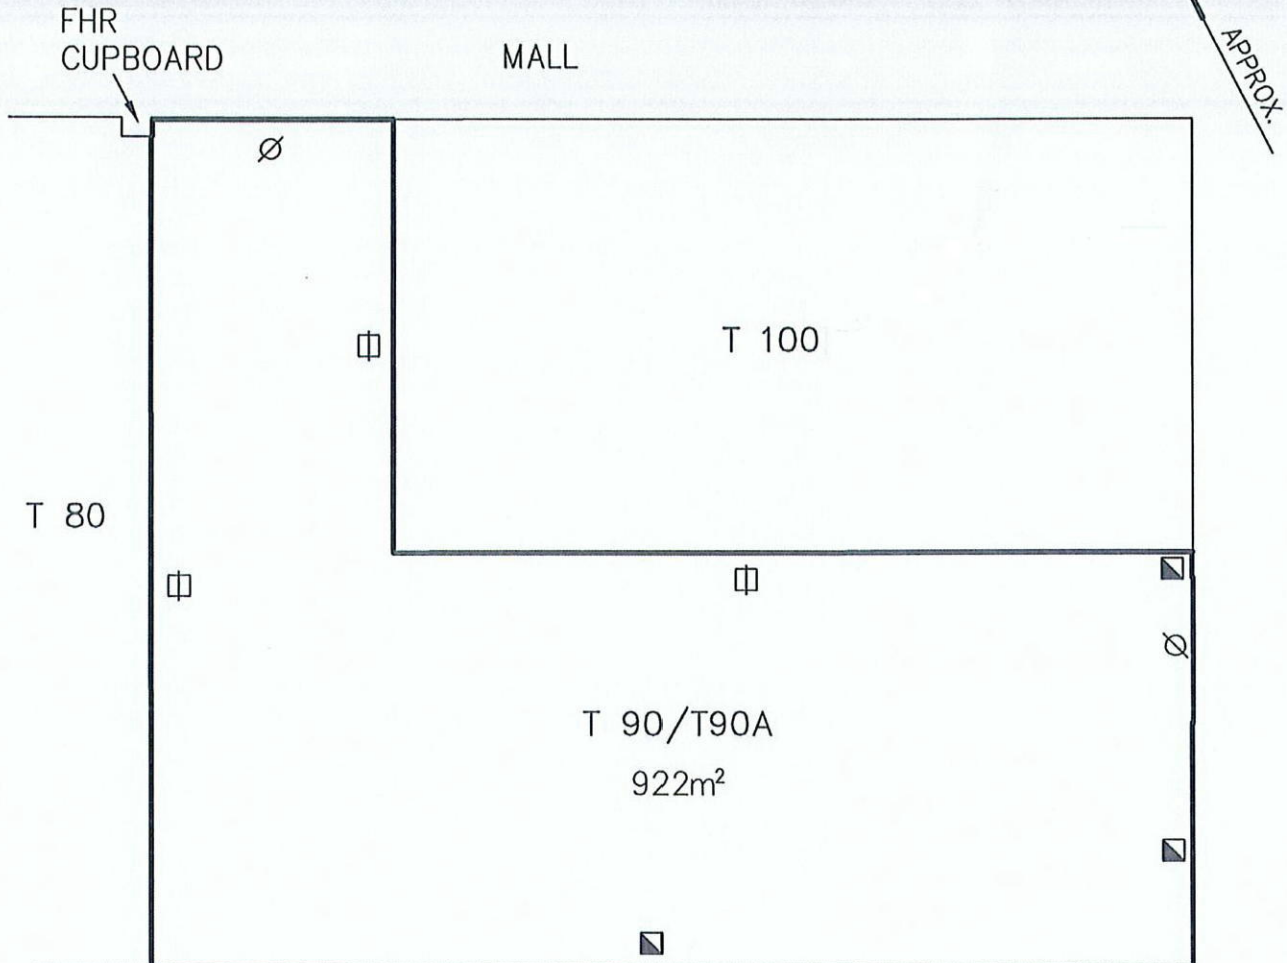

BOUNDARY TYPE LEGEND:

- - INSIDE FACE WALL
- ⊞ - CENTRELINE OF WALL
- ⊙ - EXTERNAL FACE OF GLASS

GROSS LETTABLE AREA RETAIL (GLAR):

MEASURED IN ACCORDANCE WITH THE PROPERTY
COUNCIL OF AUSTRALIA METHOD OF
MEASUREMENT MARCH 1997.

NOTE: - ALL AREAS HAVE BEEN ROUNDED TO
THE NEAREST WHOLE METRE.

LENGTHS AND AREAS ARE IN METRES


SCALE: 1: 250

DATE: 18/11/11

REF: 34449

Mr Lockley

REGISTERED SURVEYOR

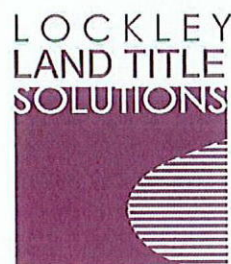


Registered
Surveyors NSW
19 Massey Street
Gladesville NSW 2111
PO BOX 400
Gladesville NSW 1675
ph: (02) 9879 6077
fax: (02) 9789 7143

ELECTRICAL & LIGHTING PLAN:


DO NOT SCALE DRAWINGS, FIGURED DIMENSIONS TAKE PRECEDENCE

BUILDER SHALL CHECK AND VERIFY ALL DIMENSIONS ON SITE AND REPORT ANY DISCREPANCIES TO THE BUILDING DESIGNER PRIOR TO THE COMMENCEMENT OF WORK

CONTRACTOR MUST VERIFY ALL DIMENSIONS ON SITE BEFORE COMMENCING ANY WORK OR PREPARING SHOP DRAWINGS WHICH MUST BE APPROVED BY THE BUILDING DESIGNER BEFORE MANUFACTURE. ANY EXTRA ENTAILED IN WORK SHOWN ON THIS DRAWING MUST BE CLAIMED AND APPROVED BEFORE PROCEEDING.

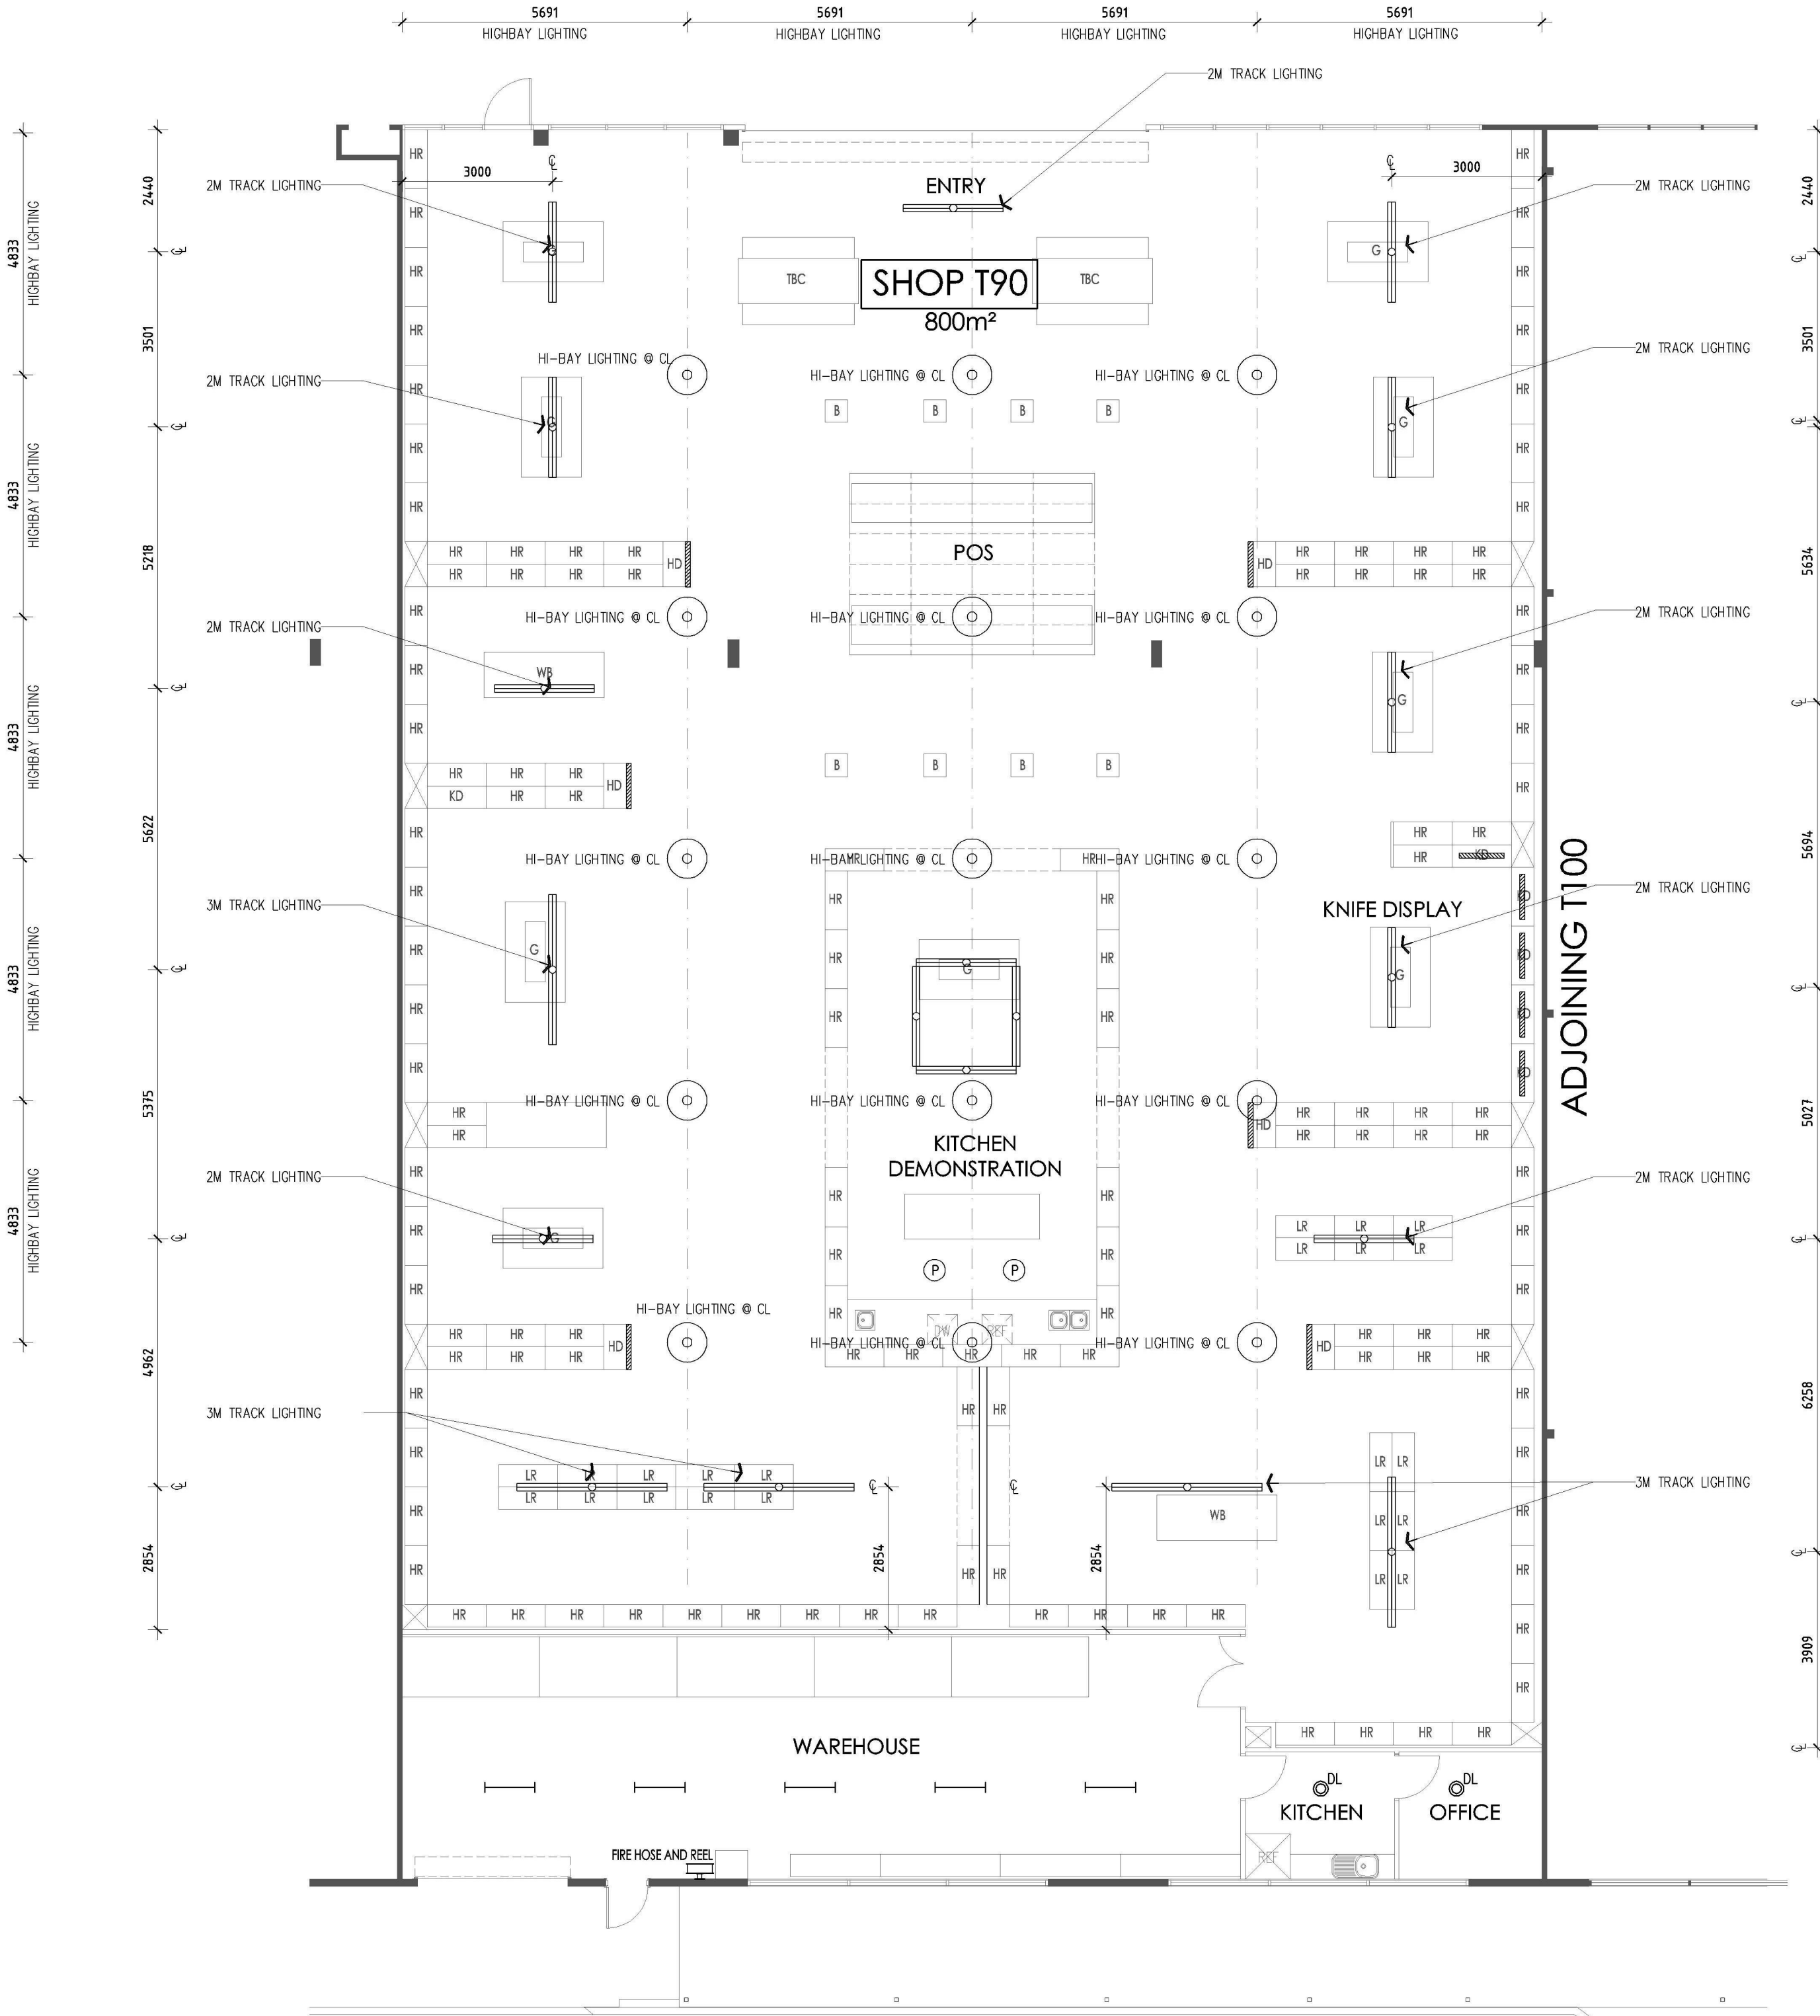

PROPOSED LIGHTING PLAN

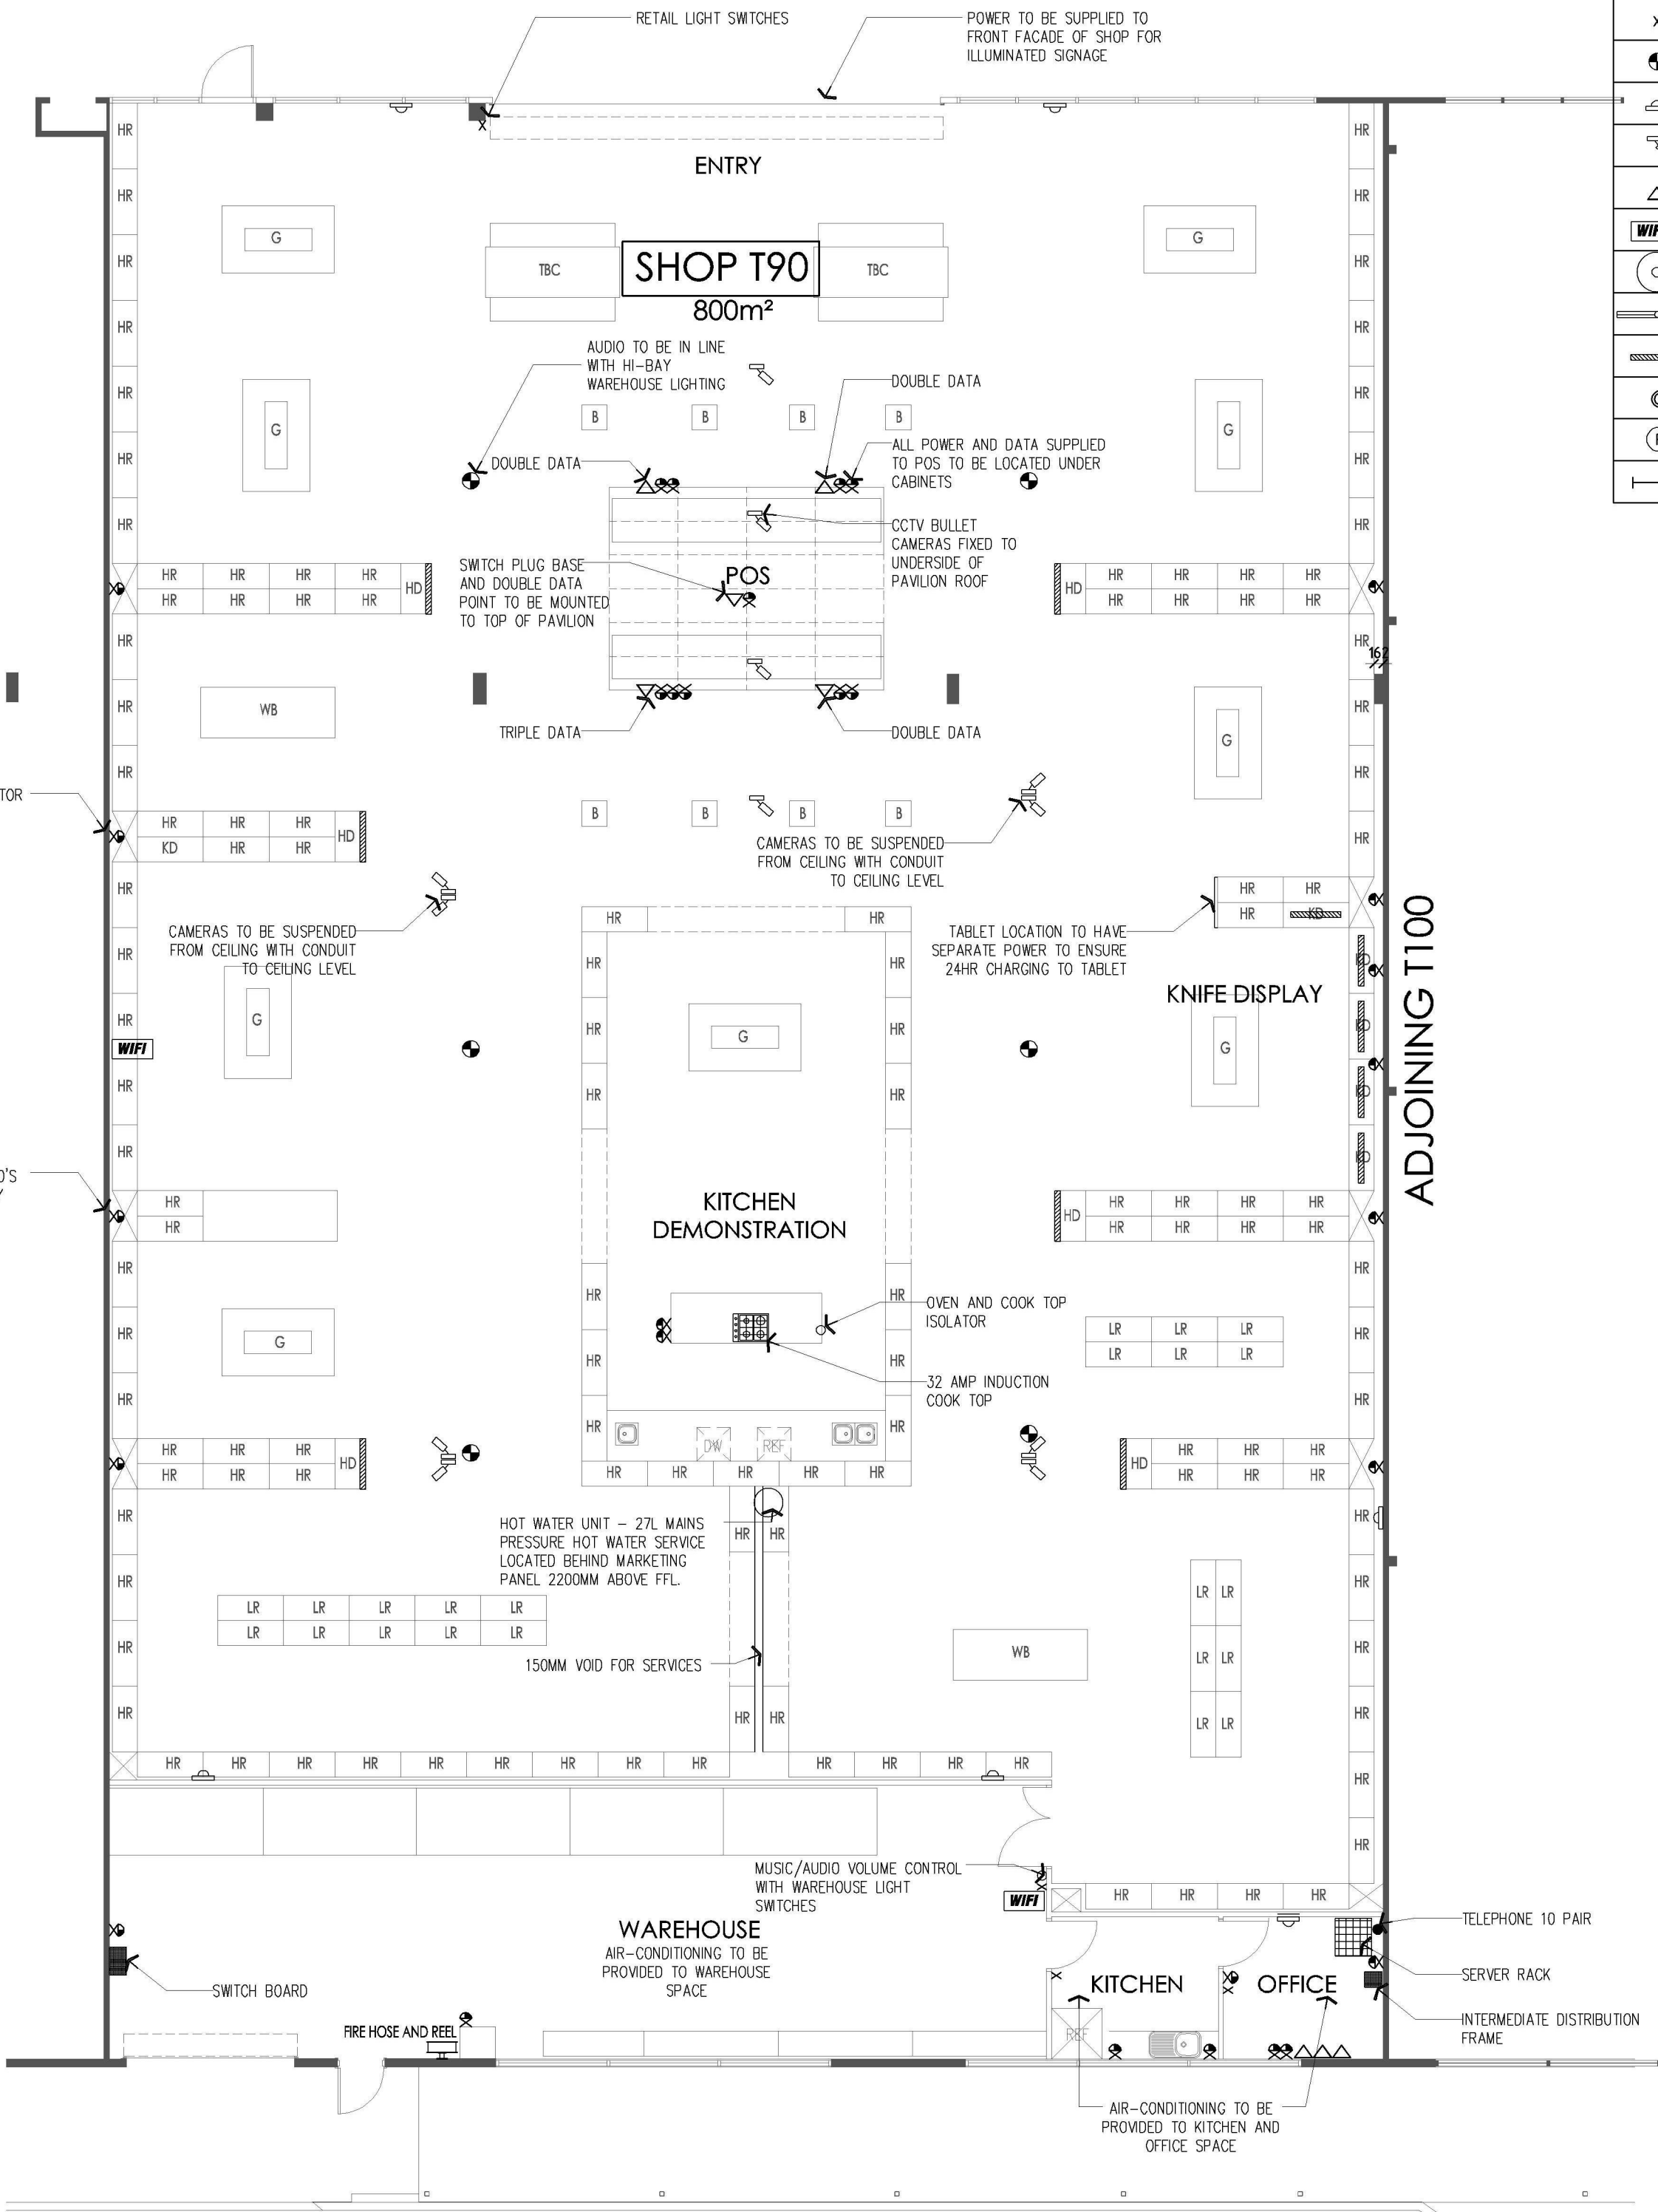


PROPOSED ELECTRICAL PLAN

LEGEND	
	DOUBLE POWER POINT
	LIGHT SWITCH
	AUDIO POINT AT 3200MM ABOVE FFL
	CCTV DOME CAMERA AT 3400MM ABOVE FFL
	CCTV BULLET CAMERA
	DATA POINT - AS SPECIFIED
	WIFI AT 3400MM ABOVE FFL
	HI-BAY WAREHOUSE LIGHTING @ CL
	TRACK LIGHTING AT 3200MM ABOVE FFL
	LED STRIP LIGHTING (INCORPORATED INTO FIXTURE)
	DOWN LIGHT
	PENDANT LIGHT AS SELECTED
	FLUORESCENT TUBE

Rev:	Date:	Issue:

KITCHEN WAREHOUSE

Drawing Title:	PROPOSED PLANS
Date:	12th March 2019
Scale:	1:100 @ A1
Council:	PENRITH
Job No:	001

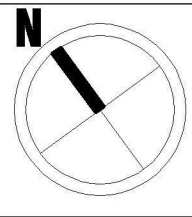

Kitchen Warehouse

metro building designers	m: 0411 840 192
Glenn Nielsen	e: mail@metrobd.com.au
	w: www.metrobd.com.au

Project Address:	SHOP T90
	HARVEY NORMAN CENTRE
	MULGOA, PENRITH 2750



Drawing:	A02
----------	-----

THIS DRAWING AND DESIGN IS SUBJECT TO COPYRIGHT
AND MAY NOT BE REPRODUCED WITHOUT PRIOR
WRITTEN CONSENT OF LEFFLER SIMES PTY LTD



ISSUE	AMENDMENT	DATE	CHK'D
P1	ISSUE FOR INFORMATION	14.10.16	IGM
P2	ISSUE FOR INFORMATION	30.06.17	IGM
P3	TP90 REDUCED FROM 1000m2 TO 800m2	24.01.18	IGM
P4	ELEVATIONS ADDED	02.11.18	IGM
P5	TP90 SHOPFRONT MODIFIED	15.11.18	IGM
P6	INFORMATION ADDED	11.03.19	IGM


PRELIMINARY

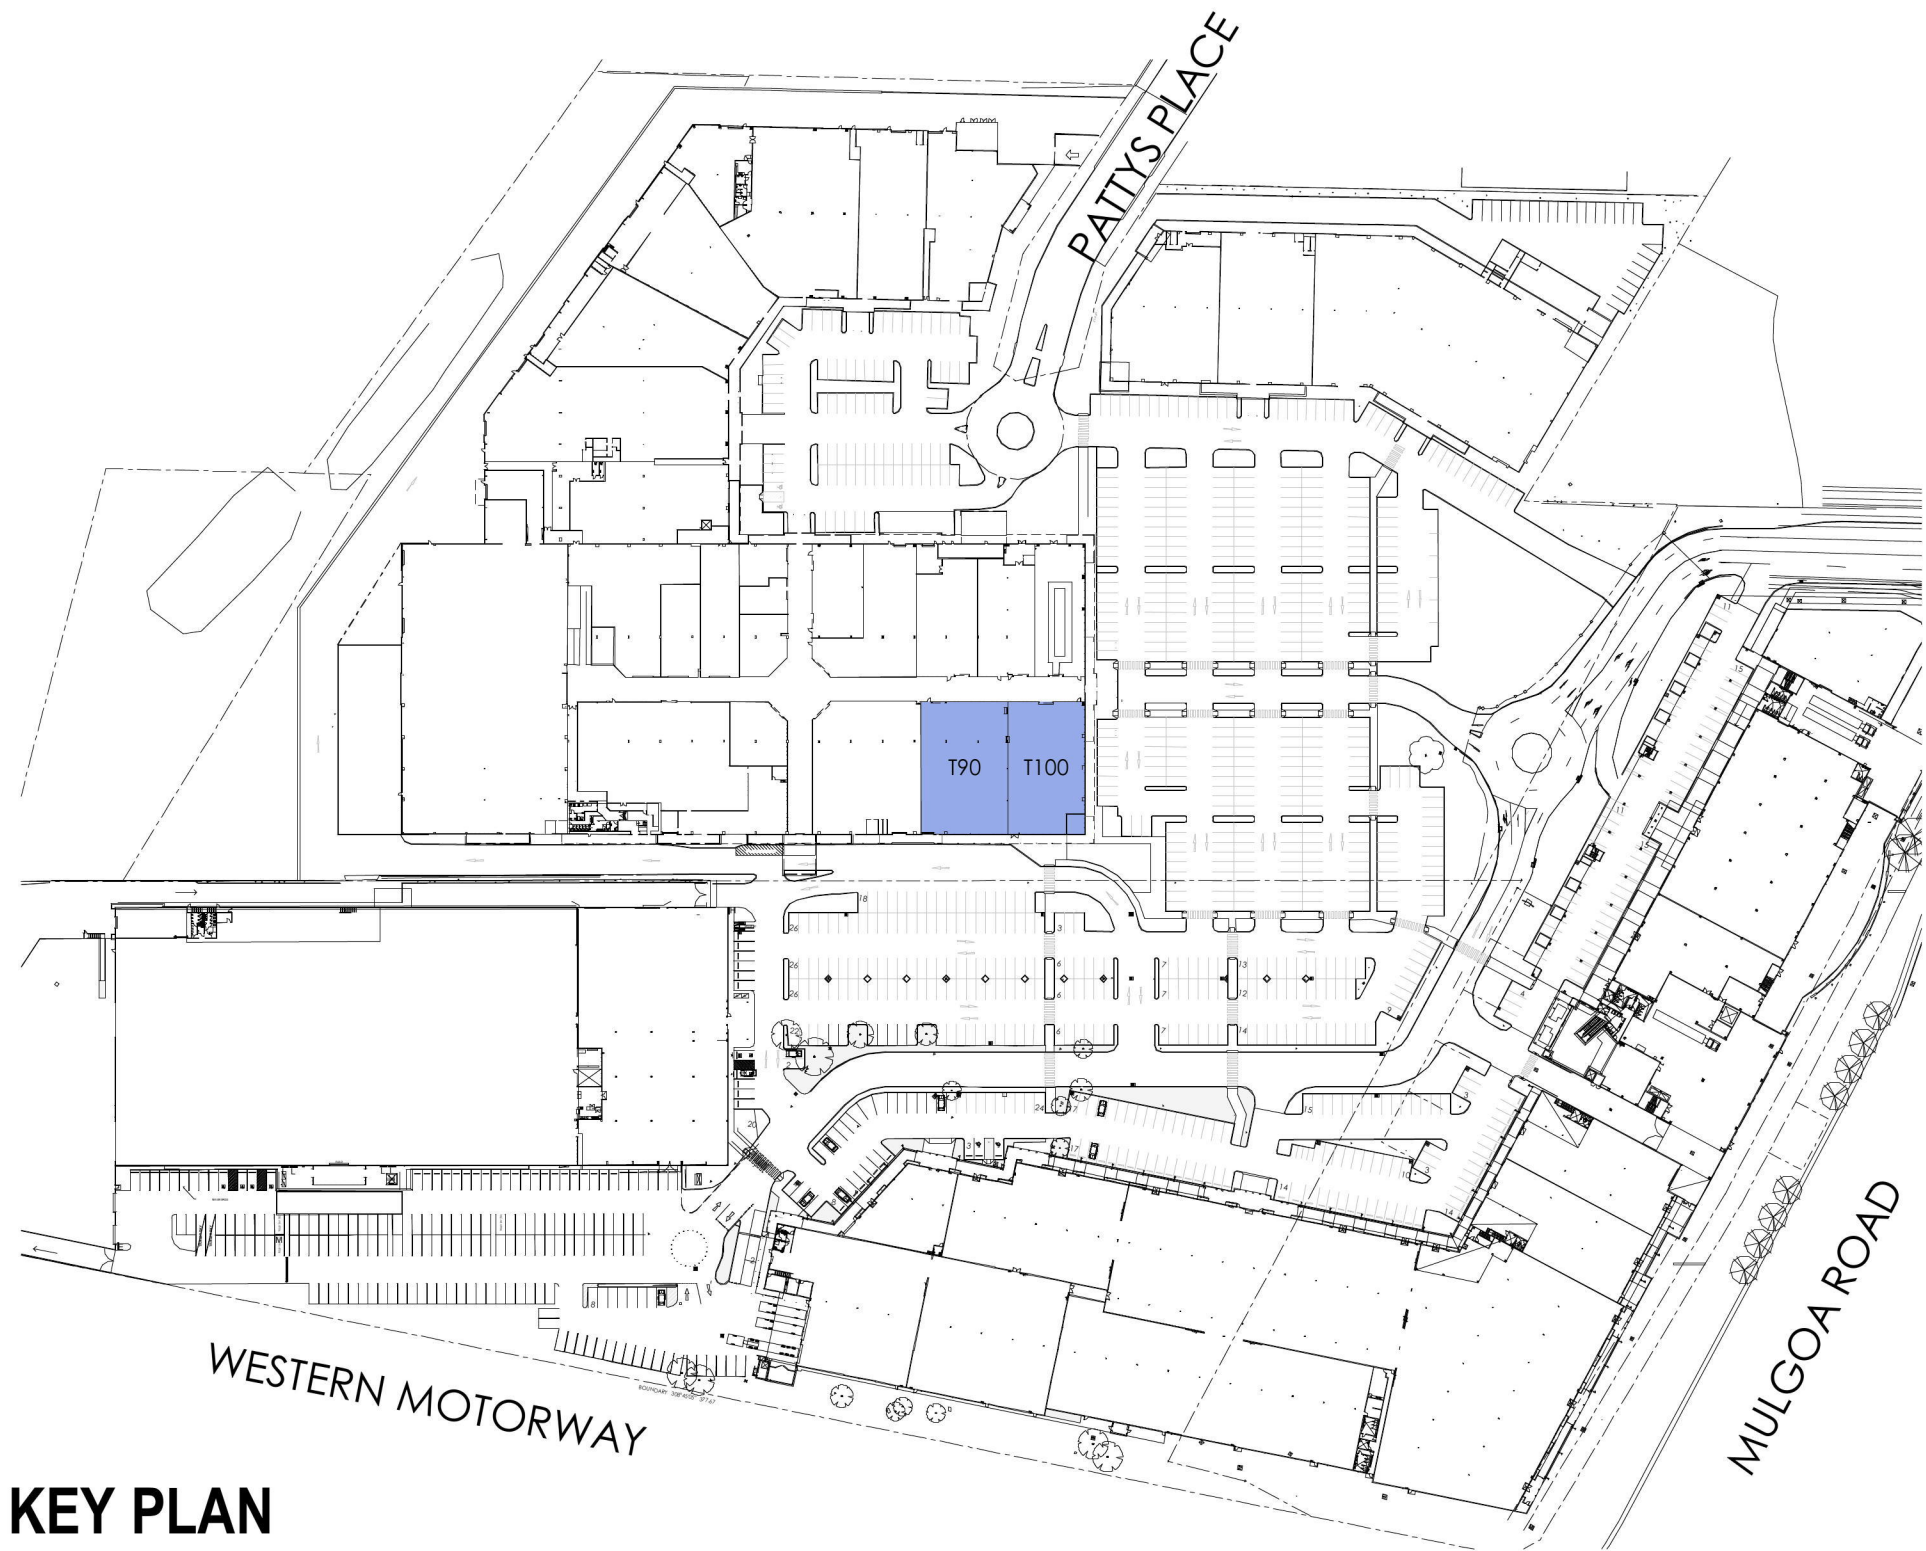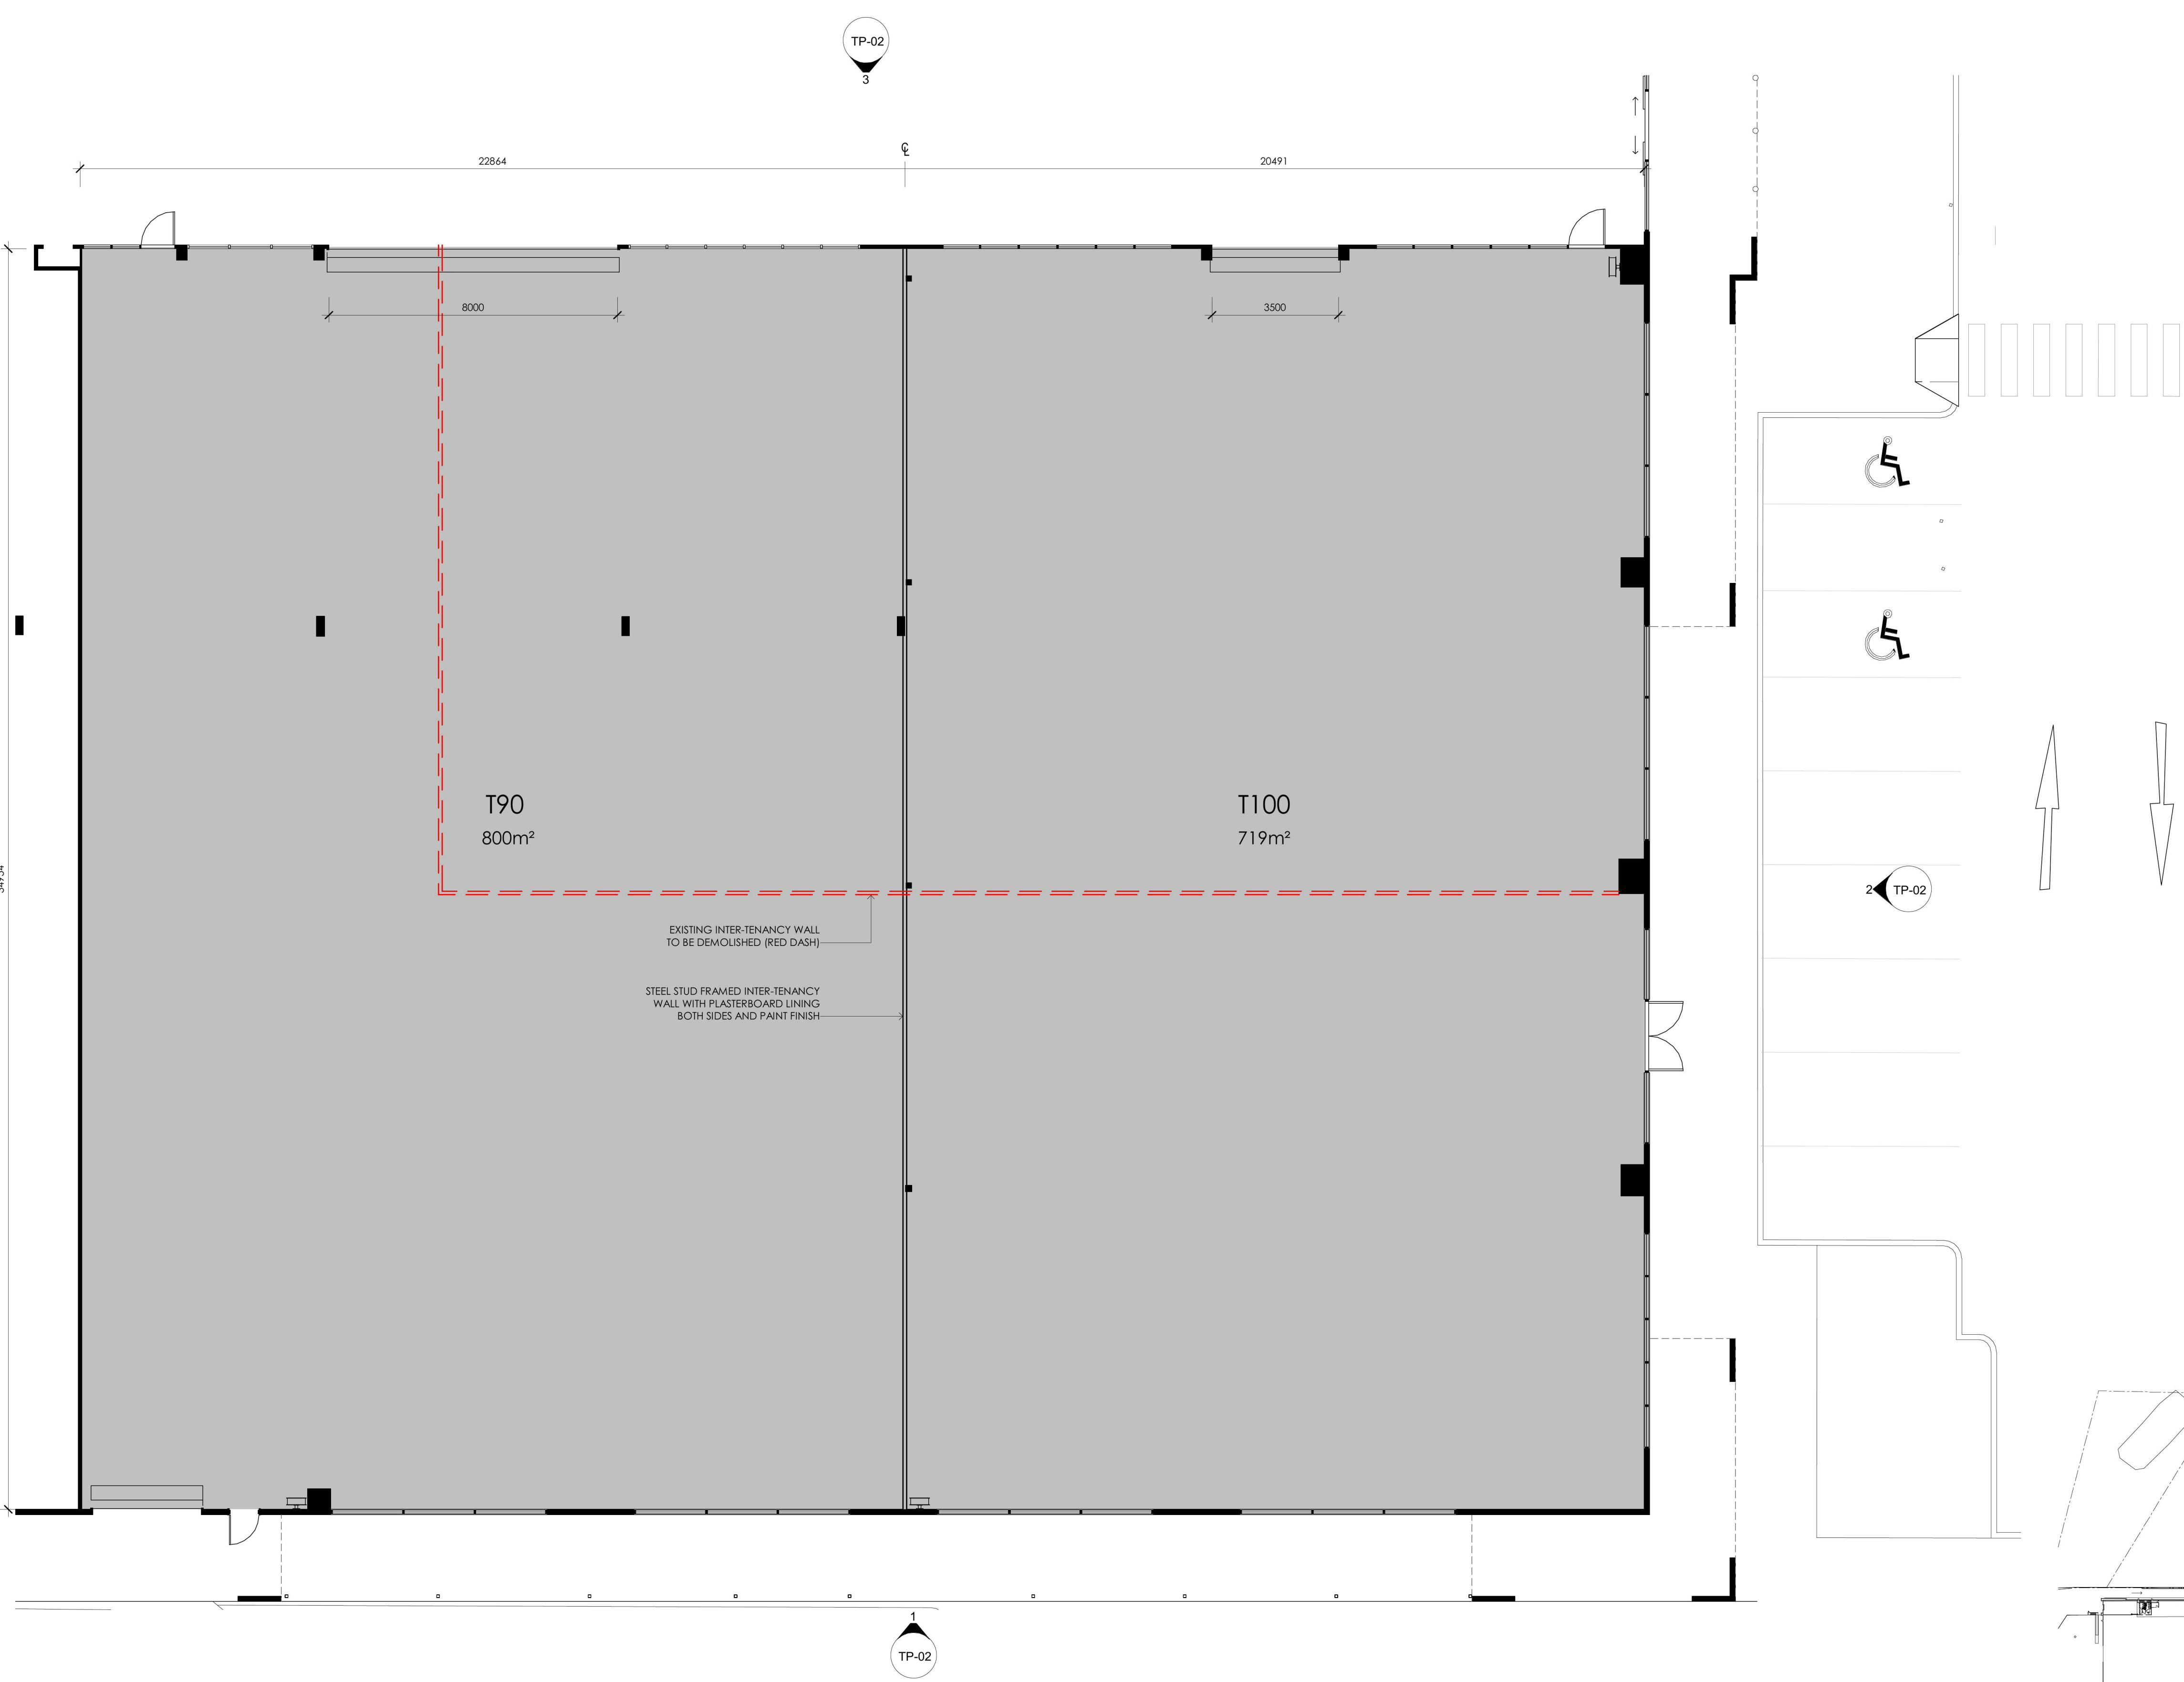


KEY PLAN

1 GROUND FLOOR_TP90-100
Scale: 1:100




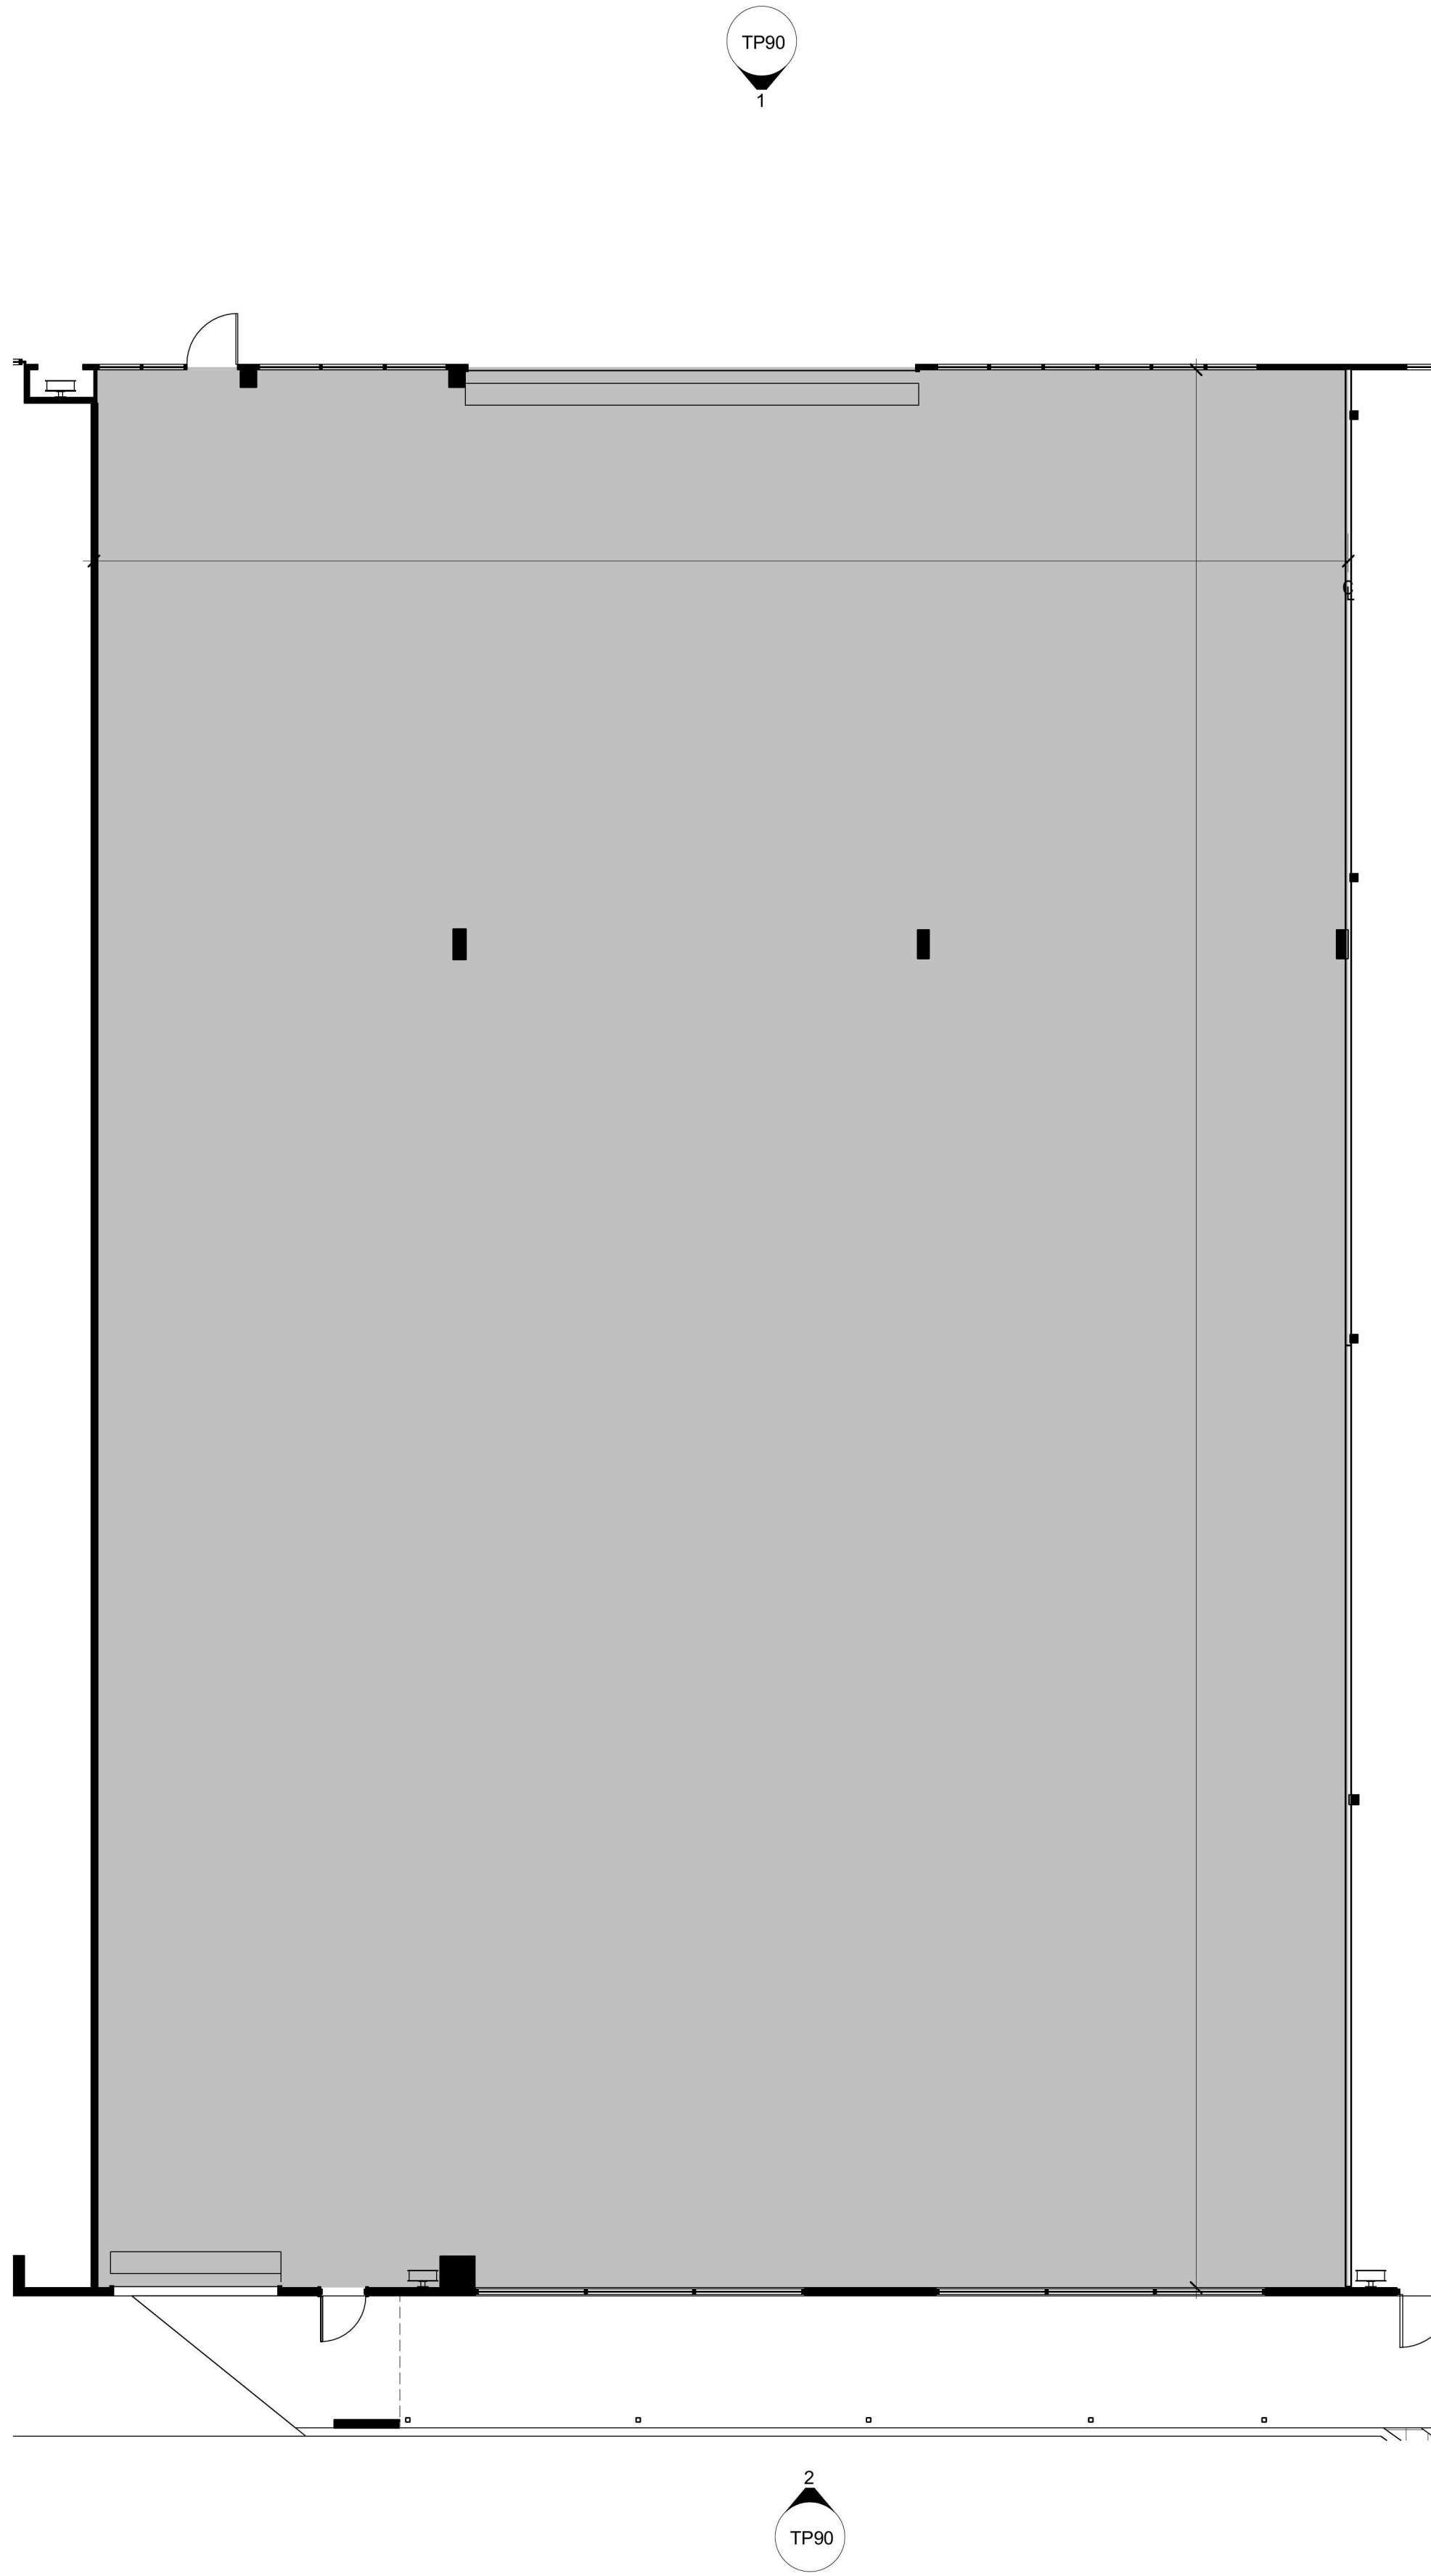


3 GROUND FLOOR
TP90 Scale: 1 : 100

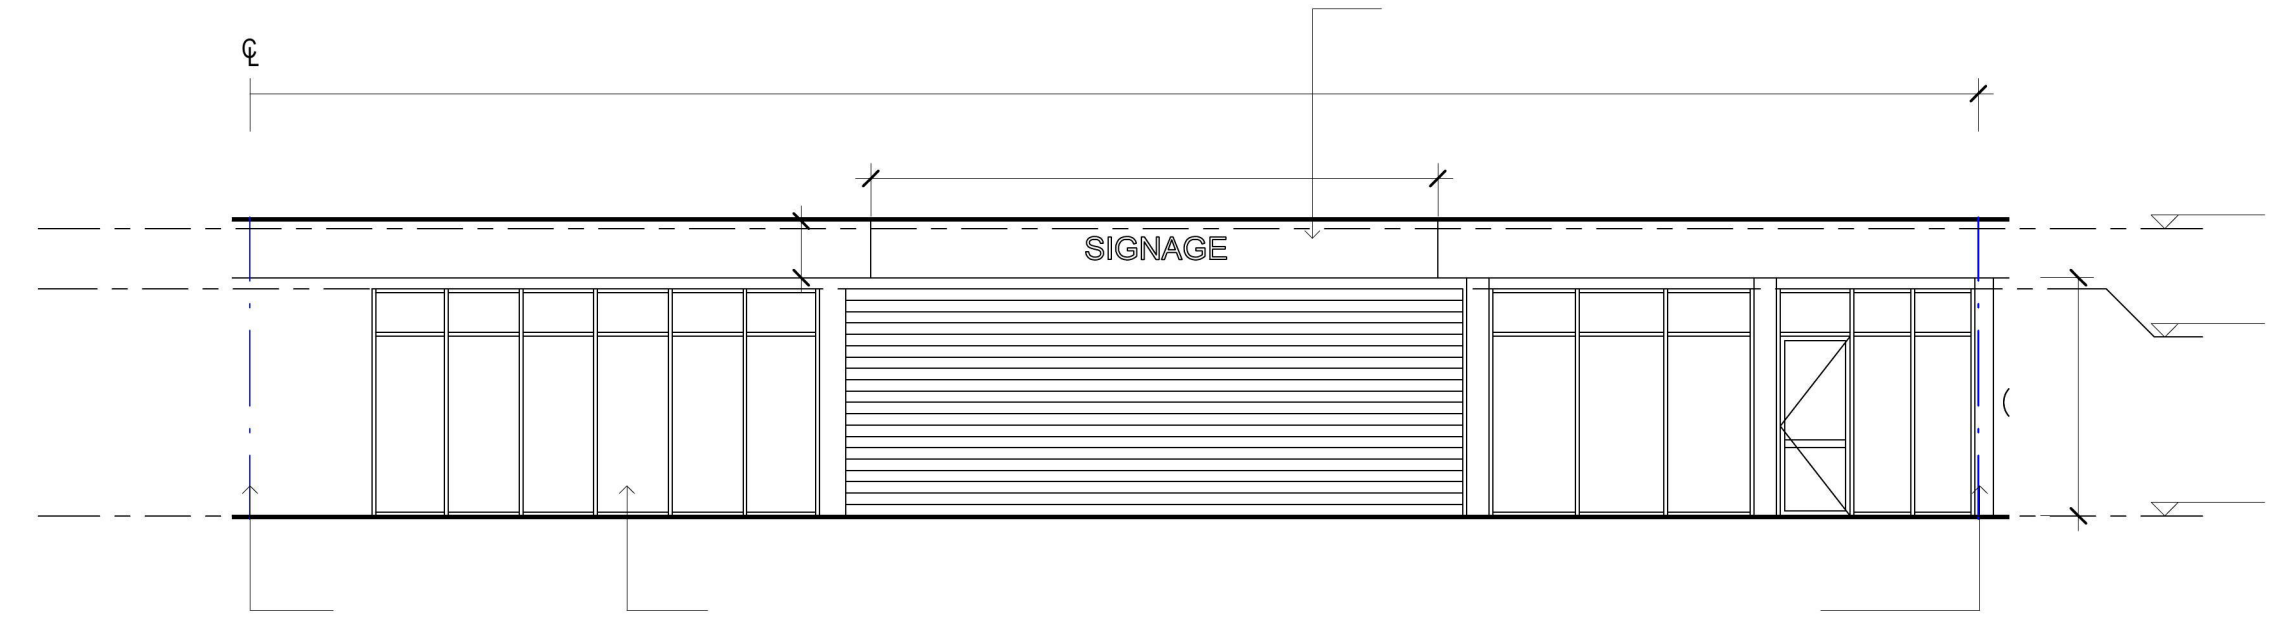

1 MALL ELEVATION
TP90 Scale: 1 : 100

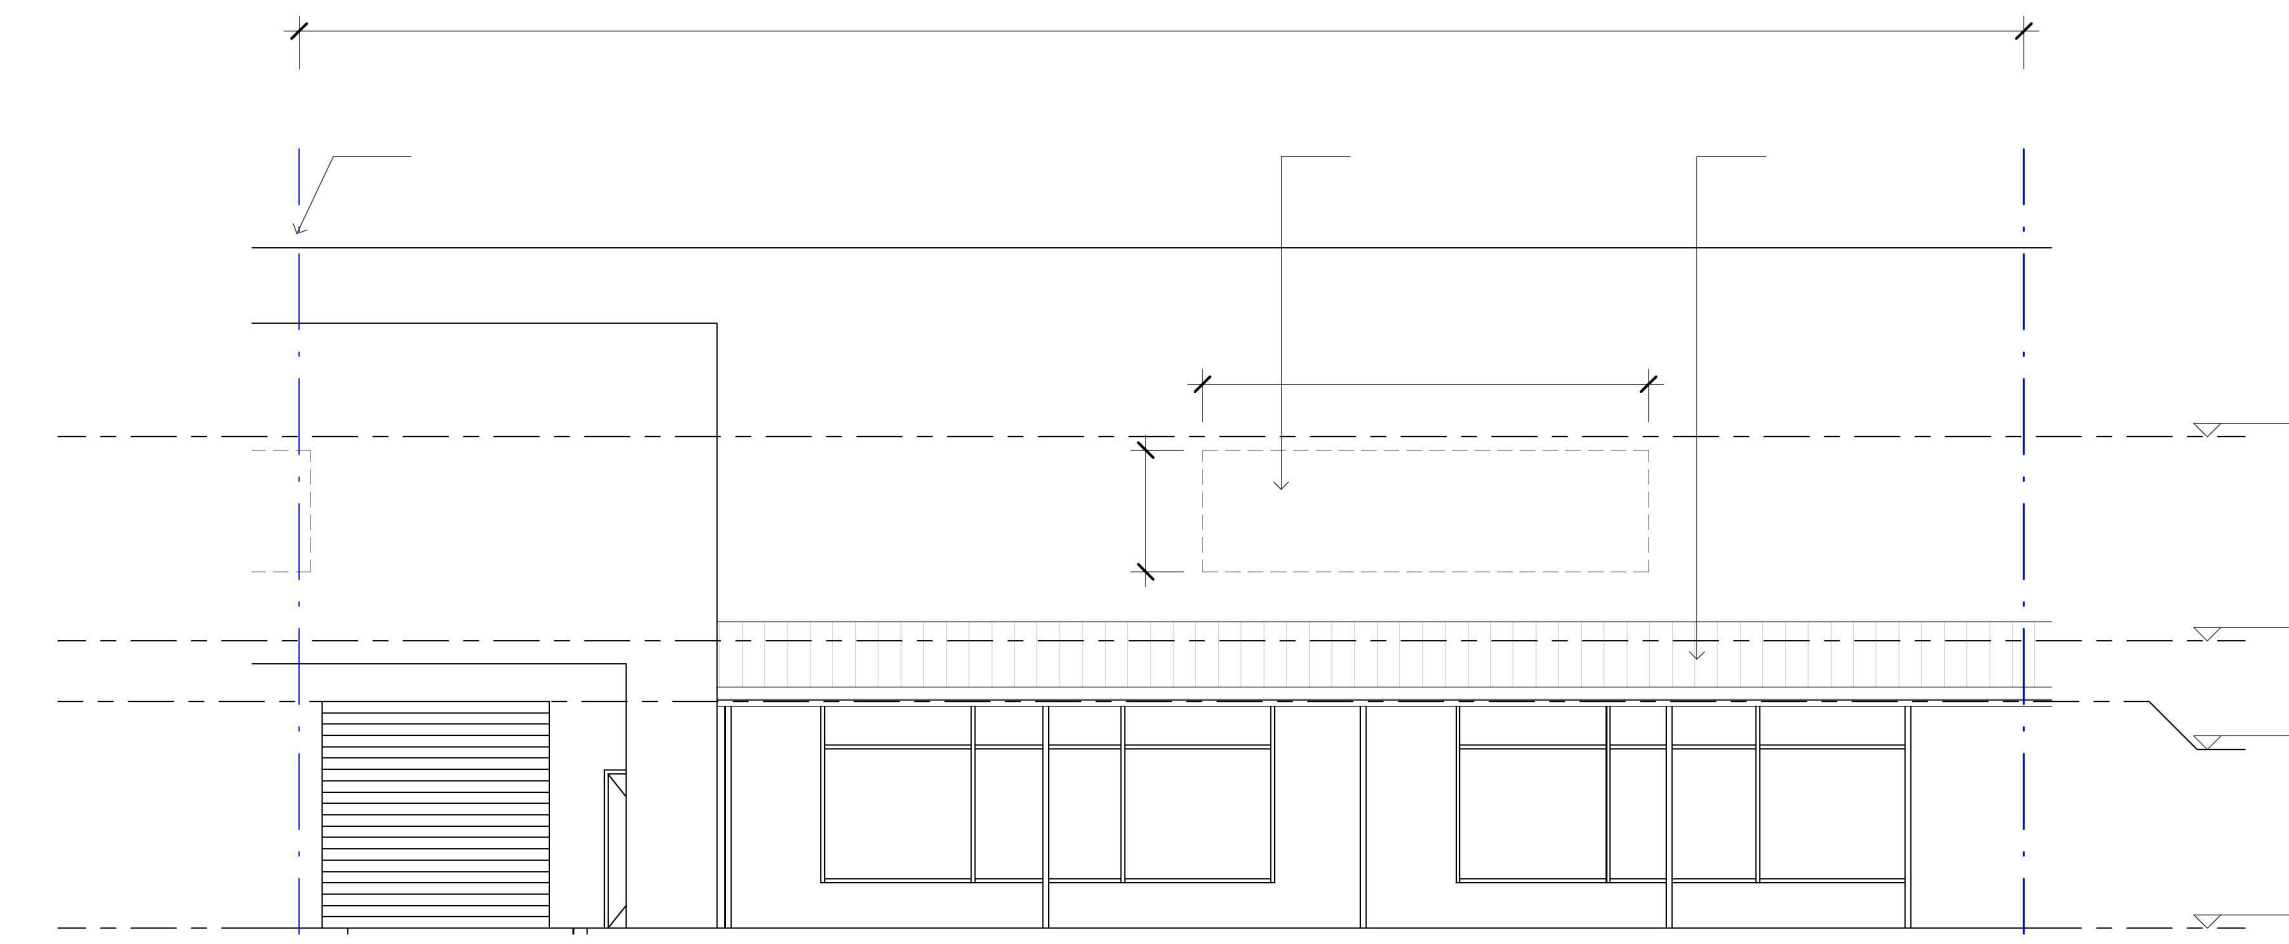

2 EXTERNAL ELEVATION
TP90 Scale: 1 : 100

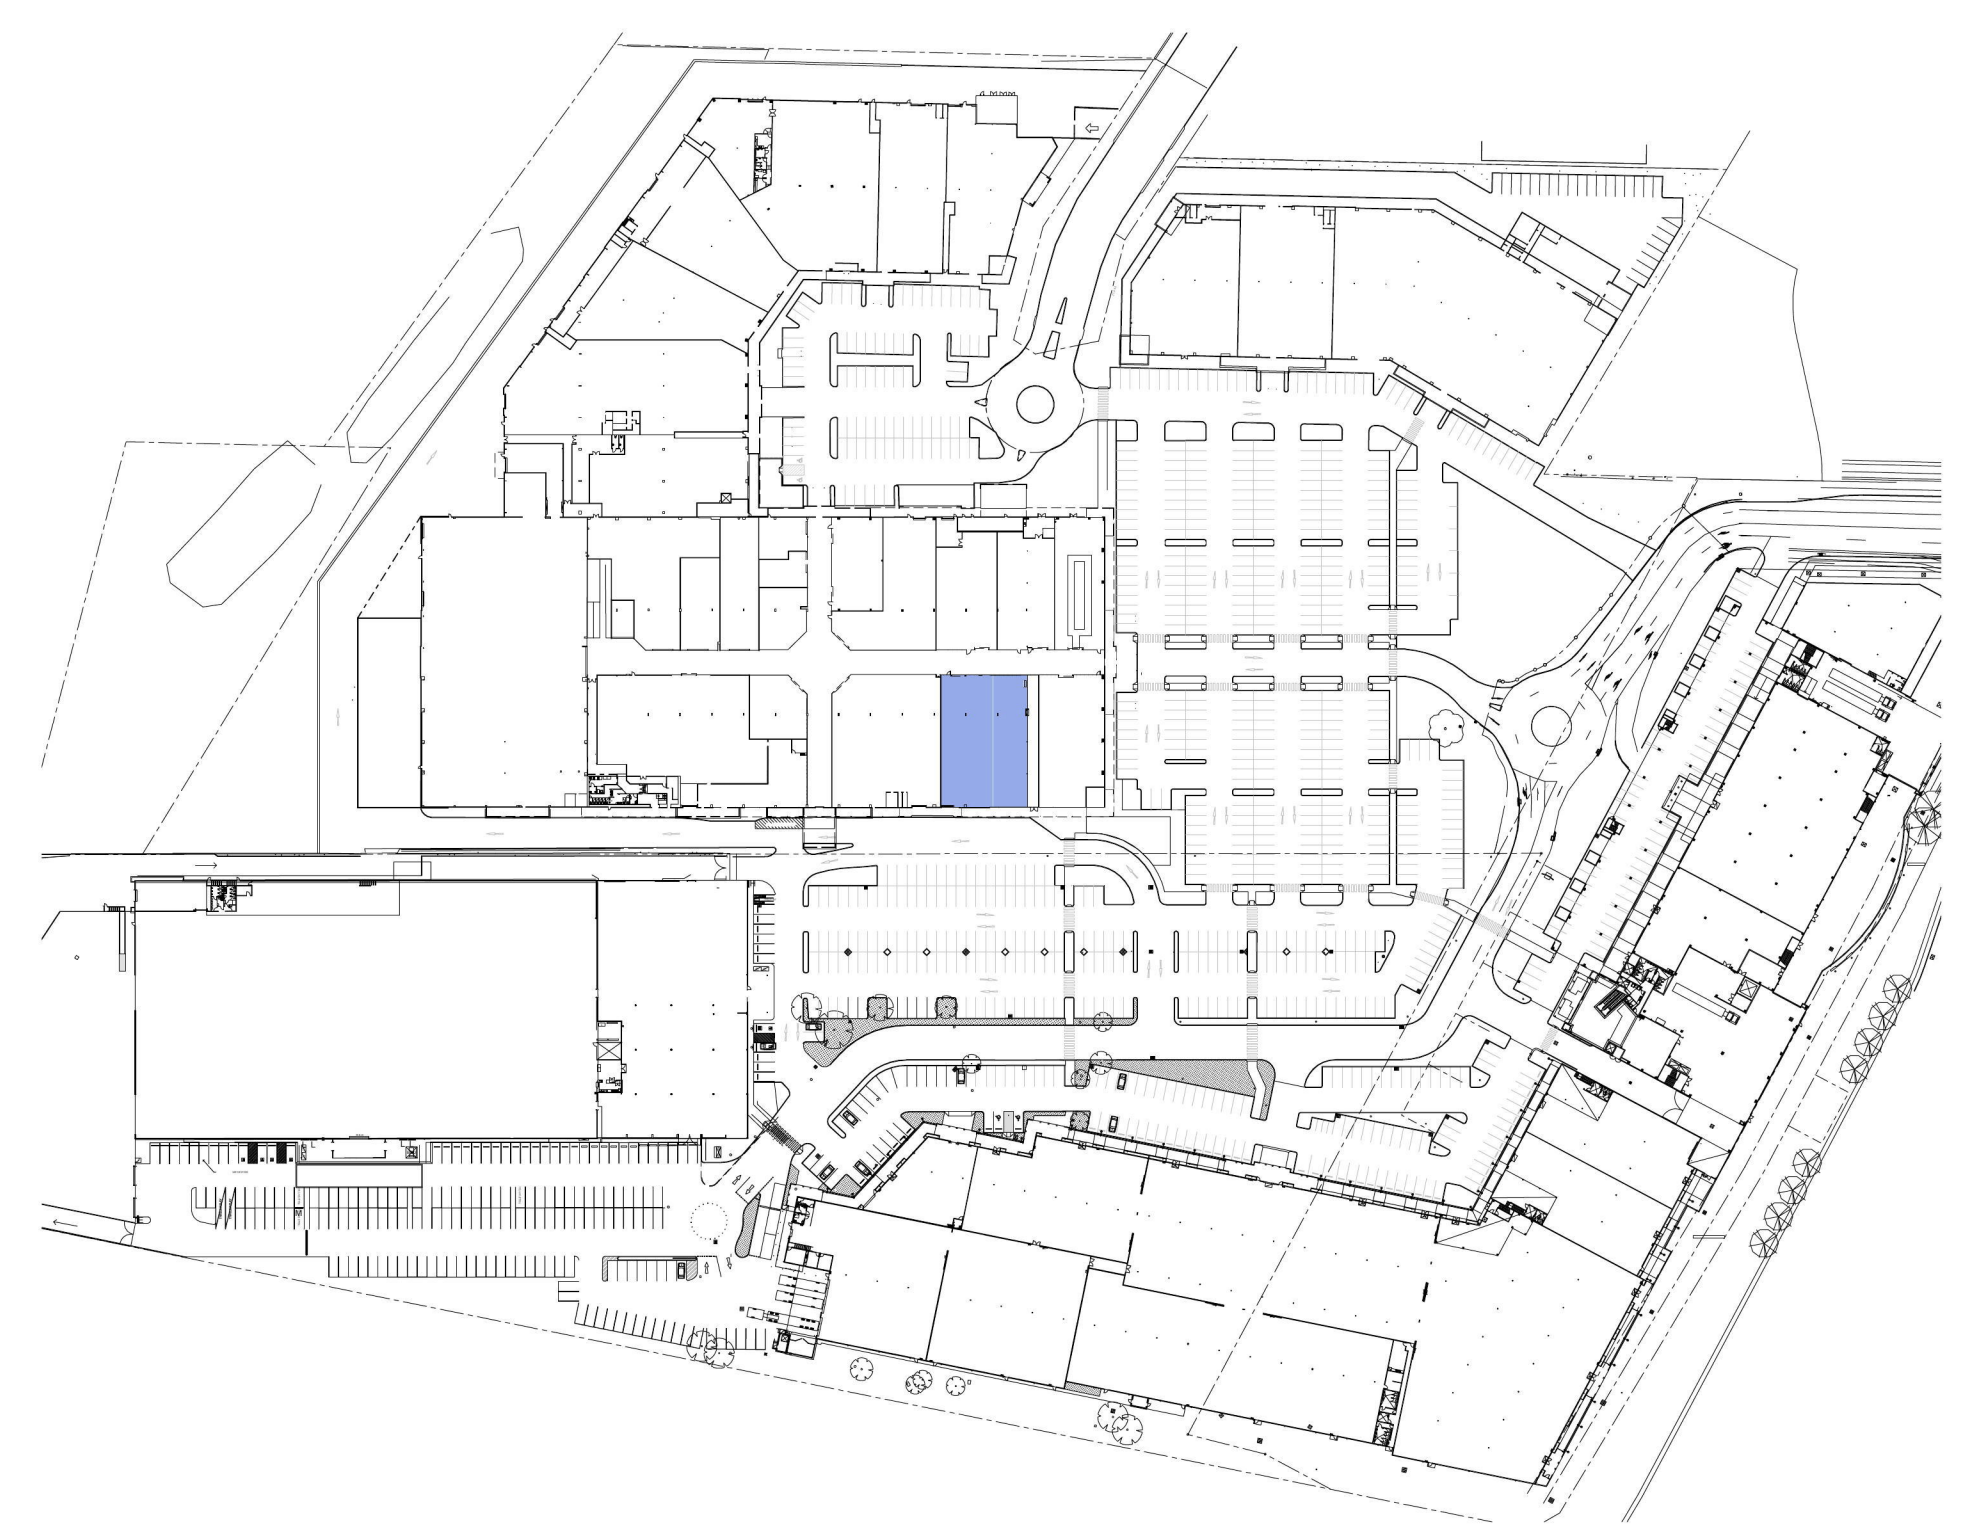


KEY PLAN

ELEVATIONS:

DO NOT SCALE DRAWINGS, FIGURED DIMENSIONS TAKE PRECEDENCE

BUILDER SHALL CHECK AND VERIFY ALL DIMENSIONS ON SITE AND REPORT ANY DISCREPANCIES TO THE BUILDING DESIGNER PRIOR TO THE COMMENCEMENT OF WORK


CONTRACTOR MUST VERIFY ALL DIMENSIONS ON SITE BEFORE COMMENCING ANY WORK OR PREPARING SHOP DRAWINGS WHICH MUST BE APPROVED BY THE BUILDING DESIGNER BEFORE MANUFACTURE. ANY EXTRA ENTAILED IN WORK SHOWN ON THIS DRAWING MUST BE CLAIMED AND APPROVED BEFORE PROCEEDING.

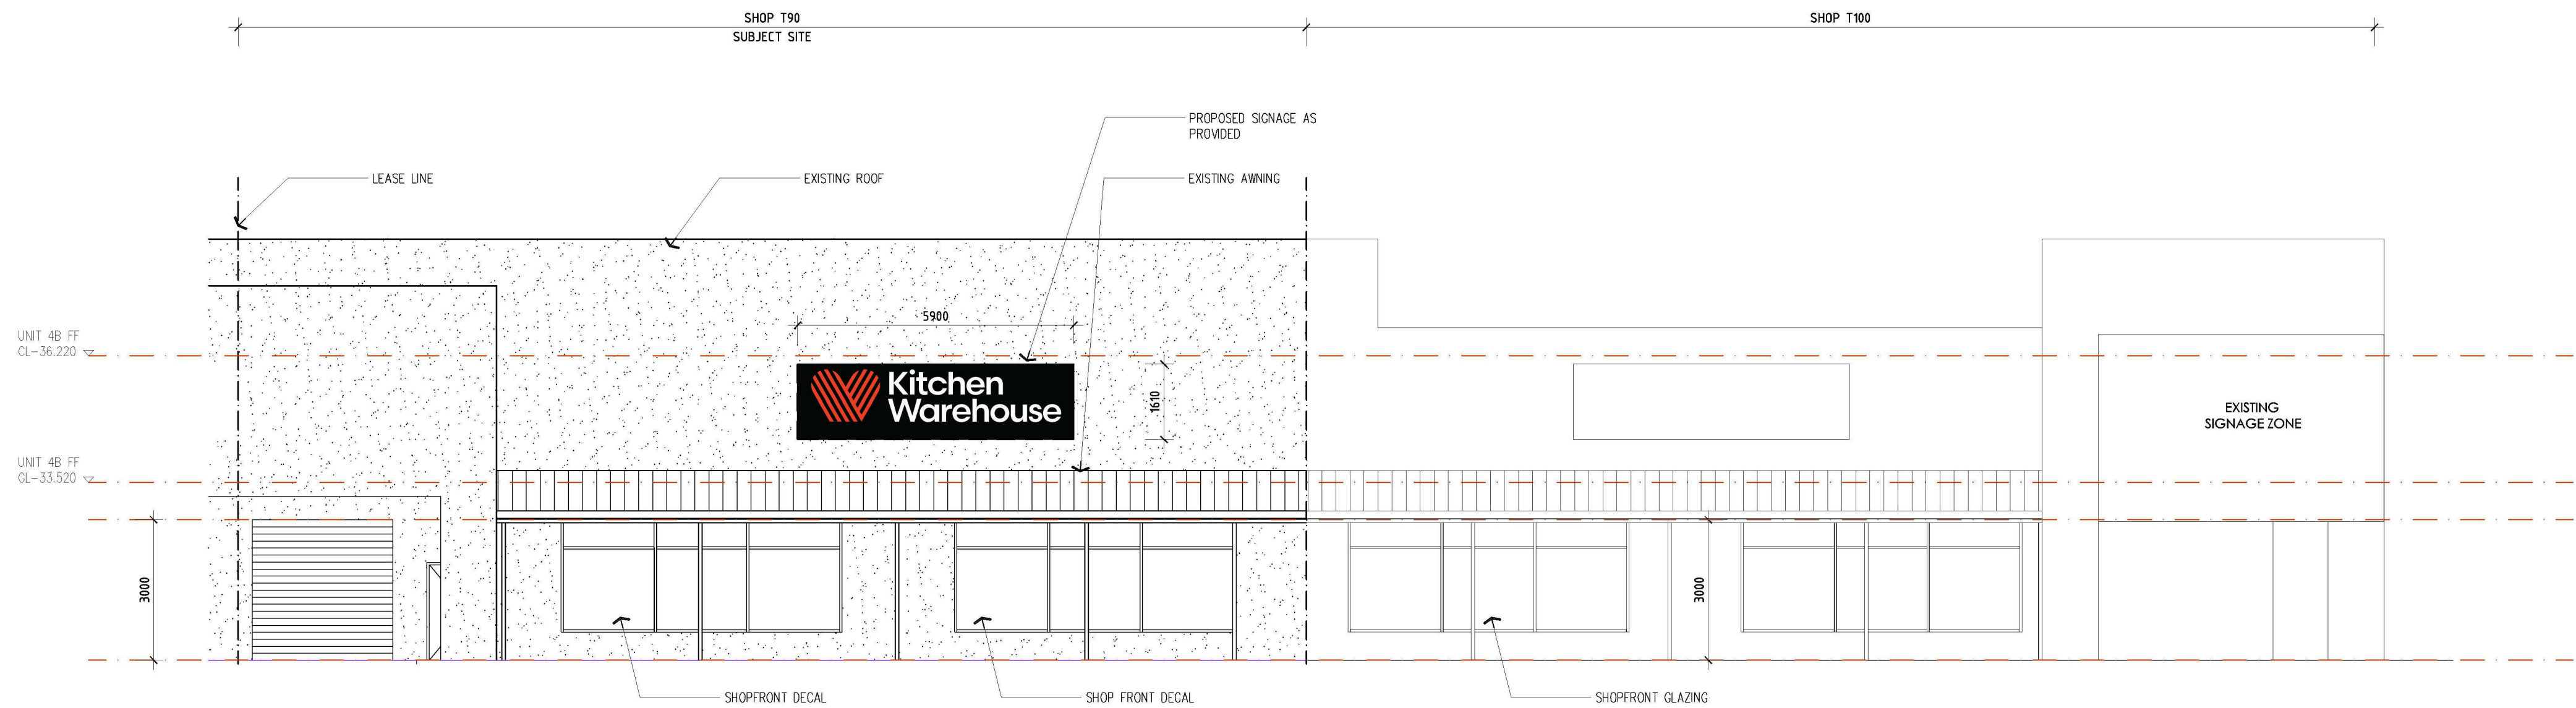


PROPOSED SOUTH ELEVATION



PROPOSED EXTERNAL SIGN DETAILS

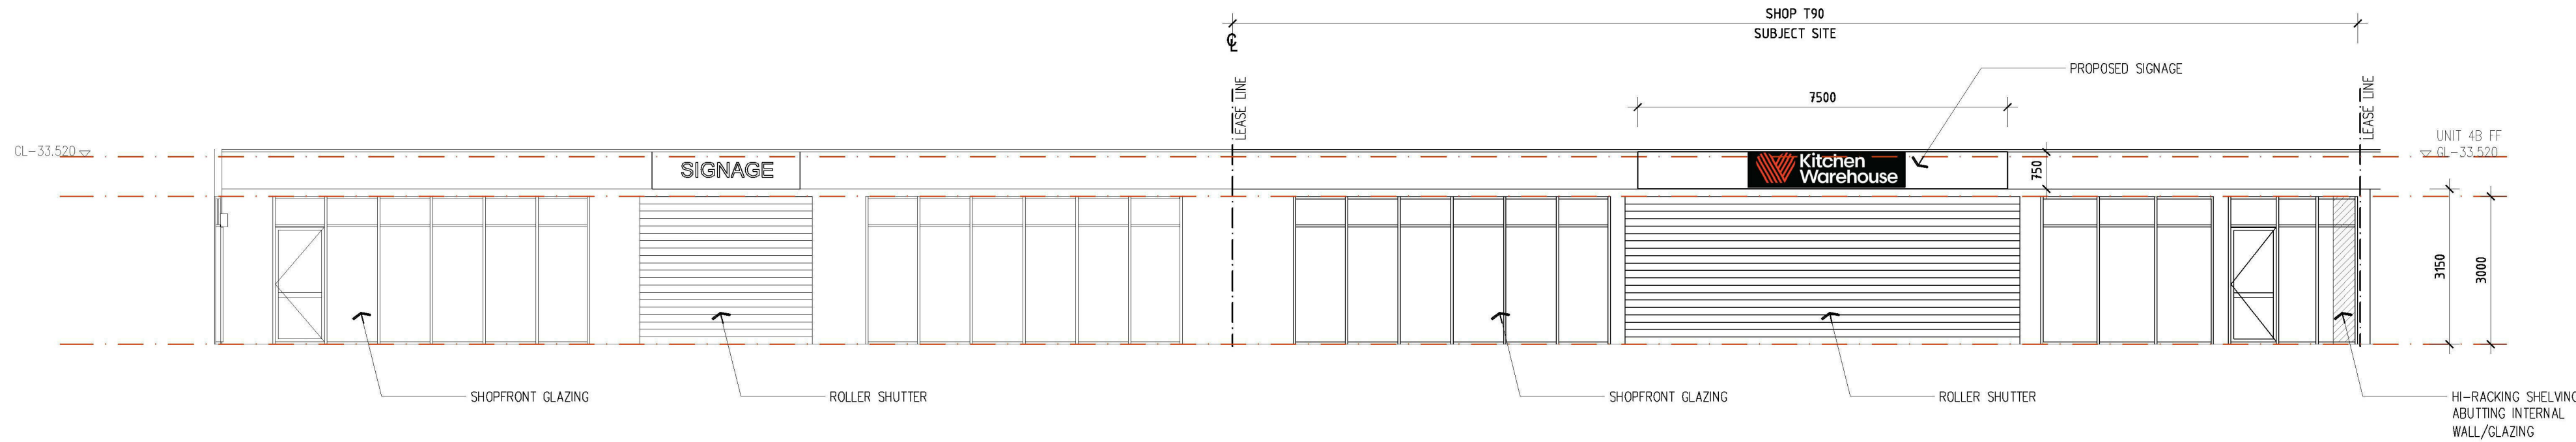

PROPOSED NORTHERN ELEVATION

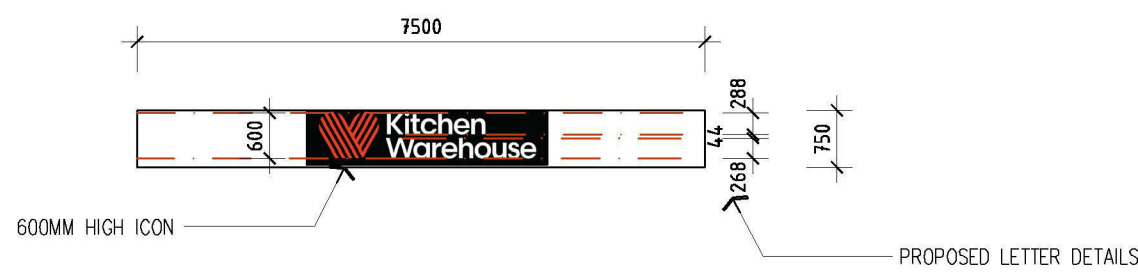


PROPOSED INTERNAL SIGN DETAILS

Rev:	Date:	Issue:

KITCHEN WAREHOUSE

Drawing Title:	ELEVATIONS
Date: 12th March 2019	Council: PENRITH
Scale: 1:100 @ A1	Job No: 001


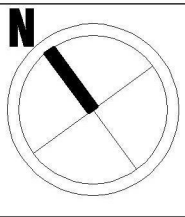


metro building designers	m: 0411 840 192
Glenn Nielsen	e: mail@metrobd.com.au
	w: www.metrobd.com.au

Project Address:	SHOP T90
	HARVEY NORMAN CENTRE
	MULGOA, PENRITH 2750

Drawing: A04

KITCHEN WAREHOUSE
HARVEY NORMAN CENTRE
SHOP T90

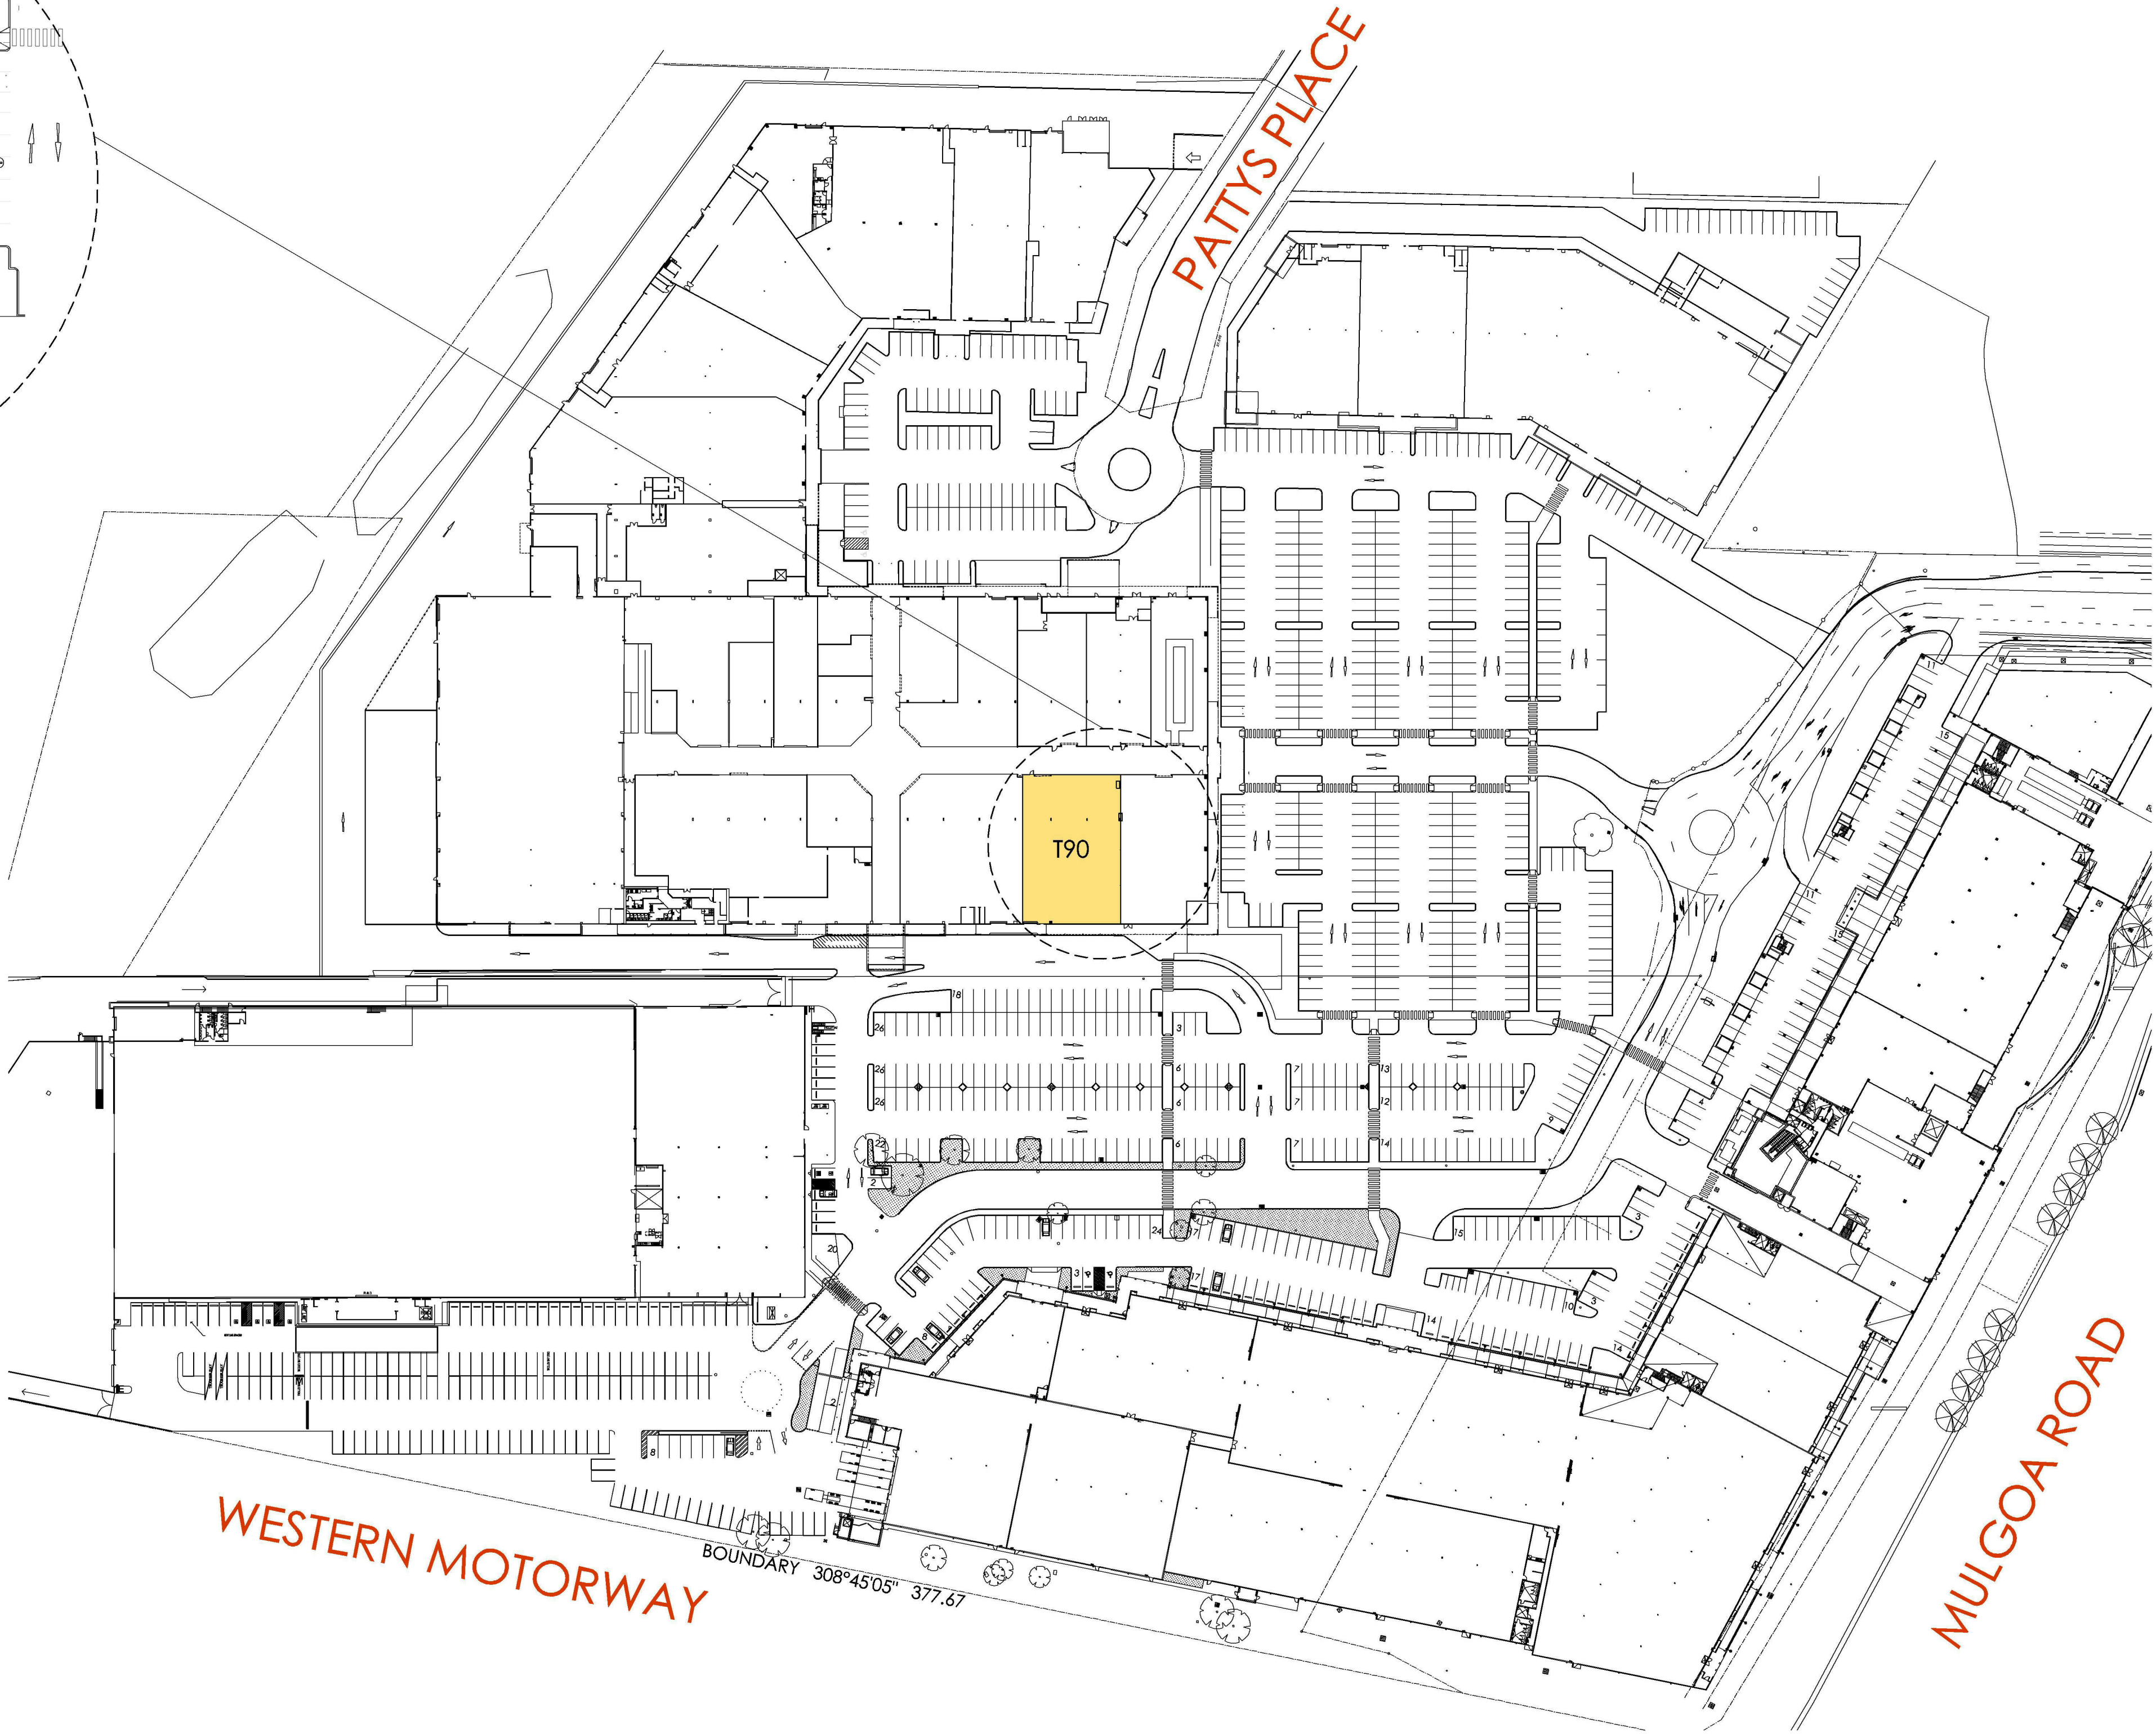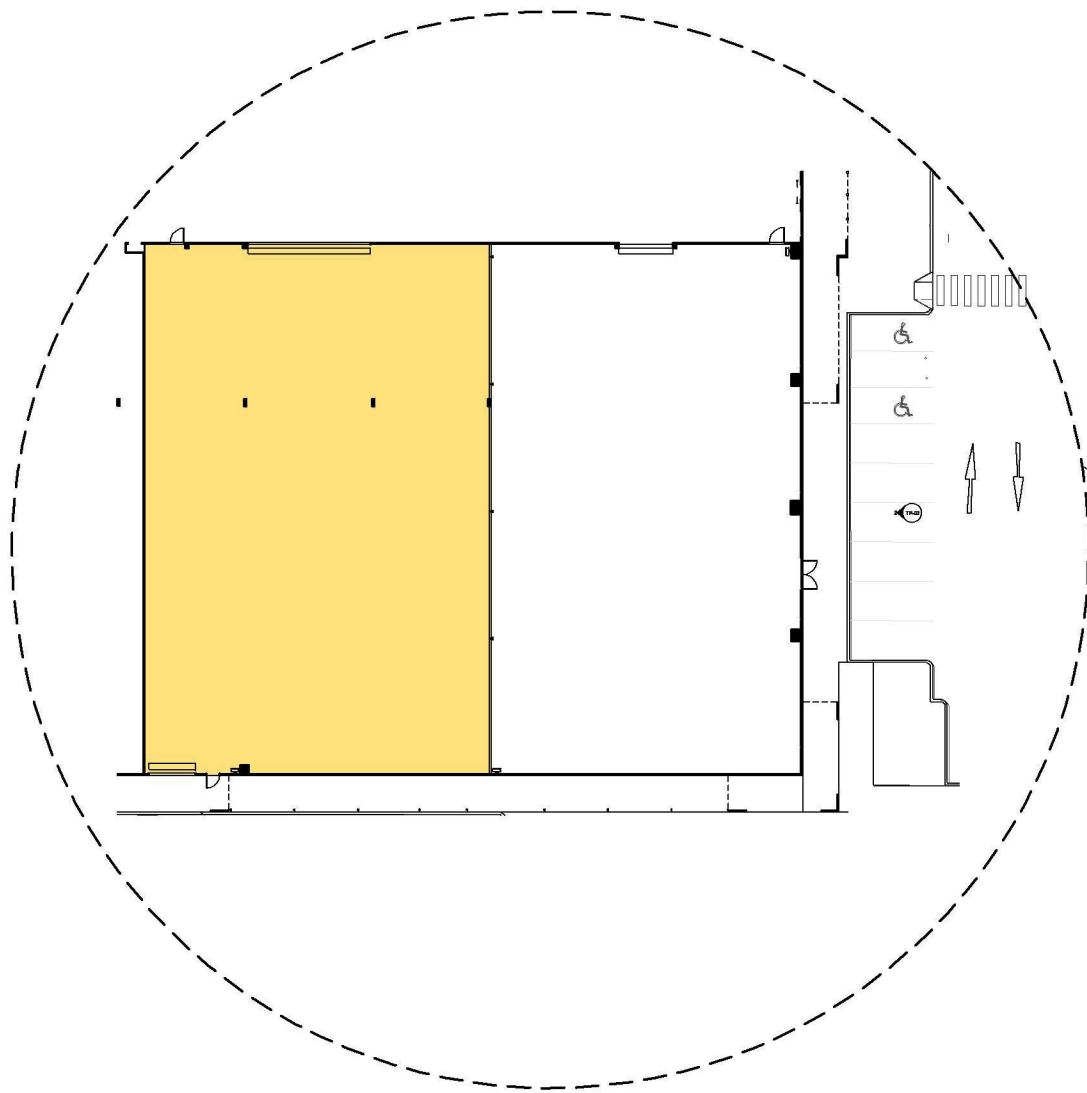

SUBJECT SITE


WESTERN MOTORWAY

PATTYS PLACE

MULGOA ROAD

Drawing Title: SITE PLAN

Date: 12th March 2019 Council: PENRITH
Scale: NTS @ A1 Job No: 001

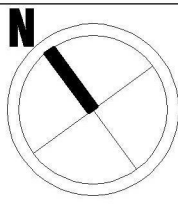

metro building designers
Glenn Nielsen m: 0411 840 192
e: mail@metrobd.com.au
w: www.metrobd.com.au

Project Address:
SHOP T90
HARVEY NORMAN CENTRE
MULGOA, PENRITH 2750

Drawing: A00

KITCHEN WAREHOUSE

Rev:	Date:	Issue:

Penrith Homemaker Centre site plan

August 2018

GLA 65,097.9m²
Retailers 40
Parking Bays 1,490

