



<p>CONFIDENTIAL (NOT TO BE DISCLOSED TO ANY OTHER PERSON WITHOUT PERMISSION FROM ROCIA LIMITED. UNAUTHORISED DISCLOSURE MAY RESULT IN PROSECUTIONS)</p> <p>Rocia Pty Limited This drawing is the property of Rocia Limited. It is submitted for use only in connection with proposals and contracts of Rocia Pty Limited upon the express condition that it is not to be reproduced or copied in any form. Calls to be used only with reference to products manufactured and supplied by Rocia Pty Limited.</p>		<p>UNLESS OTHERWISE SPECIFIED: DIMENSIONS FOR: ELECTRICAL DIMENSIONS IN MILLIMETRES ALL DIMENSIONS ARE IN METRES</p>	<p>APPROVED GW DATE: 25/10/16</p>
			<p>DESIGNED BY ST DATE: 25/10/16</p>
<p>EMU PLAINS PLANT LAYOUT</p> <p>EMU PLAINS</p>			<p>APPROVED GG DATE: 25/10/16</p> <p>PROJECT: - DATE: NTS</p>
<p>B 62186 B</p>			

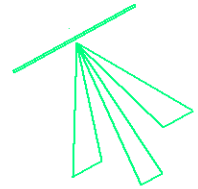

No 1
DP 588919

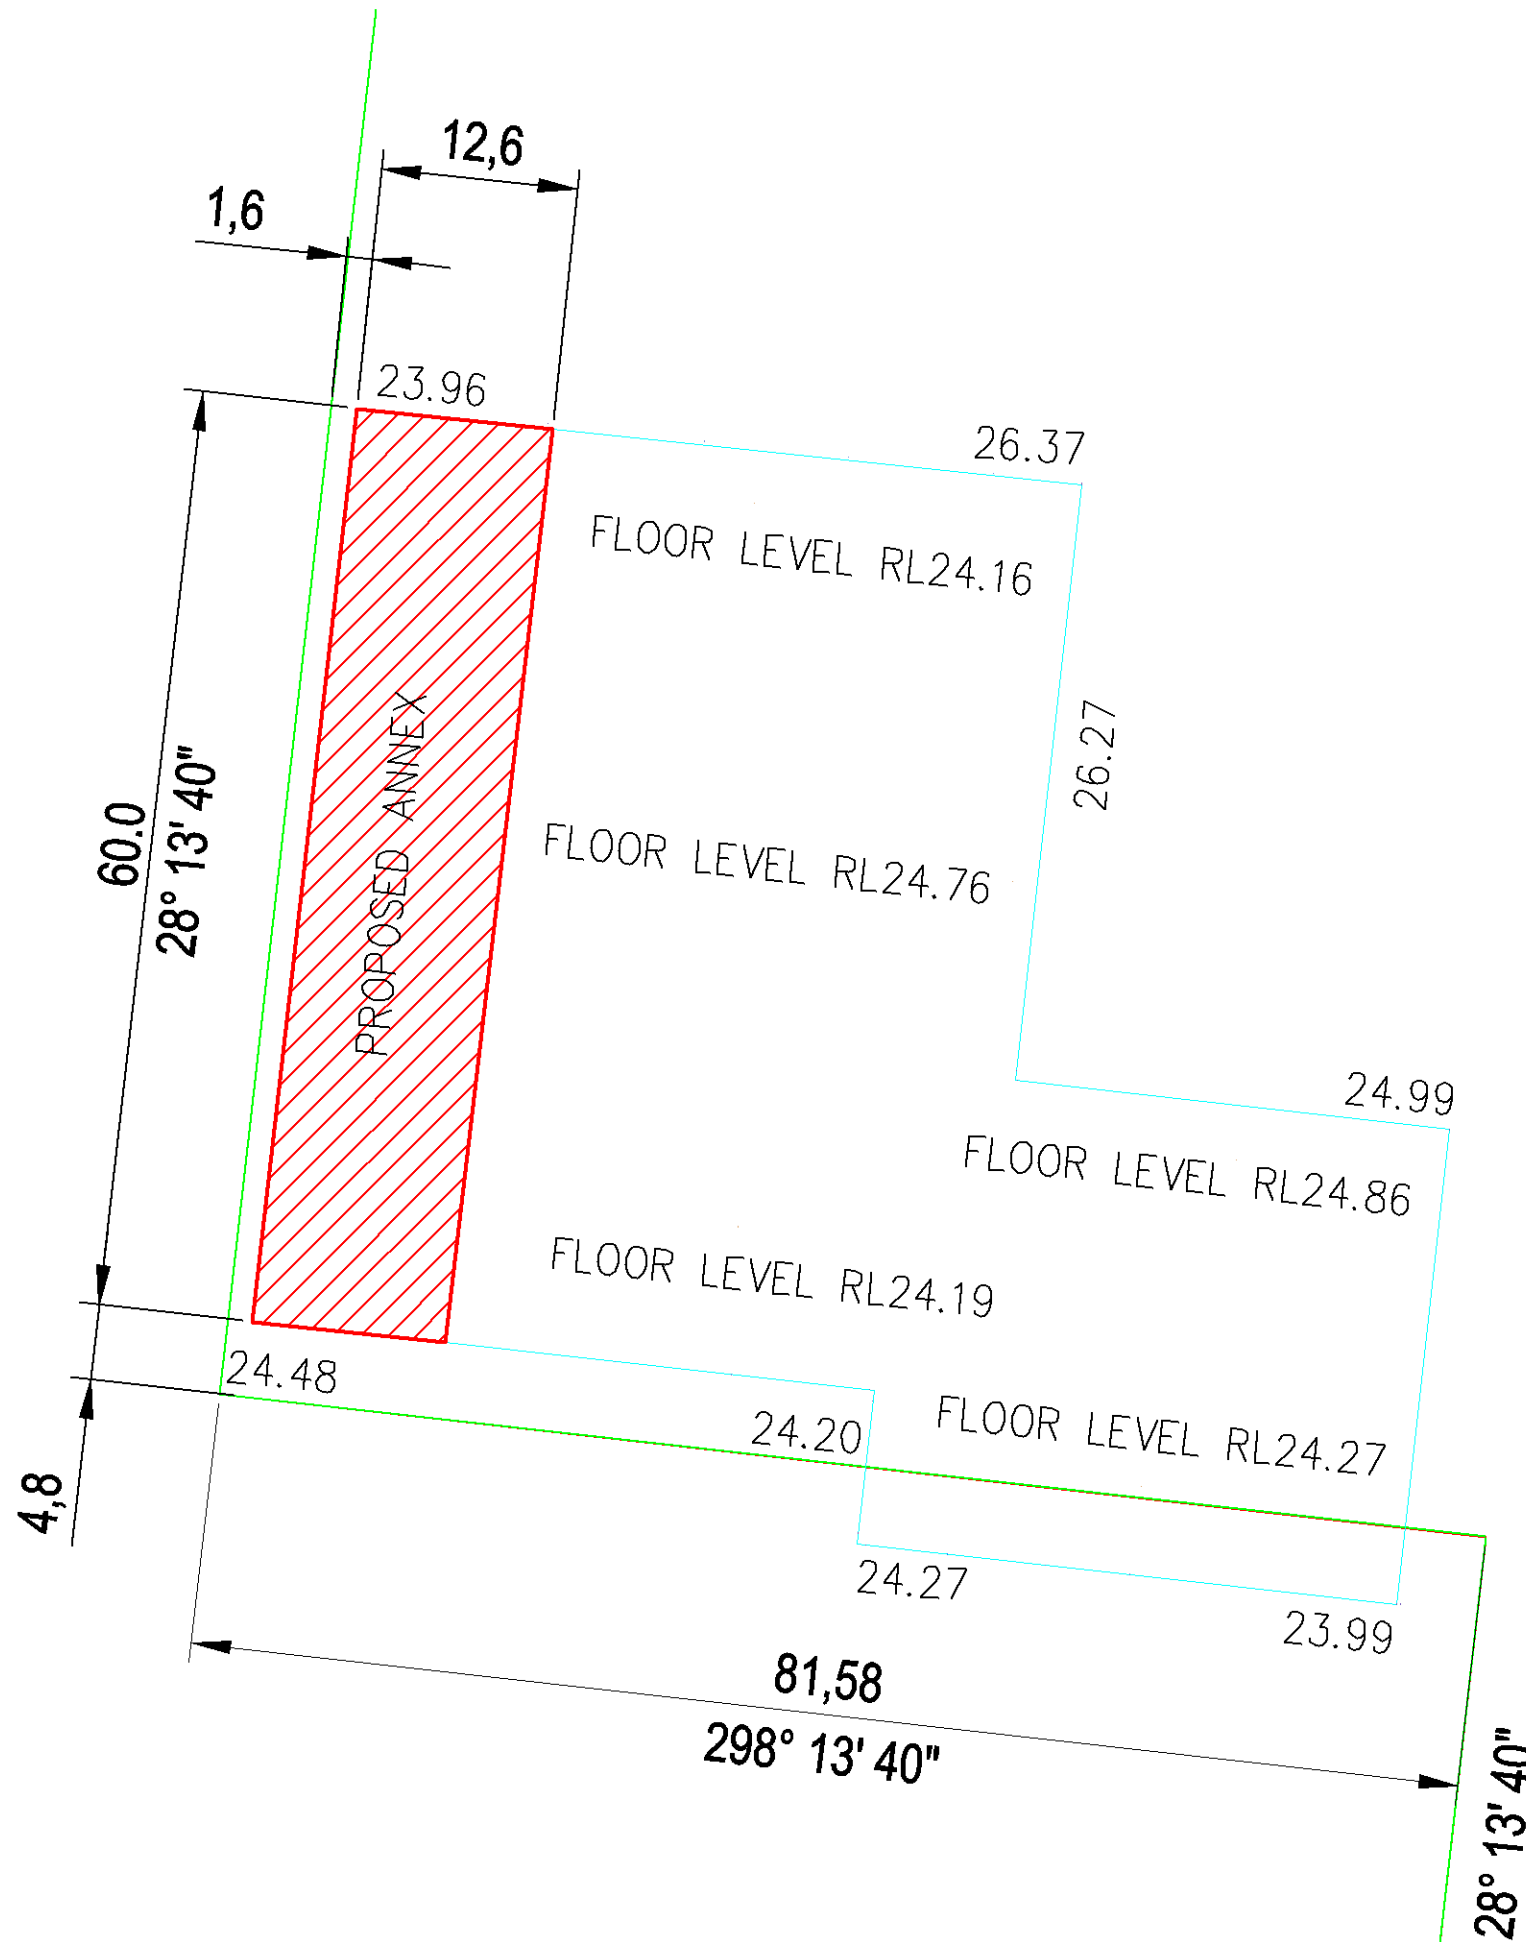

No 2
DP 588919



CONFIDENTIAL
 (NOT TO BE DISCLOSED TO ANY OTHER PERSON WITHOUT PERMISSION FROM ROCIA LIMITED. UNAUTHORISED DISCLOSURE MAY RESULT IN PROSECUTION)
 © Rocia Pty Limited
 This drawing is the property of Rocia Limited. It is submitted for use only in accordance with proposals and contracts of Rocia Pty Limited upon the express condition that it is not to be reproduced or copied in any form. Data to be used only with reference to proposals, manufactured and supplied by Rocia Pty Limited.



UNLESS OTHERWISE SPECIFIED:
 ALL DIMENSIONS ARE IN METRES
 UNLESS OTHERWISE SPECIFIED:
 DIMENSIONS FOR
 STRUCTURAL DIMENSIONS AS
 SHOWN DIMENSIONS AS
 APPLICABLE OTHERWISE AS NOTED

**EMU PLAINS
 PLANT LAYOUT
 EMU PLAINS**

APPROVED	GW	DATE	28/10/16
CHECKED	ST	DATE	28/10/16
DRAWN	GG	DATE	28/10/16
REV	62188	DATE	1:1000
B	62187	A	

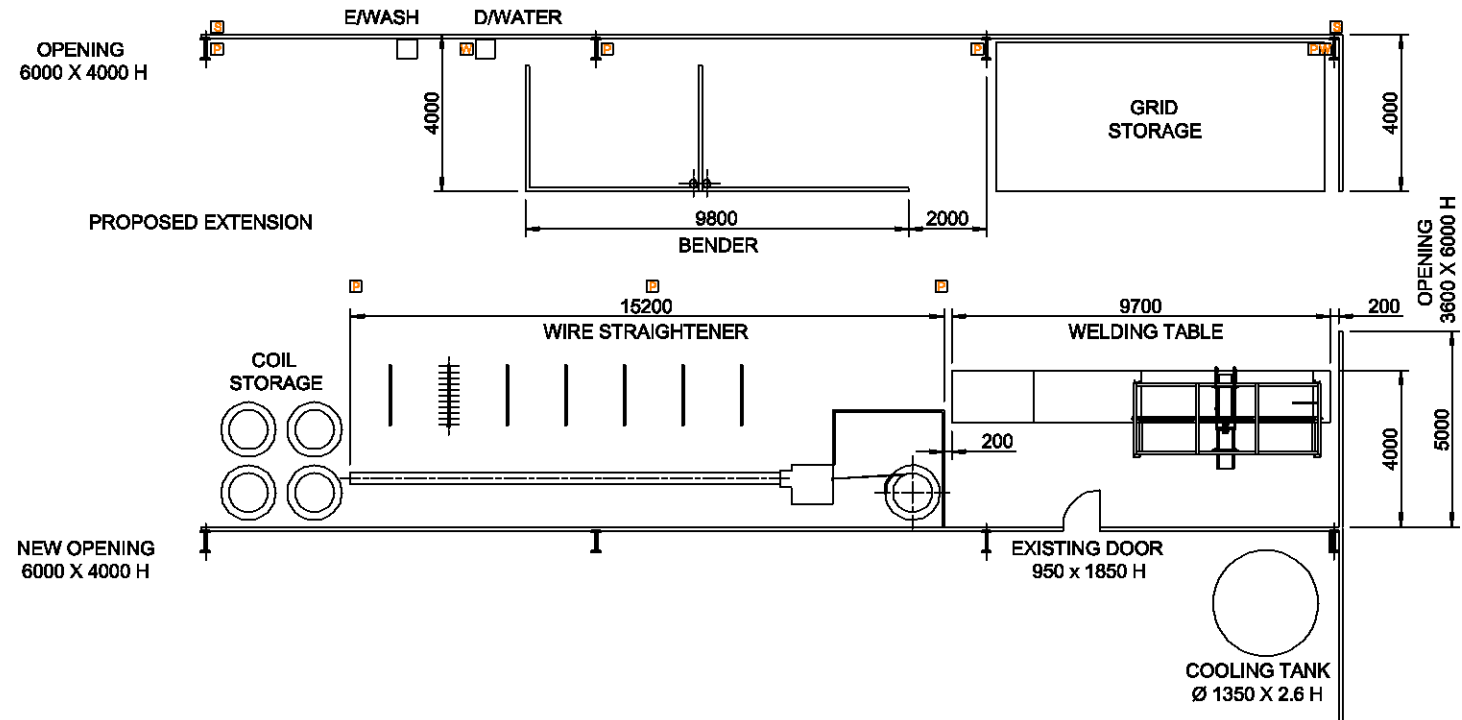
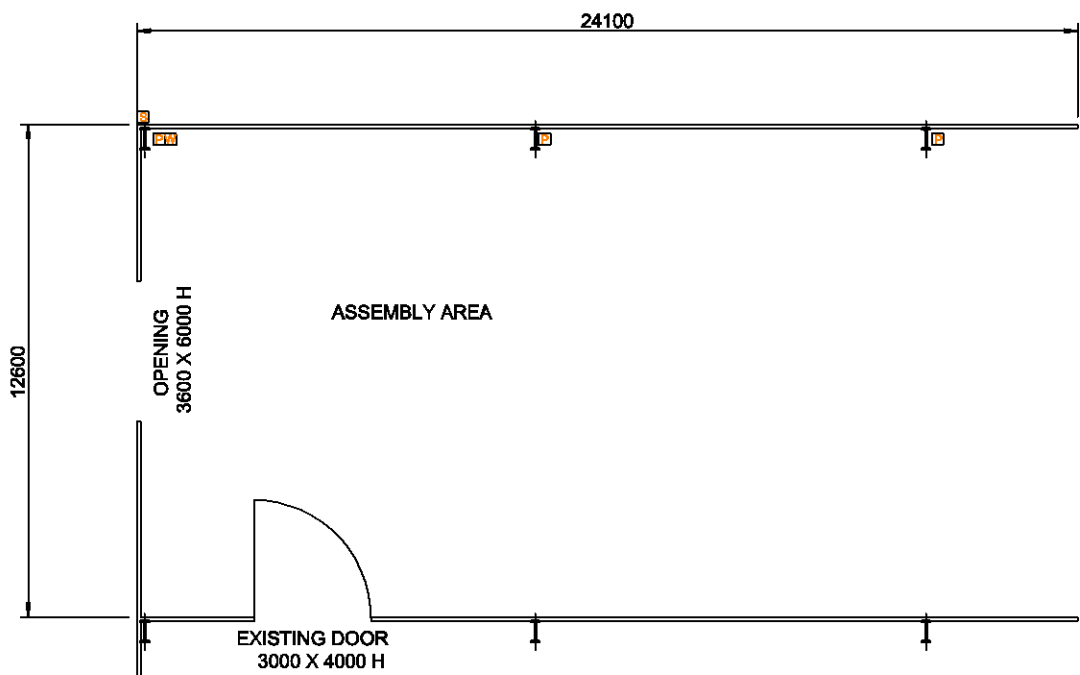


- SPRINKLER
- WATER
- POWER


FIRE HOSE 90 MTR

<p>CONFIDENTIAL (NOT TO BE DISCLOSED TO ANY OTHER PERSON WITHOUT PERMISSION FROM ROCIA LIMITED. UNAUTHORISED DISCLOSURE MAY RESULT IN PROSECUTIONS)</p> <p>© Rocia Pty Limited This drawing is the property of Rocia Limited. ALL RIGHTS RESERVED. It is authorized for use only in connection with proposals and contracts of Rocia Pty Limited upon the express condition that it is not to be reproduced or copied in any form. Data to be used only with reference to projects manufactured and supplied by Rocia Pty Limited.</p>		<p>UNLESS OTHERWISE SPECIFIED: ALL DIMENSIONS ARE IN MILLIMETRES TOLERANCES FOR: STRUCTURAL DIMENSIONS AS INDICATED OTHERWISE AS SHOWN</p>	<p>APPROV. GW DATE 04/11/16</p>
			<p>CHECK. GB DATE 04/11/16</p>
			<p>DRAWN. GG DATE 04/11/16</p>
			<p>REP. 62188 SCALE NTS</p>
<p>EMU PLAINS EQUIPMENT LAYOUT</p>			<p>B 62193 A</p>


No1
DP 588919

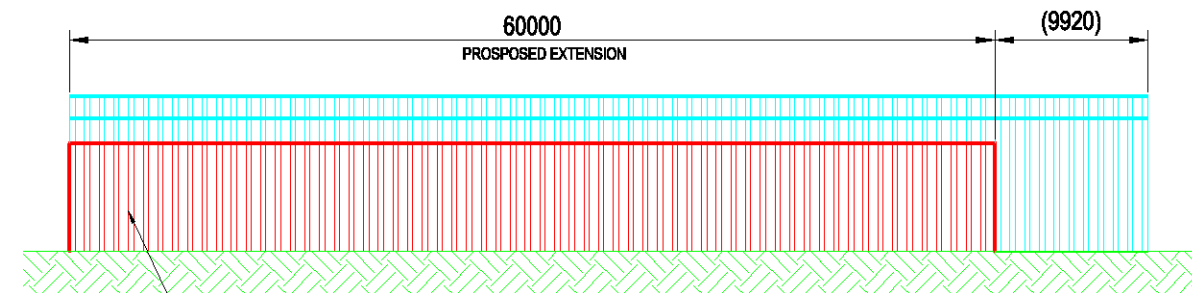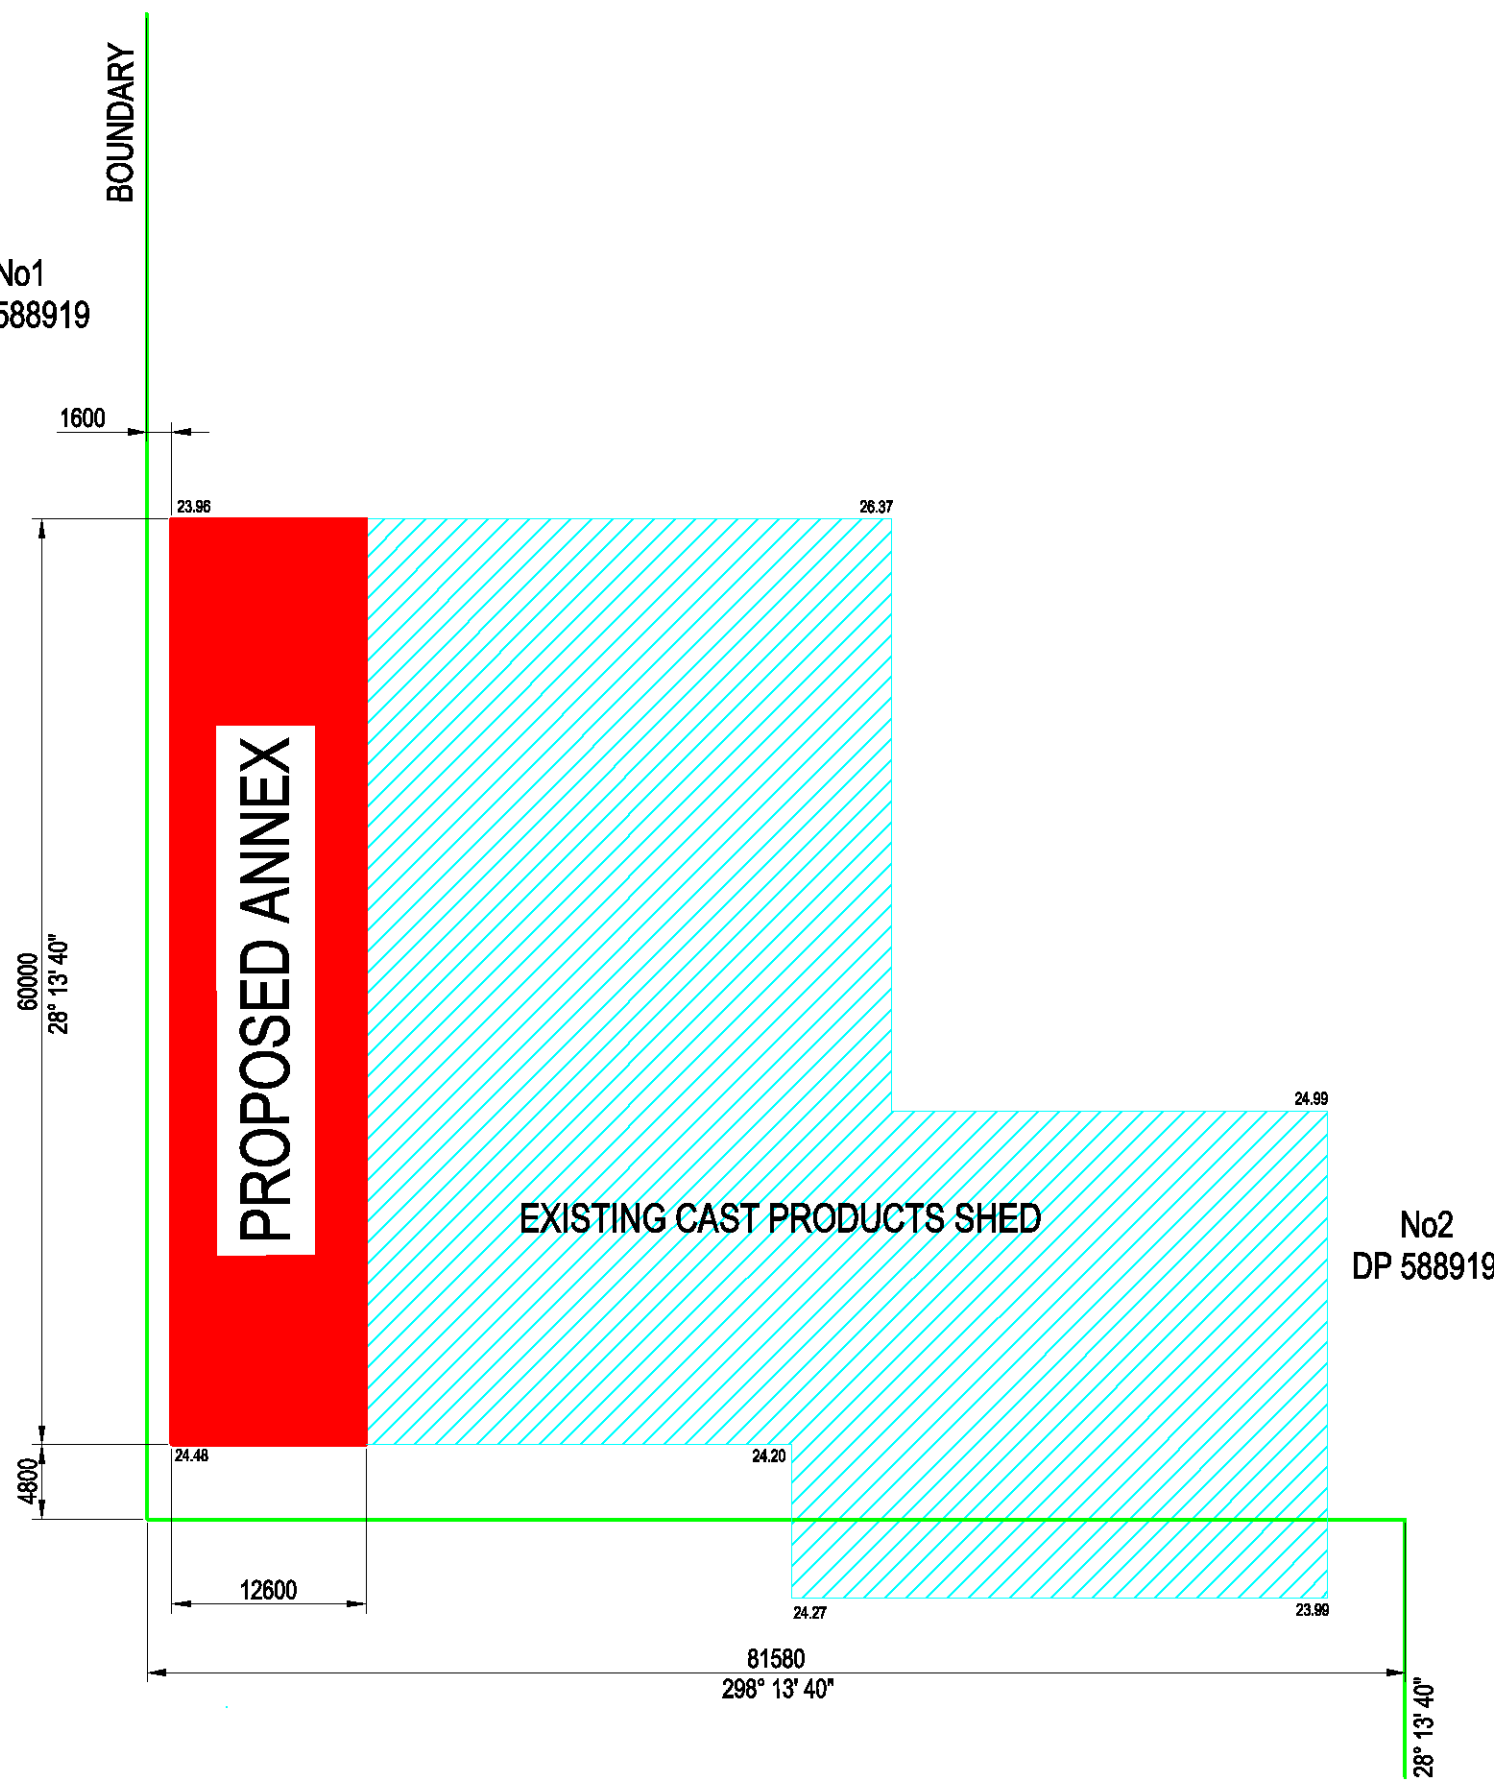


NORTH ELEVATION

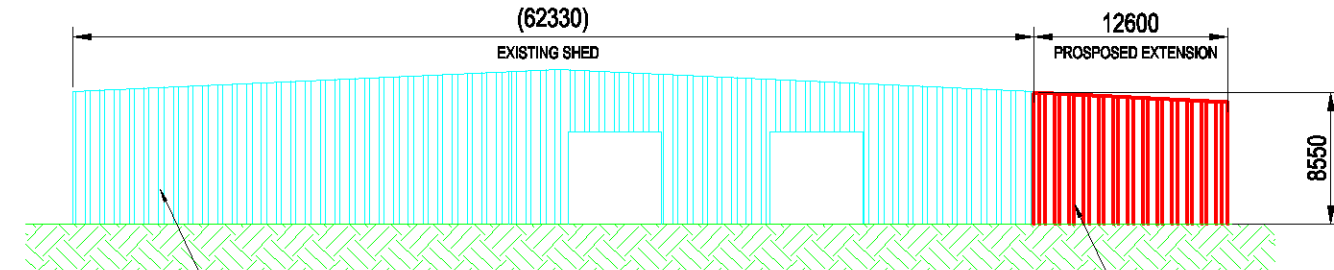

EAST ELEVATION

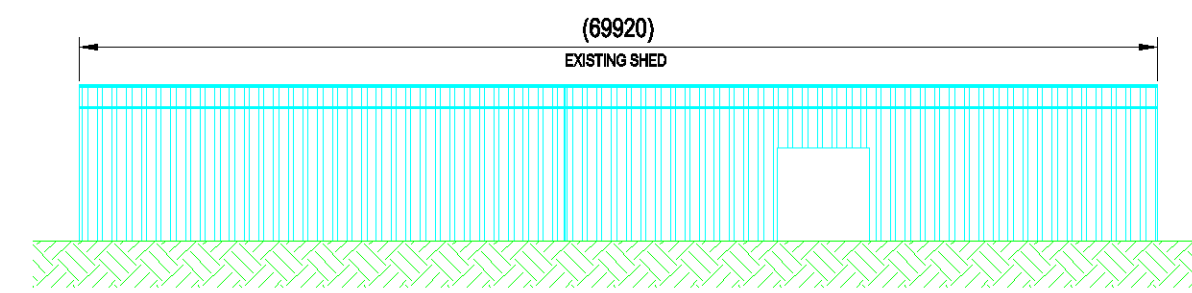


SOUTH ELEVATION

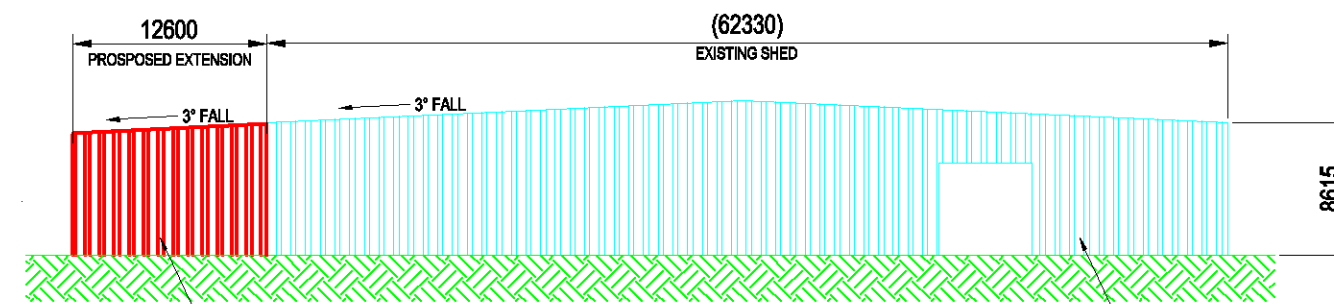

WEST ELEVATION



<p>CONFIDENTIAL (NOT TO BE DISCLOSED TO ANY OTHER PERSON WITHOUT PERMISSION FROM ROCKA LIMITED. UNAUTHORIZED DISCLOSURE MAY RESULT IN PROSECUTION)</p> <p>© Rocka Pty Limited This drawing is the property of Rocka Limited. A.B.N. 51 000 020 191 and is subject to return upon demand. It is intended for use only in connection with proposals and contracts of Rocka Pty Limited upon the express condition that it is not to be reproduced or copied in any form. Data to be used only with reference to products manufactured and supplied by Rocka Pty Limited.</p>		<p>UNLESS OTHERWISE SPECIFIED: ALL DIMENSIONS ARE IN MILLIMETRES TOLERANCES FOR: DIMENSIONS OF WORKS TO BE MANUFACTURED SHALL BE AS SHOWN UNLESS OTHERWISE SPECIFIED.</p>	<p>APPROVAL: GW DATE: 26/10/16</p>
			<p>APPROVAL: ST DATE: 29/10/16</p>
			<p>APPROVAL: GG DATE: 28/10/16</p>
			<p>NO: 62189 DATE: NTS</p>
<p>EMU PLAINS PLANT LAYOUT EMU PLAINS</p>			<p>B 62189 A</p>

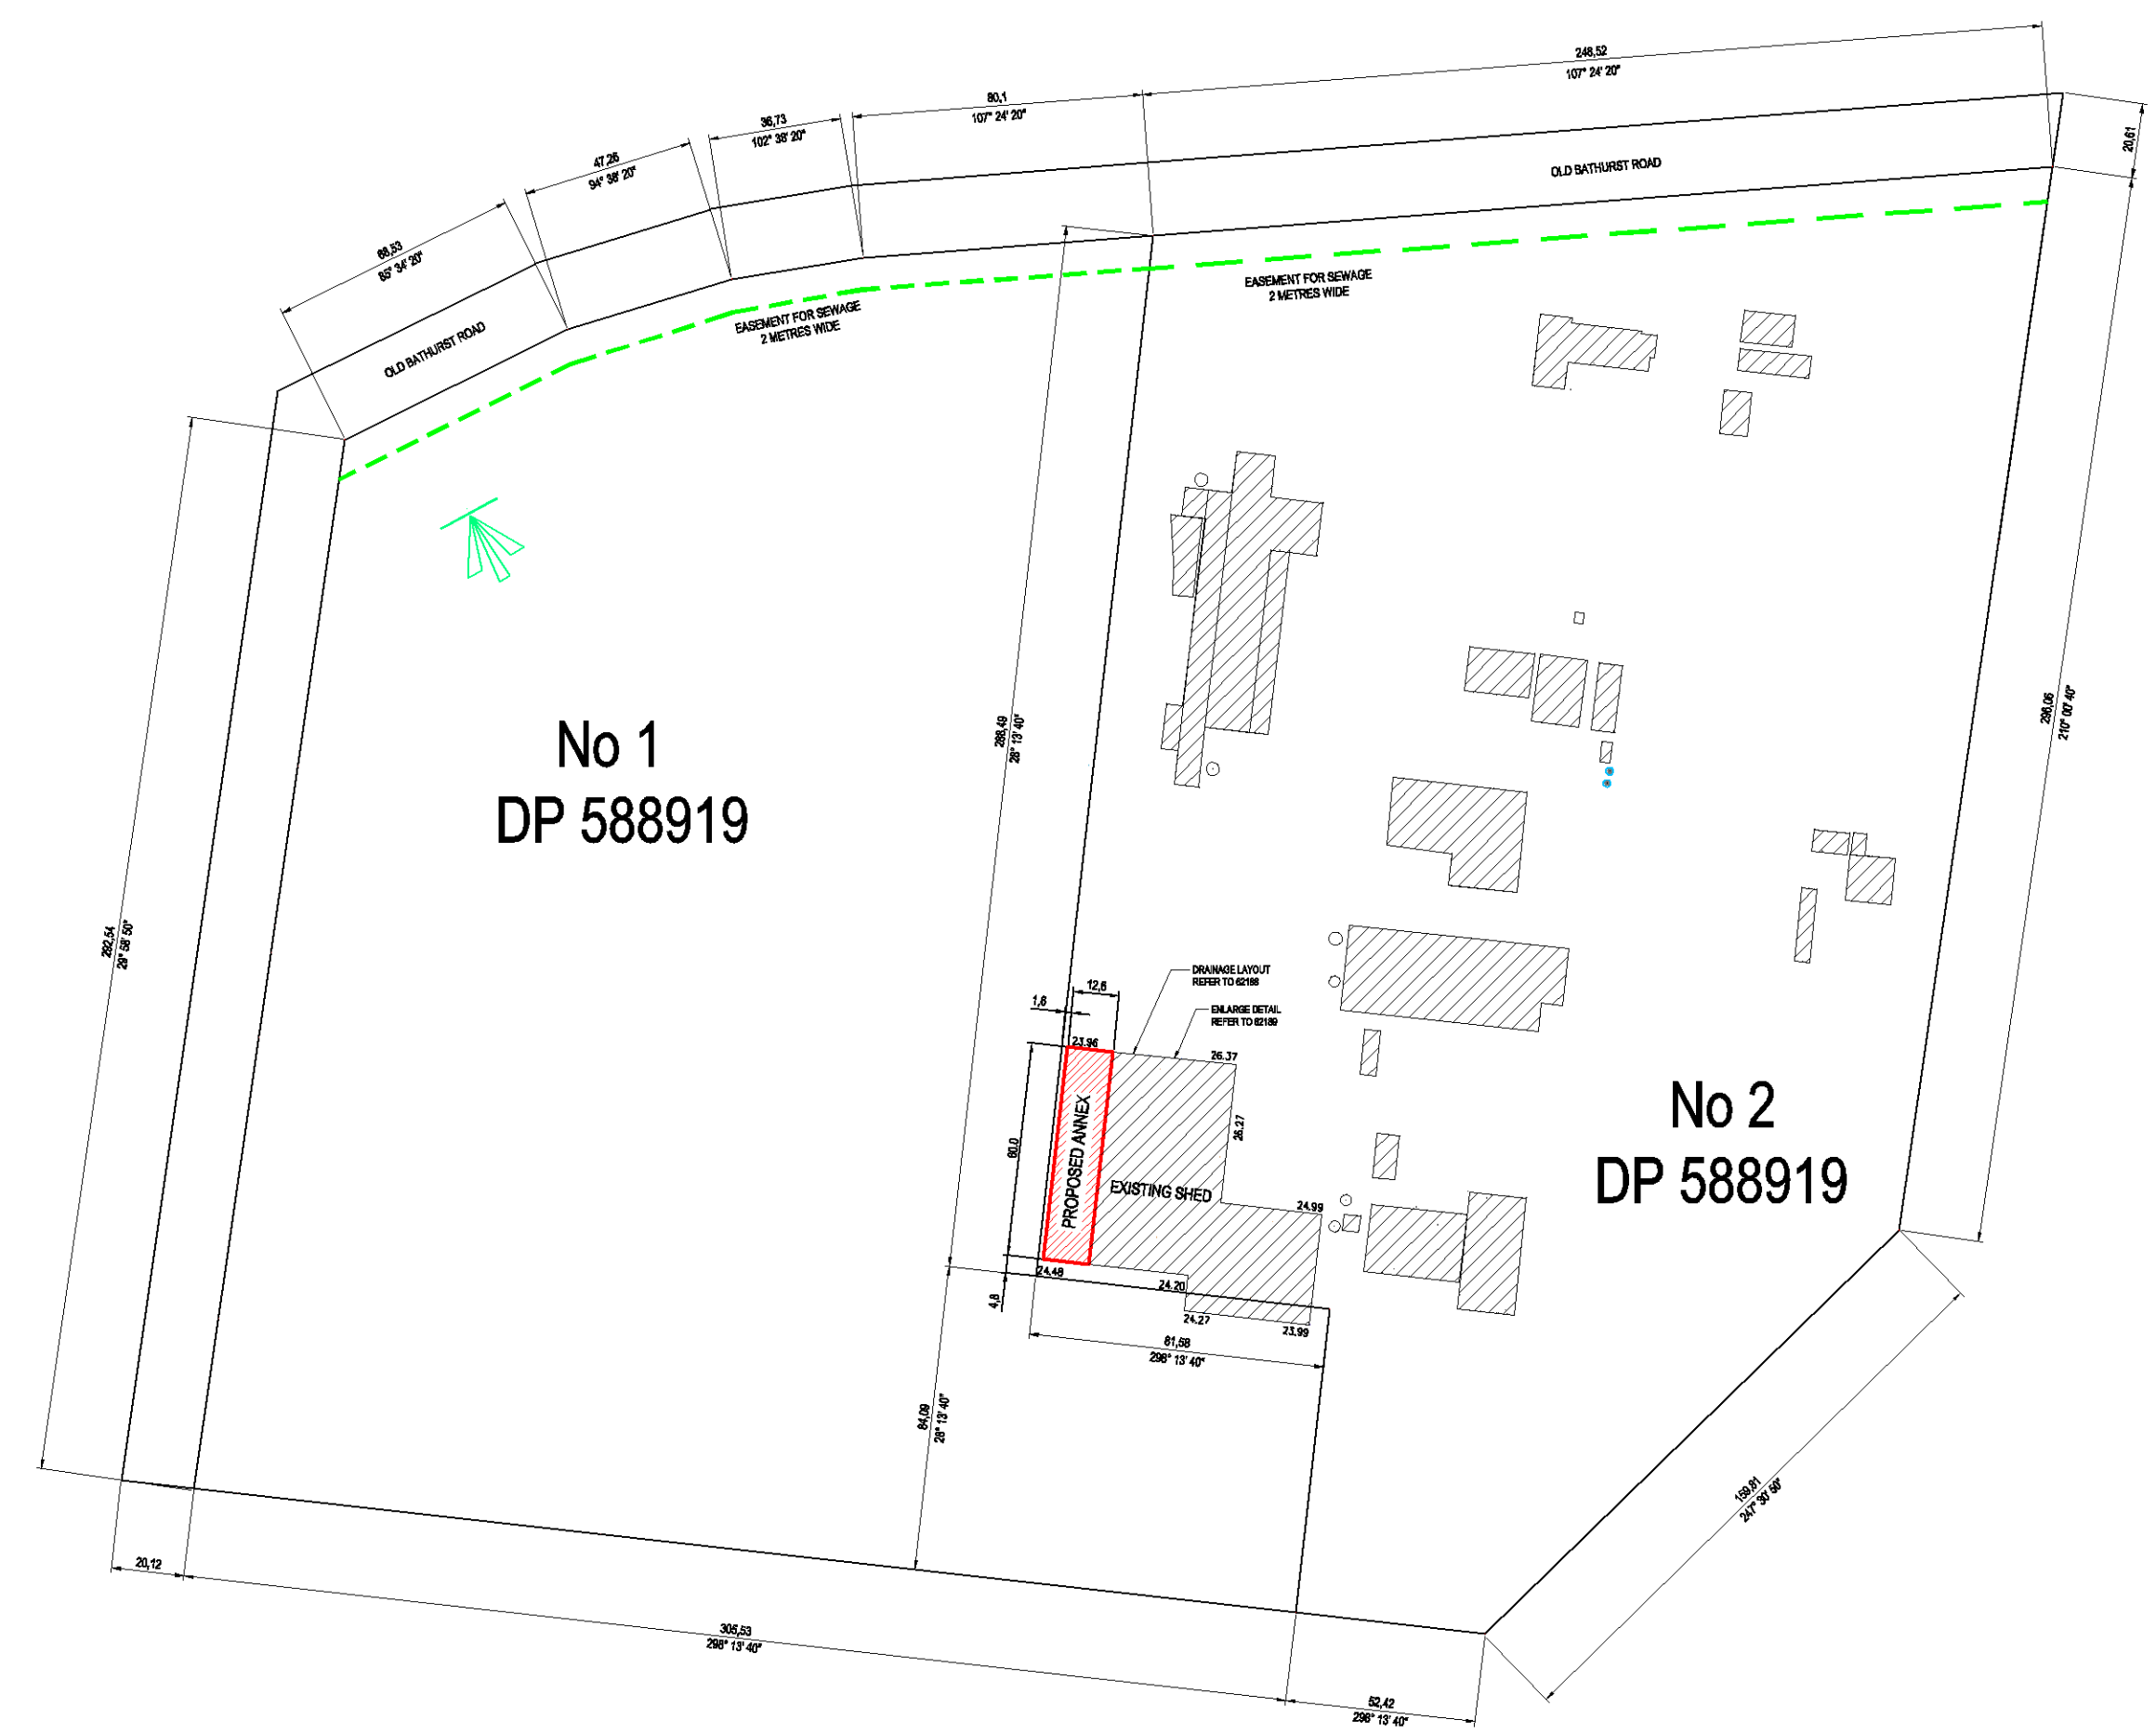

No 1
DP 588919

No 2
DP 588919

NOTE: ALL DIMENSION IN METRES


CONFIDENTIAL
(NOT TO BE DISCLOSED TO ANY OTHER PERSON WITHOUT PERMISSION FROM ROCIA LIMITED. UNAUTHORISED DISCLOSURE MAY RESULT IN PROSECUTIONS)
This drawing is the property of Rocia Limited. It is submitted for use only in connection with proposals and contracts of Rocia Pty Limited upon the express condition that it is not to be reproduced or copied in any form. Calls to be used only with reference to products manufactured and supplied by Rocia Pty Limited.



UNLESS OTHERWISE SPECIFIED:
ALL DIMENSIONS ARE IN METRES
DIMENSIONS FOR REFLECTION DIMENSIONS AT MATCHED DIMENSIONS AS SHOWN UNLESS OTHERWISE STATED

EMU PLAINS
PLANT LAYOUT
EMU PLAINS

APPROVED	GW	DATE	25/10/16
CHECKED	ST	DATE	25/10/16
DRAWN	GG	DATE	25/10/16
REV.		DATE	NTS
B	62186	A	

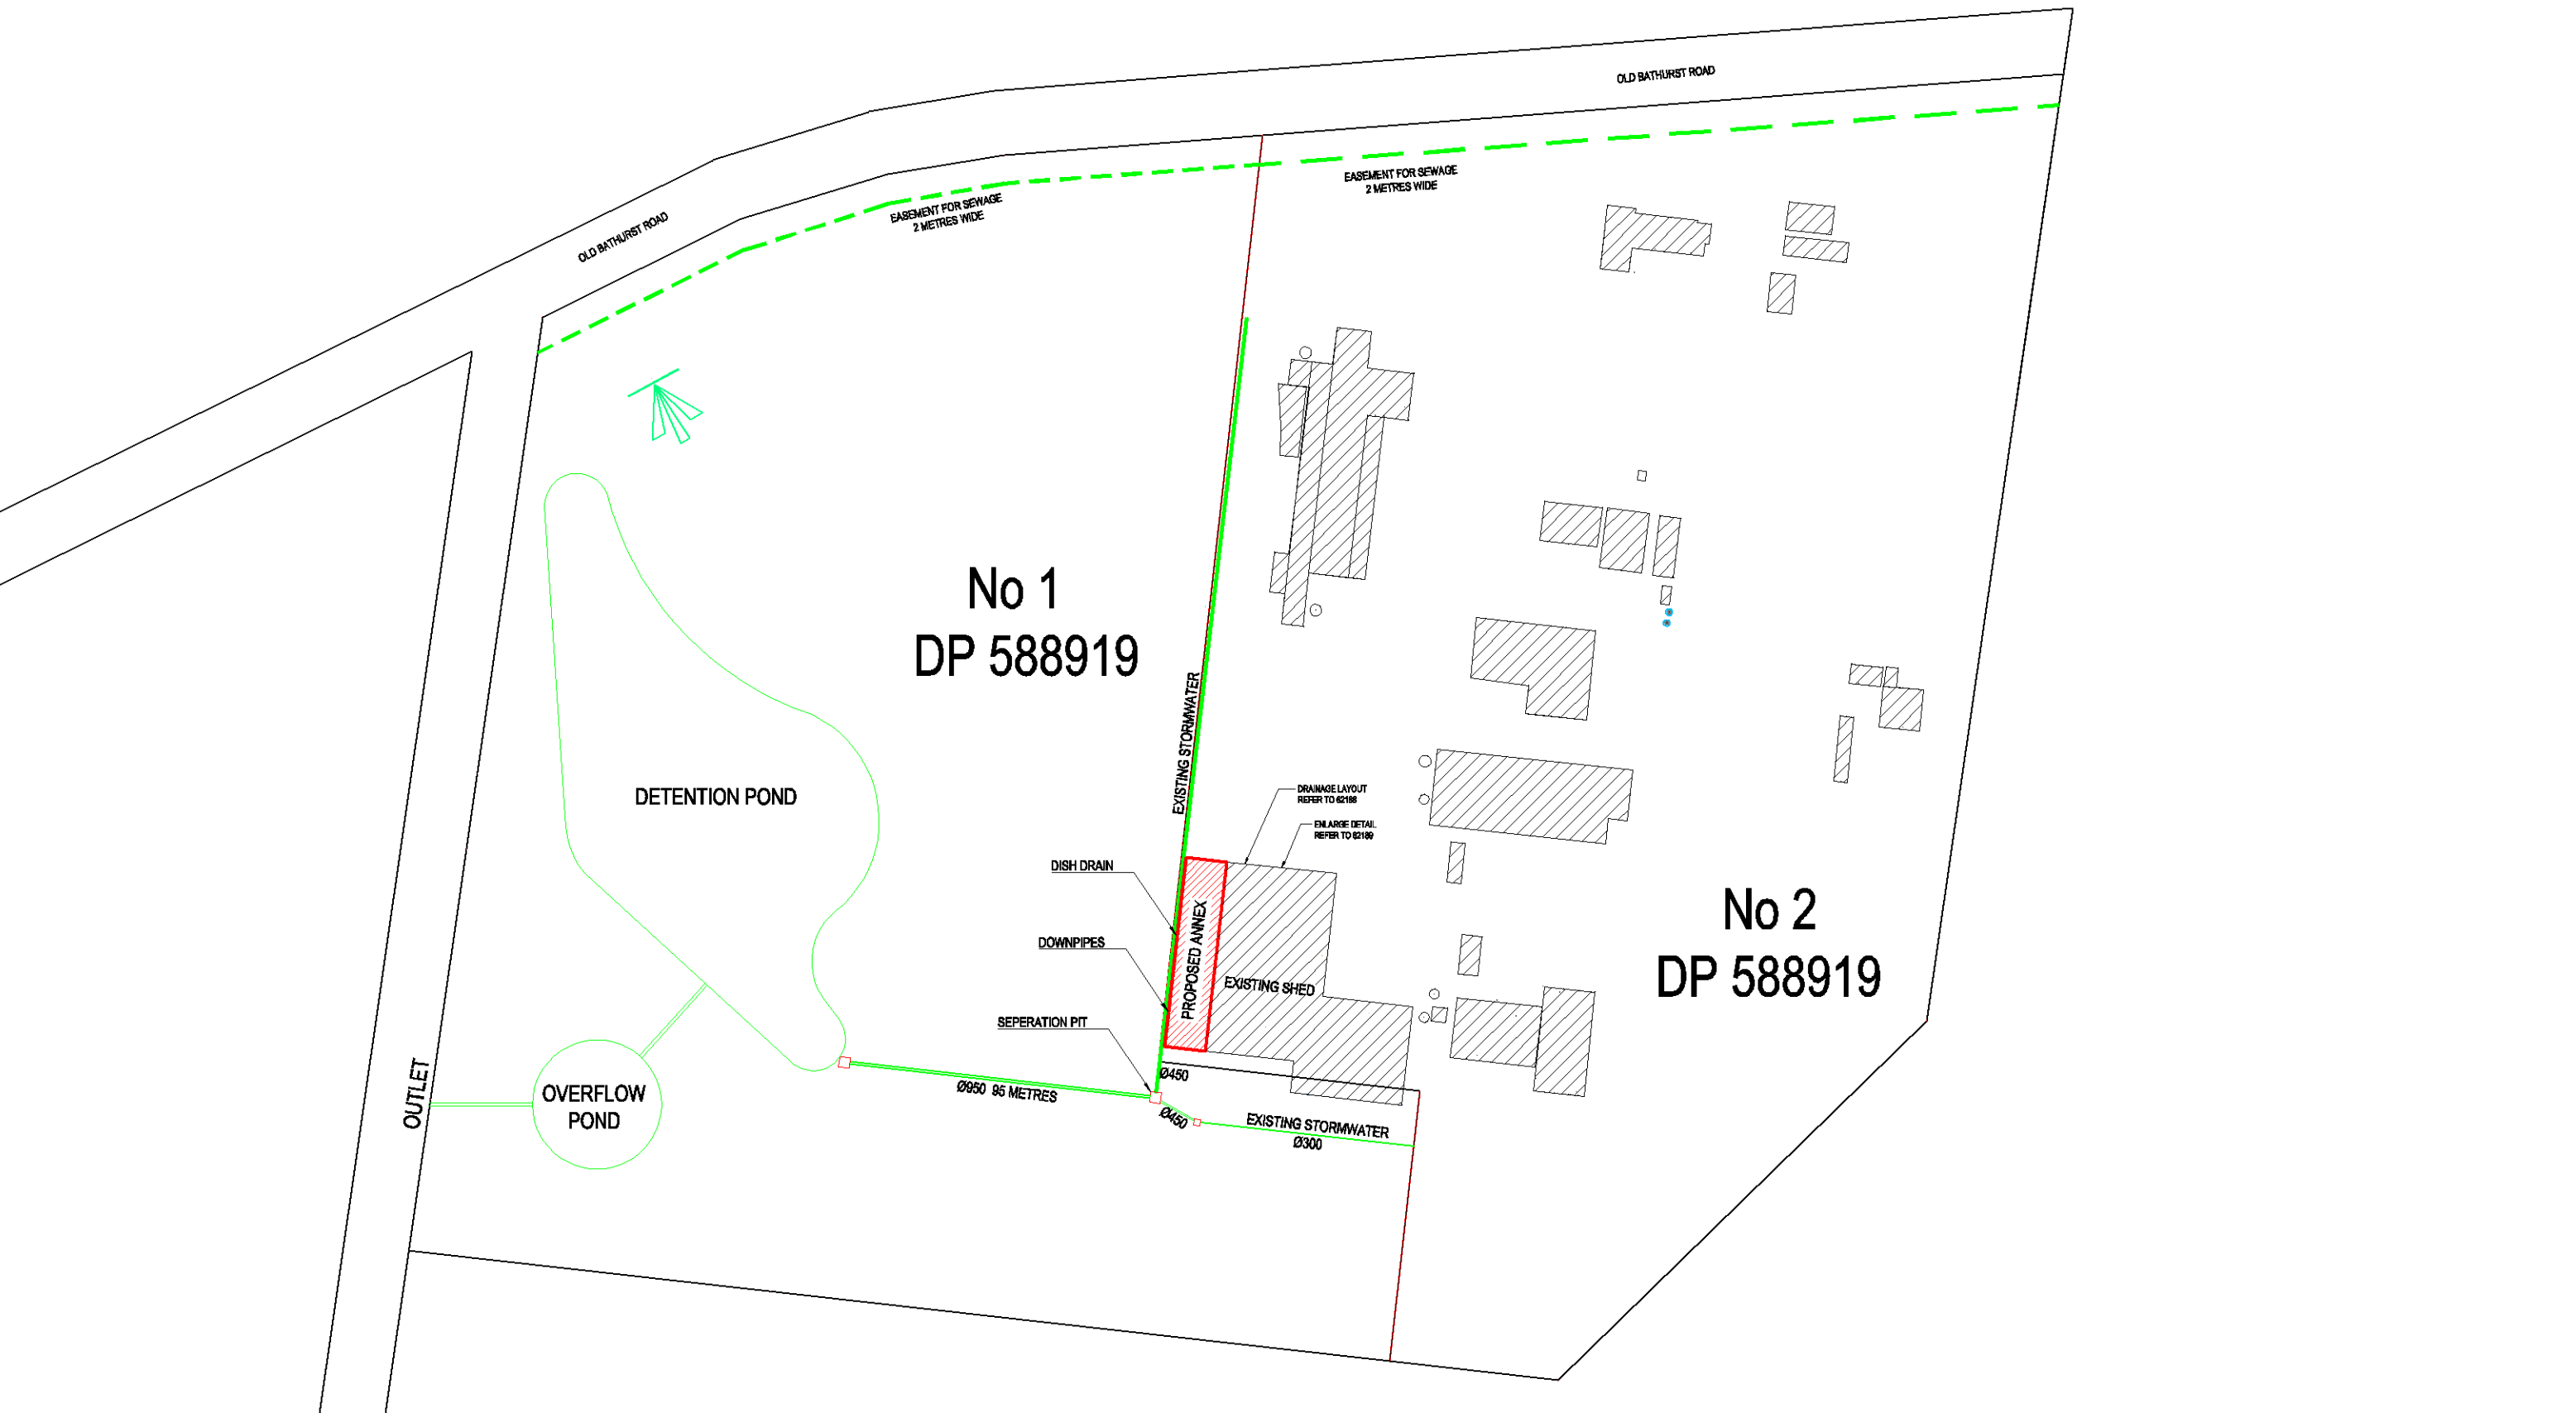

No 1
DP 588919

No 2
DP 588919

DETENTION POND

OVERFLOW POND

OUTLET

DISH DRAIN
 DOWNPIPES
 SEPERATION PIT
 Ø950 86 METRES
 Ø450
 Ø300
 EXISTING STORMWATER
 PROPOSED ANNEX
 EXISTING SHED
 DRAINAGE LAYOUT REFER TO G2186
 ENLARGE DETAIL REFER TO G2186

EASEMENT FOR SEWAGE
2 METRES WIDE

EASEMENT FOR SEWAGE
2 METRES WIDE

OLD BATHURST ROAD

OLD BATHURST ROAD

CONFIDENTIAL
 (NOT TO BE DISCLOSED TO ANY OTHER PERSON WITHOUT PERMISSION FROM ROCIA LIMITED. UNAUTHORISED DISCLOSURE MAY RESULT IN PROSECUTION)
 This drawing is the property of Rocia Pty Limited. It is submitted for use only in connection with proposals and contracts of Rocia Pty Limited upon the express condition that it is not to be reproduced or copied in any form. Calls to be used only with reference to products manufactured and supplied by Rocia Pty Limited.



UNLESS OTHERWISE SPECIFIED:
 ALL DIMENSIONS ARE IN MILLIMETRES
 REFLECTED DIMENSIONS AT APPOINTED DIMENSIONS UNLESS OTHERWISE SPECIFIED

EMU PLAINS
 PLANT LAYOUT
 EMU PLAINS

APPROVED	GW	DATE	25/10/16
CHECKED	ST	DATE	25/10/16
DRAWN	GG	DATE	25/10/16
PROJECT	-	DATE	NTS
B	62186	B	