

CADDENS HILL SPORTS PRECINCT

LIGHTING LEGEND

SYMBOL	DESCRIPTION	HOUSING/COLOUR	REFLECTOR	LAMP	CONTROL GEAR	SUPPLIER	PRODUCT No.
FL1	IP66 IK06 FLOOD LIGHT MOUNTED ON LIGHT POLE AT 25.0m FOR SPORTS OVAL	BLACK WITH GREY ALUMINIUM FRAME	ASYMMETRIC NARROW BEAM	1270W LED 5700K CRI 70	REMOTE 240V ELECTRONIC CONTROL GEAR	GERARD LIGHTING SYLVANIA	BRITELINE LED RAPTOR SR4H757A2
PT1	IP66 IK08 POST-TOP LUMINAIRE MOUNTED ON A TAPERED ROUND POLE AT 8.0m FOR DISABLED CARPARK	POWDERCOAT BLACK RAL9004	RECTANGLE FORWARD THROW [R65]	84W LED 3000K	INTEGRAL ELECTRONIC CONTROL GEAR	LIGHT CULTURE WE-EF	VFL540 108-1079
PT2	IP66 IK08 POST-TOP LUMINAIRE MOUNTED ON A TAPERED ROUND POLE AT 8.0m FOR GENERAL CARPARK	POWDERCOAT BLACK RAL9004	ASYMMETRIC FORWARD THROW [A60]	48W LED 3000K	INTEGRAL ELECTRONIC CONTROL GEAR	LIGHT CULTURE WE-EF	VFL540 108-1059
PT3	IP66 IK08 POST-TOP LUMINAIRE MOUNTED ON A TAPERED ROUND POLE AT 8.0m FOR GENERAL CARPARK	POWDERCOAT BLACK RAL9004	ASYMMETRIC FORWARD THROW [A60]	24W LED 3000K	INTEGRAL ELECTRONIC CONTROL GEAR	LIGHT CULTURE WE-EF	VFL540 108-1057

DRAWING LIST

 
EL-001	LEGEND & DRAWING LIST
EL-100	LIGHTING & ELECTRICAL LAYOUT
EL-200	LIGHTING DETAIL - SHEET 1
EL-201	LIGHTING DETAIL - SHEET 2
EL-300	SINGLE LINE DIAGRAM

POWER LEGEND

SYMBOL	DESCRIPTION	HOUSING/COLOUR	SUPPLIER
	MAIN SWITCH BOARD	316 STAINLESS STEEL N4 FINISH	REFER TO SINGLE LINE DIAGRAM
	SWITCHBOARD BY OTHERS	-	BY OTHERS
	HD ELECTRICAL CONDUIT SIZE AS NOTED	ORANGE	-

Notes:

Issue	Amendment	Date
T1	TENDER ISSUE	17-11-17



N.T.S.

Lead Consultant
PLACE DESIGN GROUP
Client
LEGACY PROPERTY




Lighting, Art & Science
Lighting Consultants, Electrical Engineers
Level 1, 41 Hume St, Crows Nest NSW 2065
p: +61 2 9436 0998 e: mail@laands.com.au

© Copyright 2017 Lighting, Art & Science Pty Limited ABN 64 152 715 921
All rights reserved. This drawing may not be reproduced or transmitted in any form or means in part or in whole without written permission of Lighting, Art & Science Pty Ltd


Project CADDENS HILL SPORTS PRECINCT

Drawing LEGEND & DRAWING LIST

Drawn LA	Approv. RM	Date NOV 2017	Scale N.T.S.
Project No L150I	Drawing No EL-001	Rev T1	

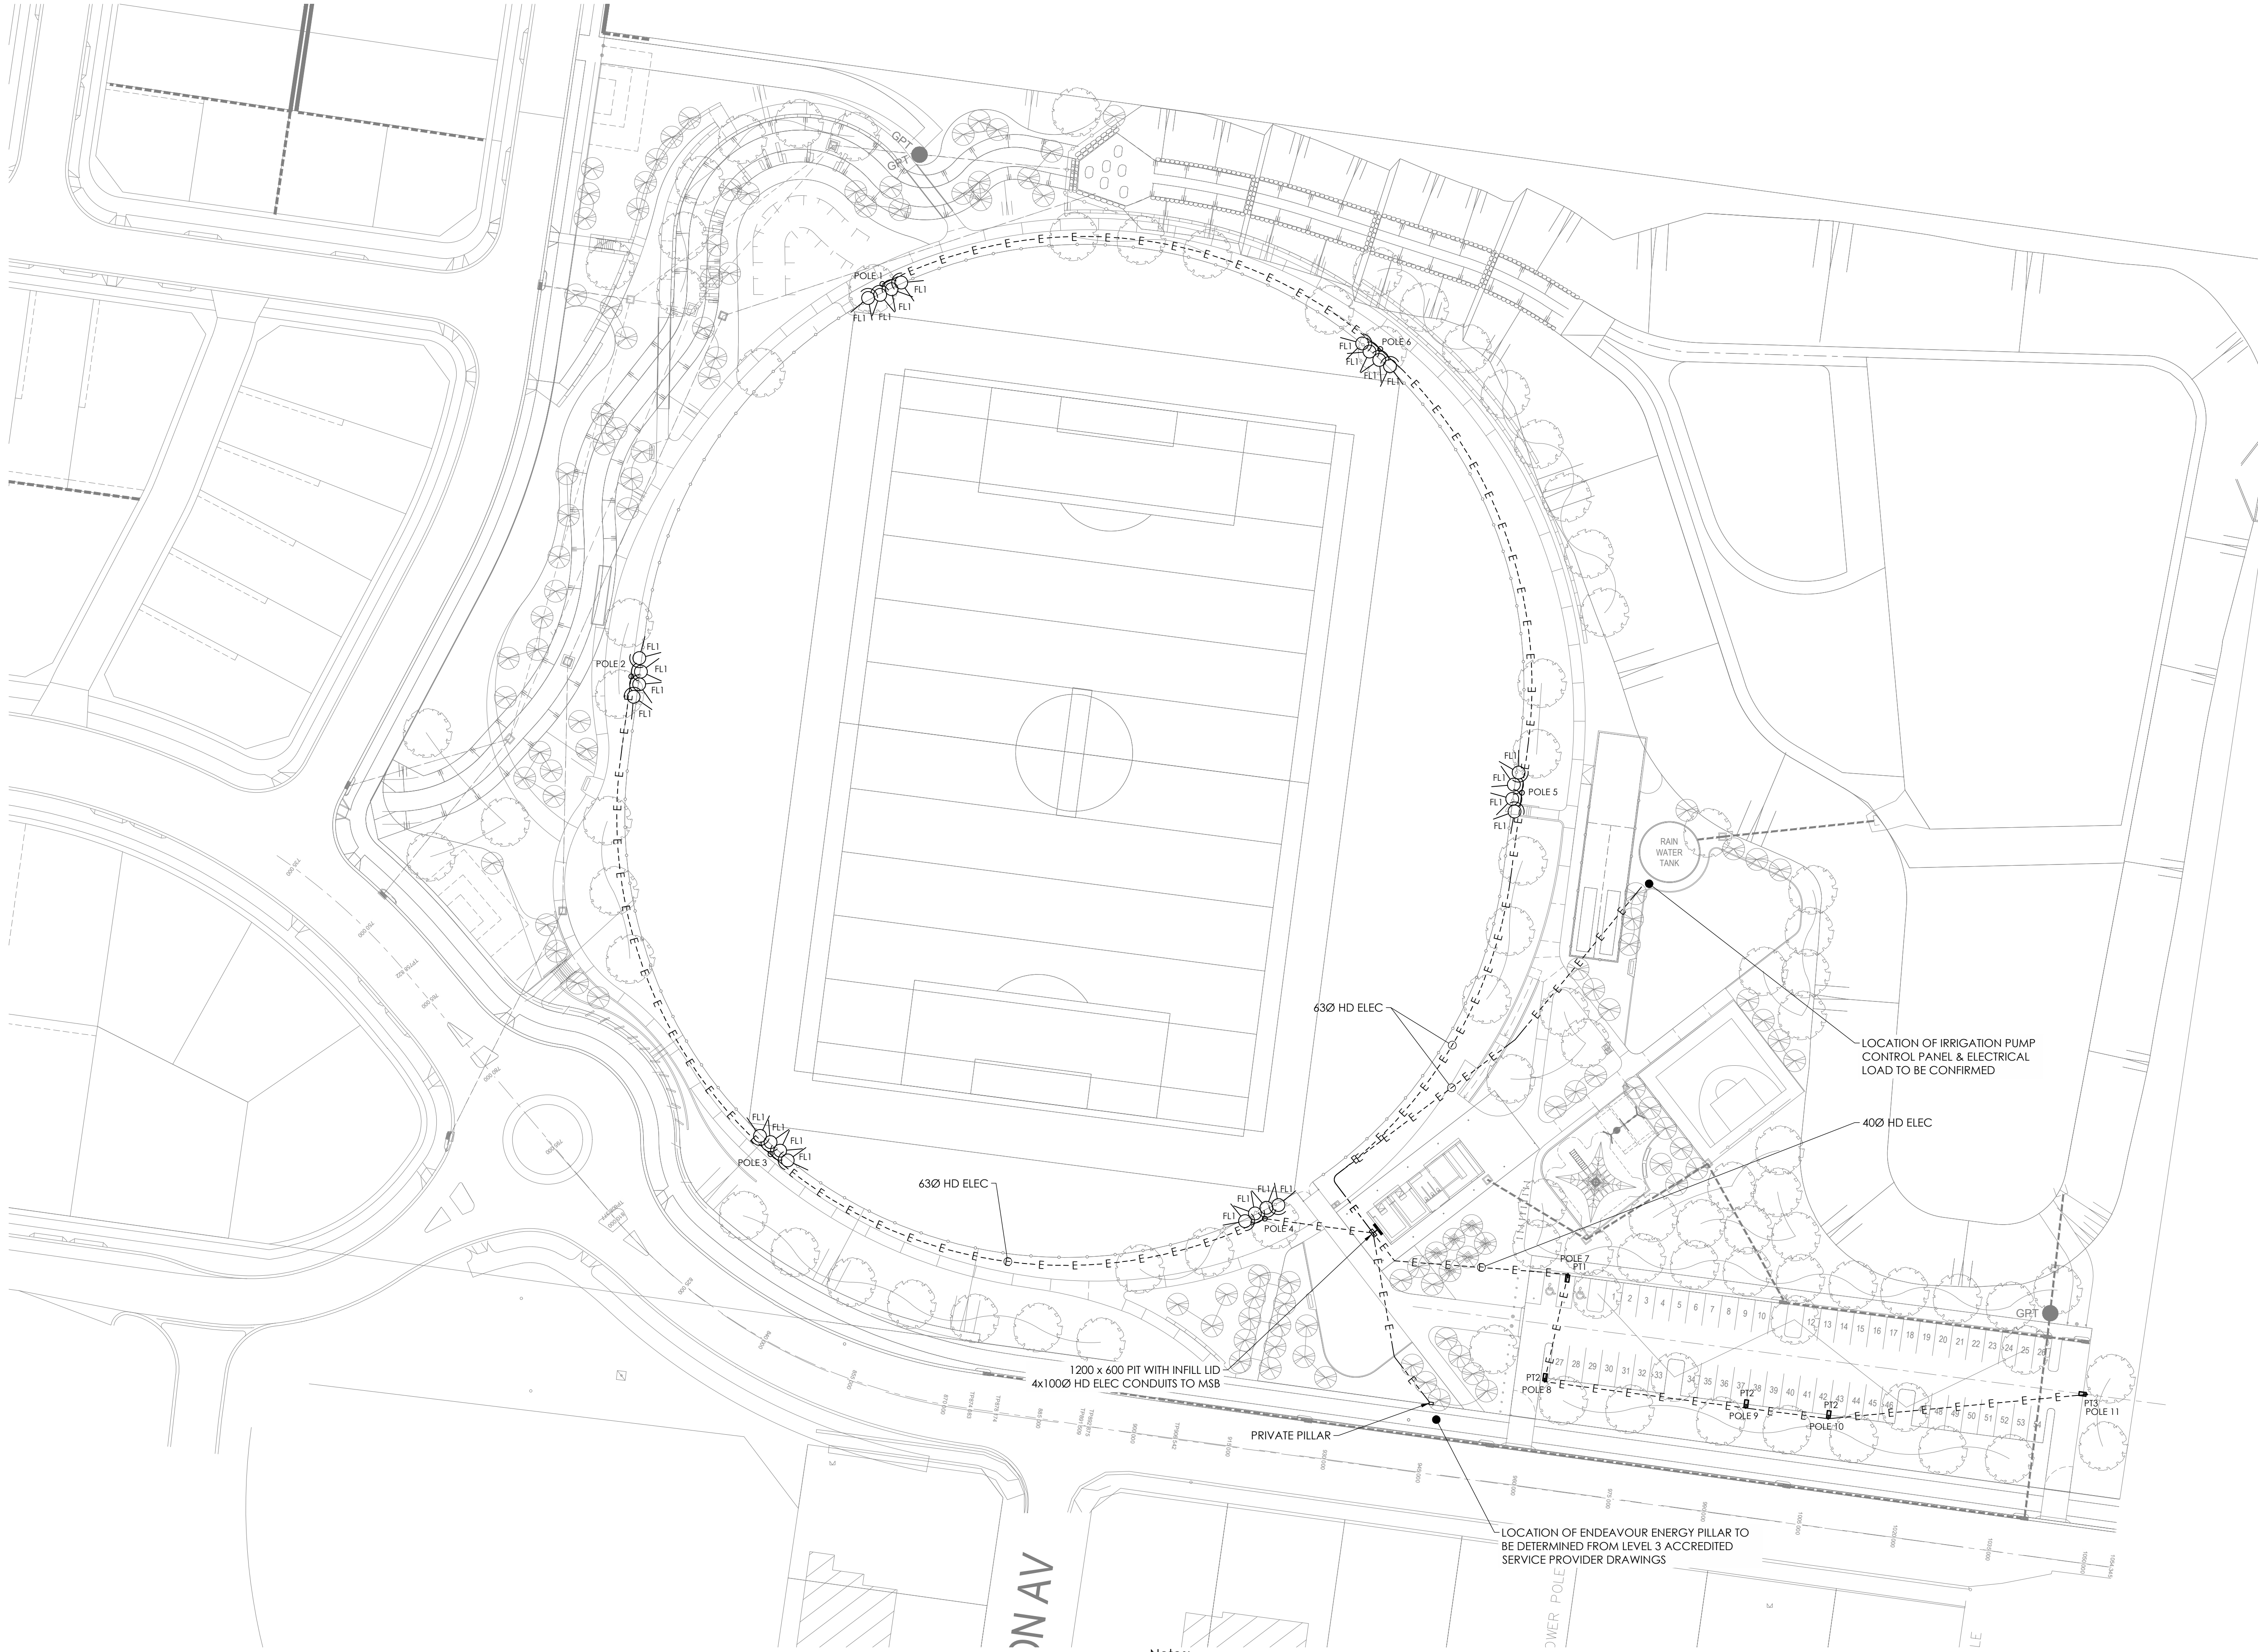

Issue T1
Amendment TENDER ISSUE
Date 17-11-17

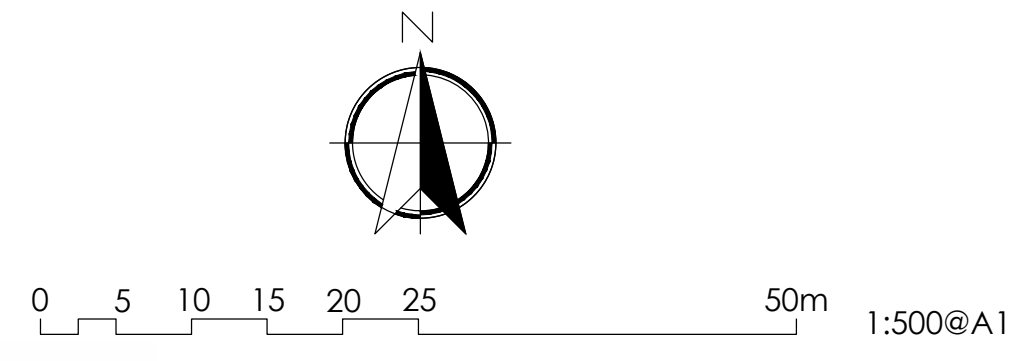

Notes:

Lead Consultant
PLACE DESIGN GROUP
Client
LEGACY PROPERTY



Lighting, Art & Science
Lighting Consultants, Electrical Engineers
Level 1, 41 Hume St, Crows Nest NSW 2065
p: +61 2 9436 0998 e: mail@laands.com.au

© Copyright 2017 Lighting, Art & Science Pty Limited ABN 64 152 715 921
All rights reserved. This drawing may not be reproduced or transmitted in any form or means in part or in whole without written permission of Lighting, Art & Science Pty Ltd

Project	CADDENS HILL SPORTS PRECINCT		
Drawing	LIGHTING & ELECTRICAL LAYOUT		
Drawn LA	Approv. RM	Date NOV 2017	Scale 1:500@A1
Project No L150I	Drawing No EL-100	Rev T1	

Issue	Amendment	Date
T1	TENDER ISSUE	17-11-17

T:\Projects\L150\L150 - Caddens Hill Sports Precinct\L150-DG\L150-EL.dwg - 200 - 17/11/2017 - 11:02:16 AM

Document Set ID: 8182523
Version: 1, Version Date: 11/05/2018

AS SHOWN

- Notes:
1. Typical flood light pole - side and front view - for 100 lx.
 2. Refer to plans for luminaire aiming
 3. Provide shop drawings

Lead Consultant
PLACE DESIGN GROUP
Client
LEGACY PROPERTY



Lighting, Art & Science
Lighting Consultants, Electrical Engineers
Level 1, 41 Hume St, Crows Nest NSW 2065
p: +61 2 9436 0998 e: mail@laands.com.au

© Copyright 2017 Lighting, Art & Science Pty Limited ABN 64 152 715 921
All rights reserved. This drawing may not be reproduced or transmitted in any form or means in part or in whole without written permission of Lighting, Art & Science Pty Ltd

Project CADDENS HILL SPORTS PRECINCT




Drawing LIGHTING DETAIL - SHEET 1

Drawn LA
Project No
L150I

Approv. RM
Drawing No
EL-200

Date
NOV 2017

Scale
AS SHOWN
Rev
T1

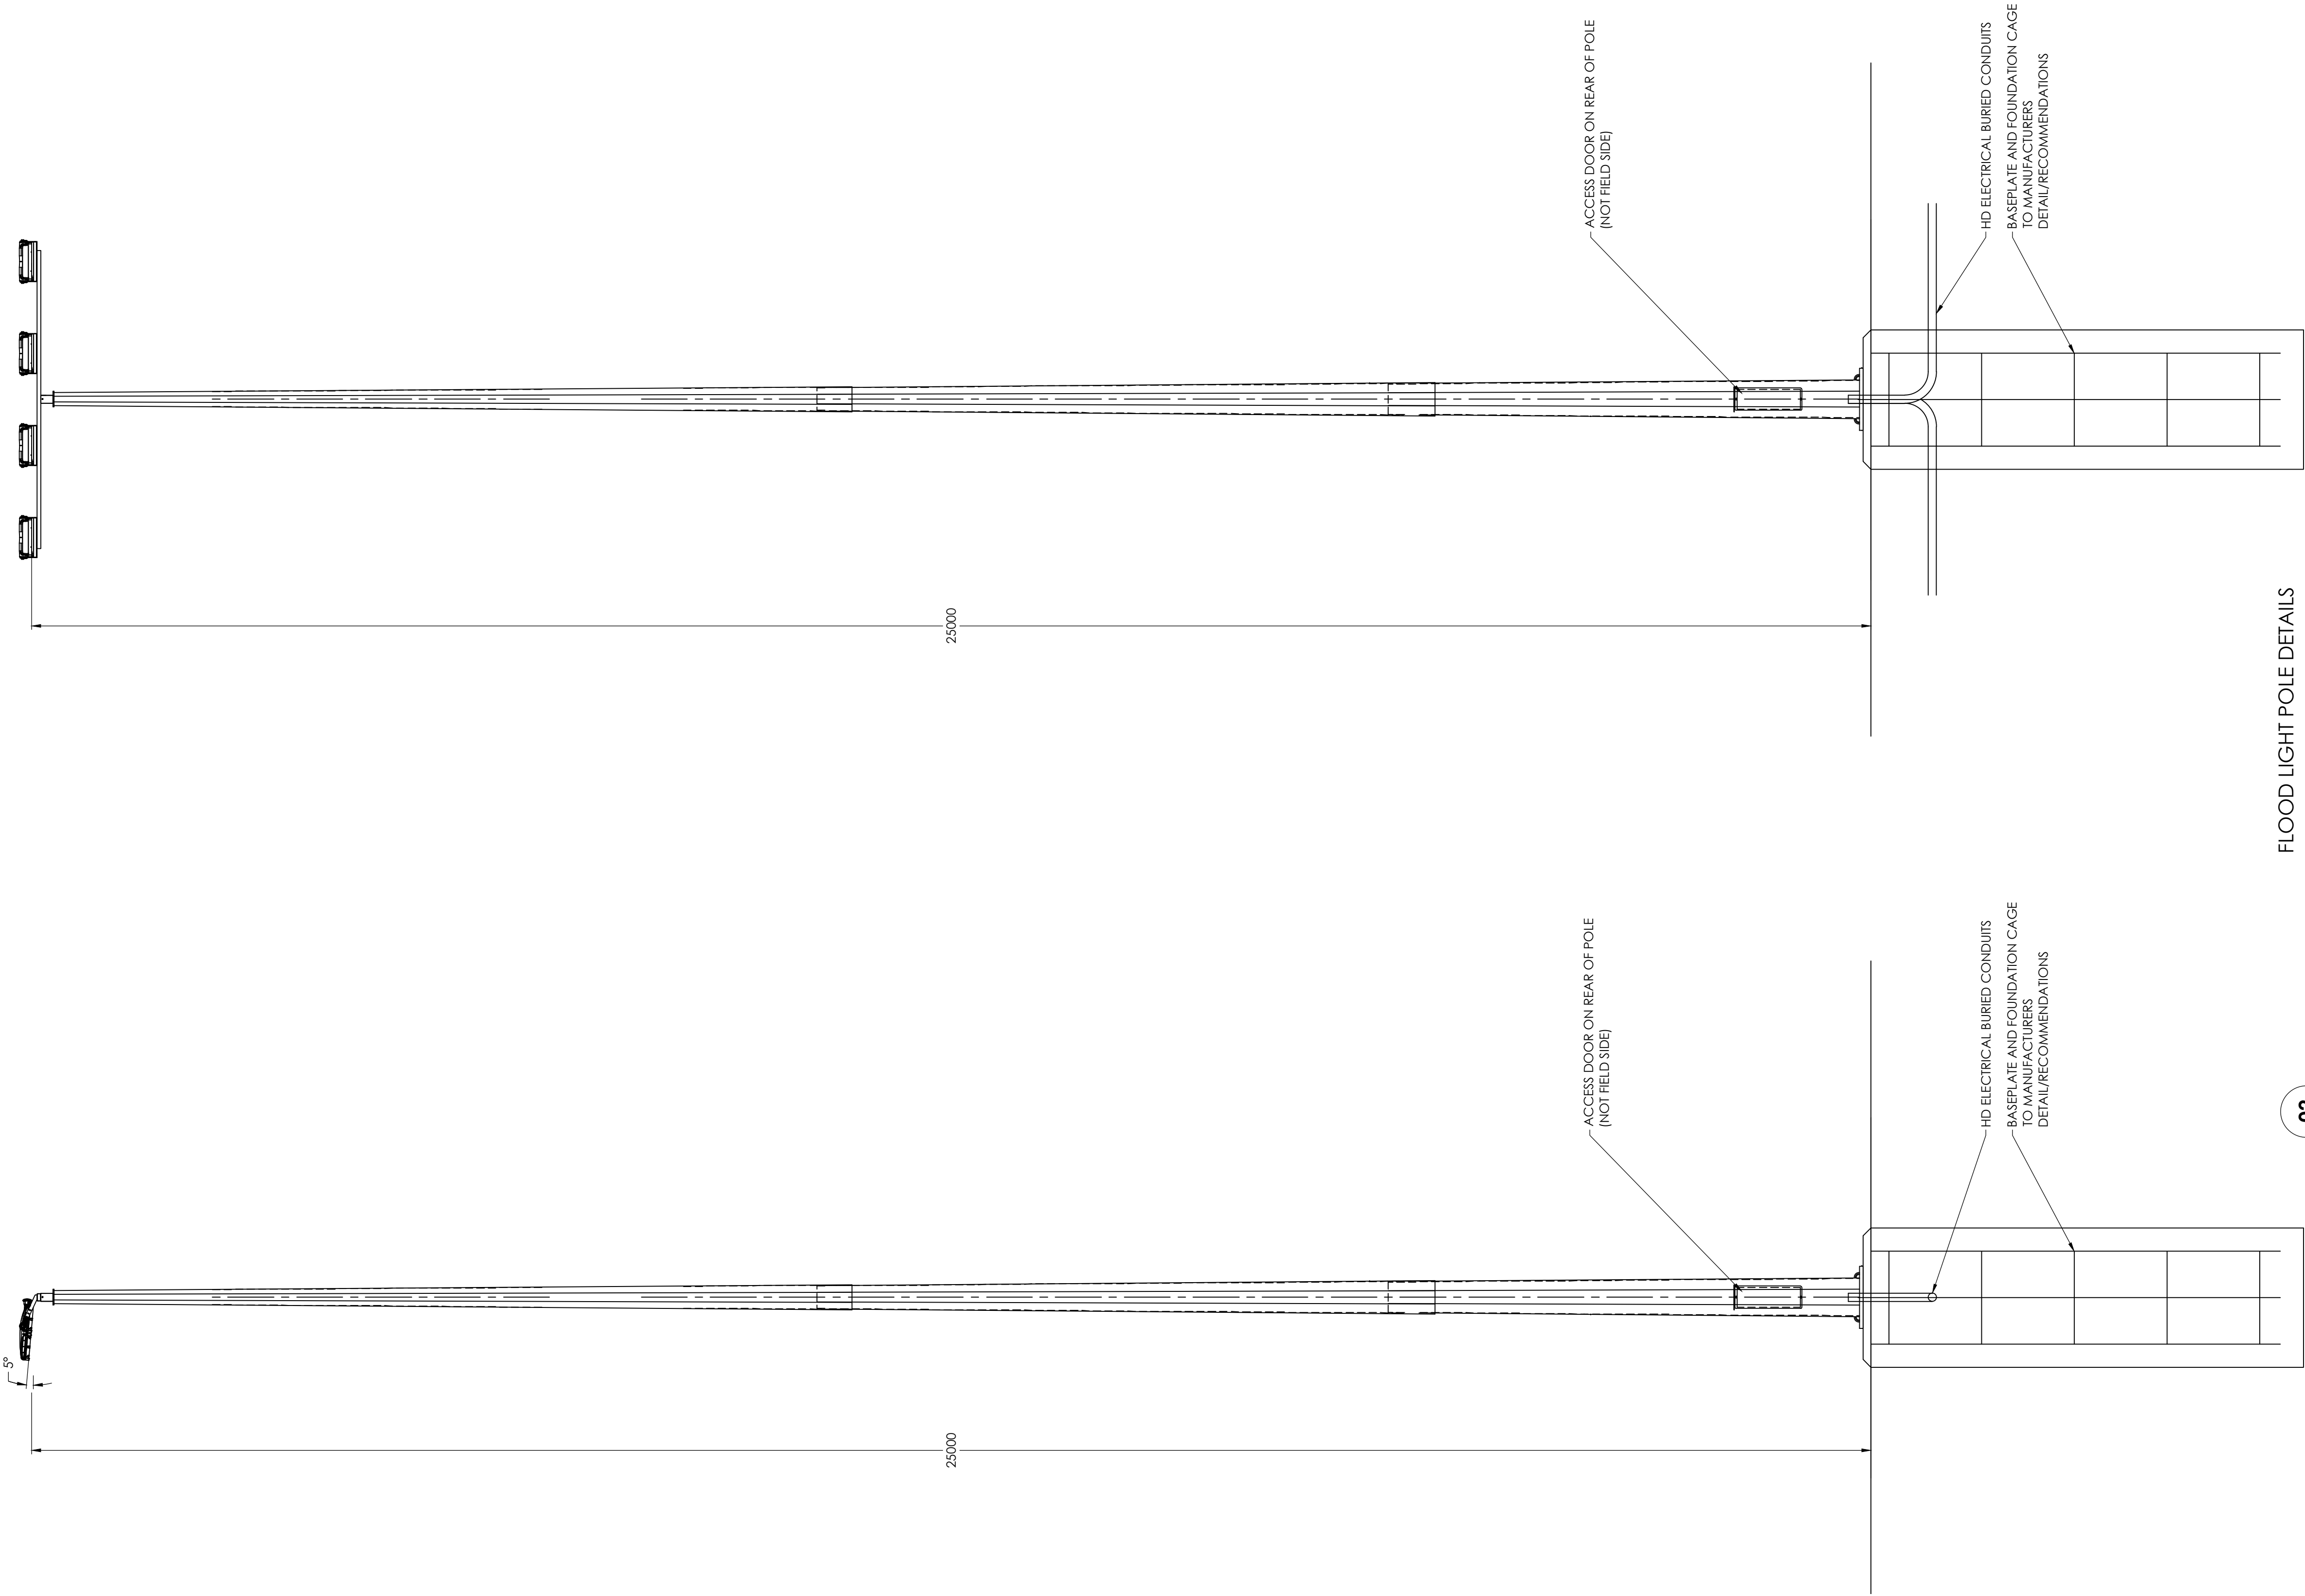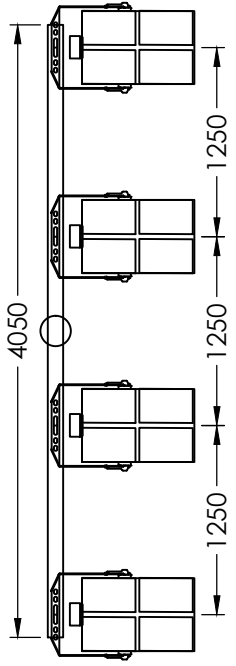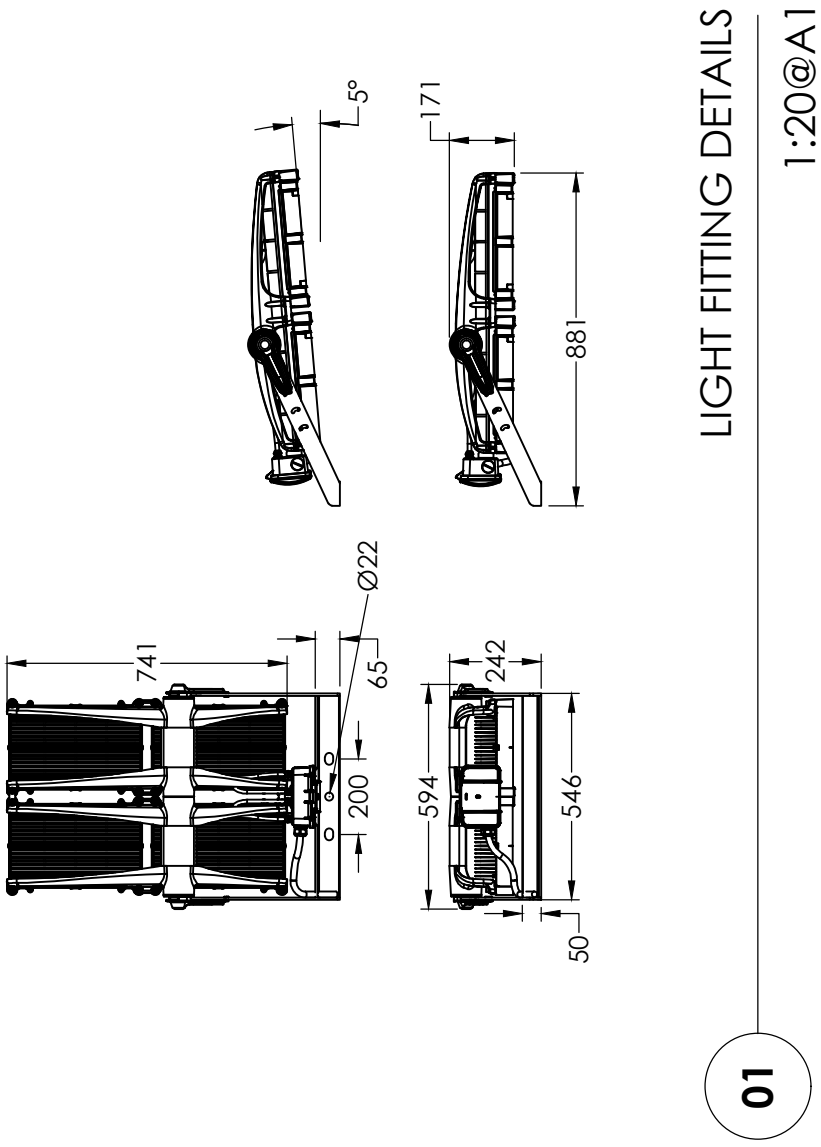

- Notes:
- Typical car park pole - side and front view
 - Provide shop drawings

Lead Consultant
PLACE DESIGN GROUP

Client
LEGACY PROPERTY

Lighting, Art & Science

Lighting Consultants, Electrical Engineers

Level 1, 41 Hume St, Crows Nest NSW 2065

p: +61 2 9436 0998 e: mail@laands.com.au

© Copyright 2017 Lighting, Art & Science Pty Limited ABN 64 152 715 921

All rights reserved. This drawing may not be reproduced or transferred in any form or means in part or in whole without written permission of Lighting, Art & Science Pty Ltd

Project

CADDENS HILL SPORTS PRECINCT

Drawing

LIGHTING DETAIL - SHEET 2

Drawn LA

Project No

L150I

Approv. RM

Drawing No

EL-201

Date


NOV 2017

Scale

AS SHOWN

Rev


T1

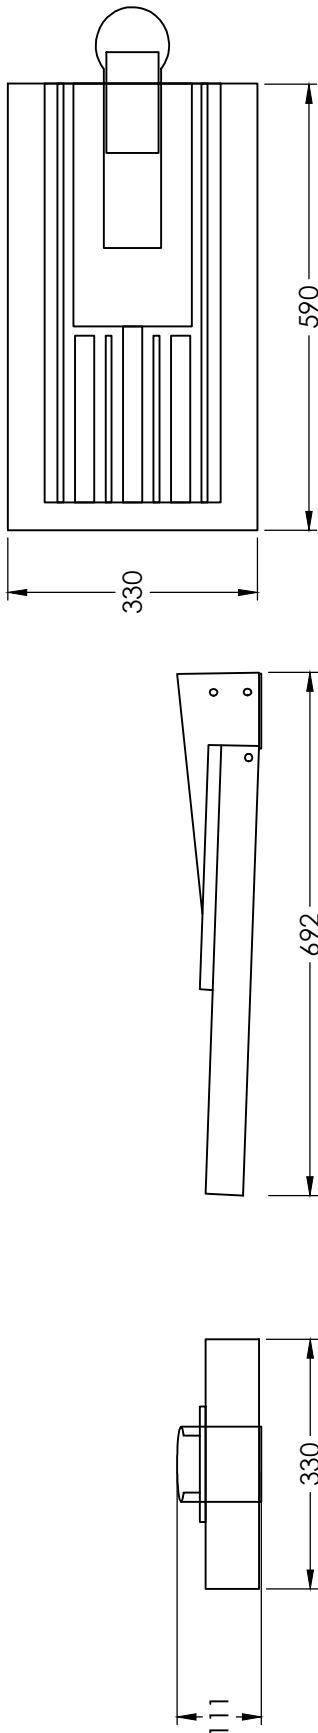

03

TYPE PT1, PT2 & PT3 LIGHT FITTING DETAILS


1:10@A1

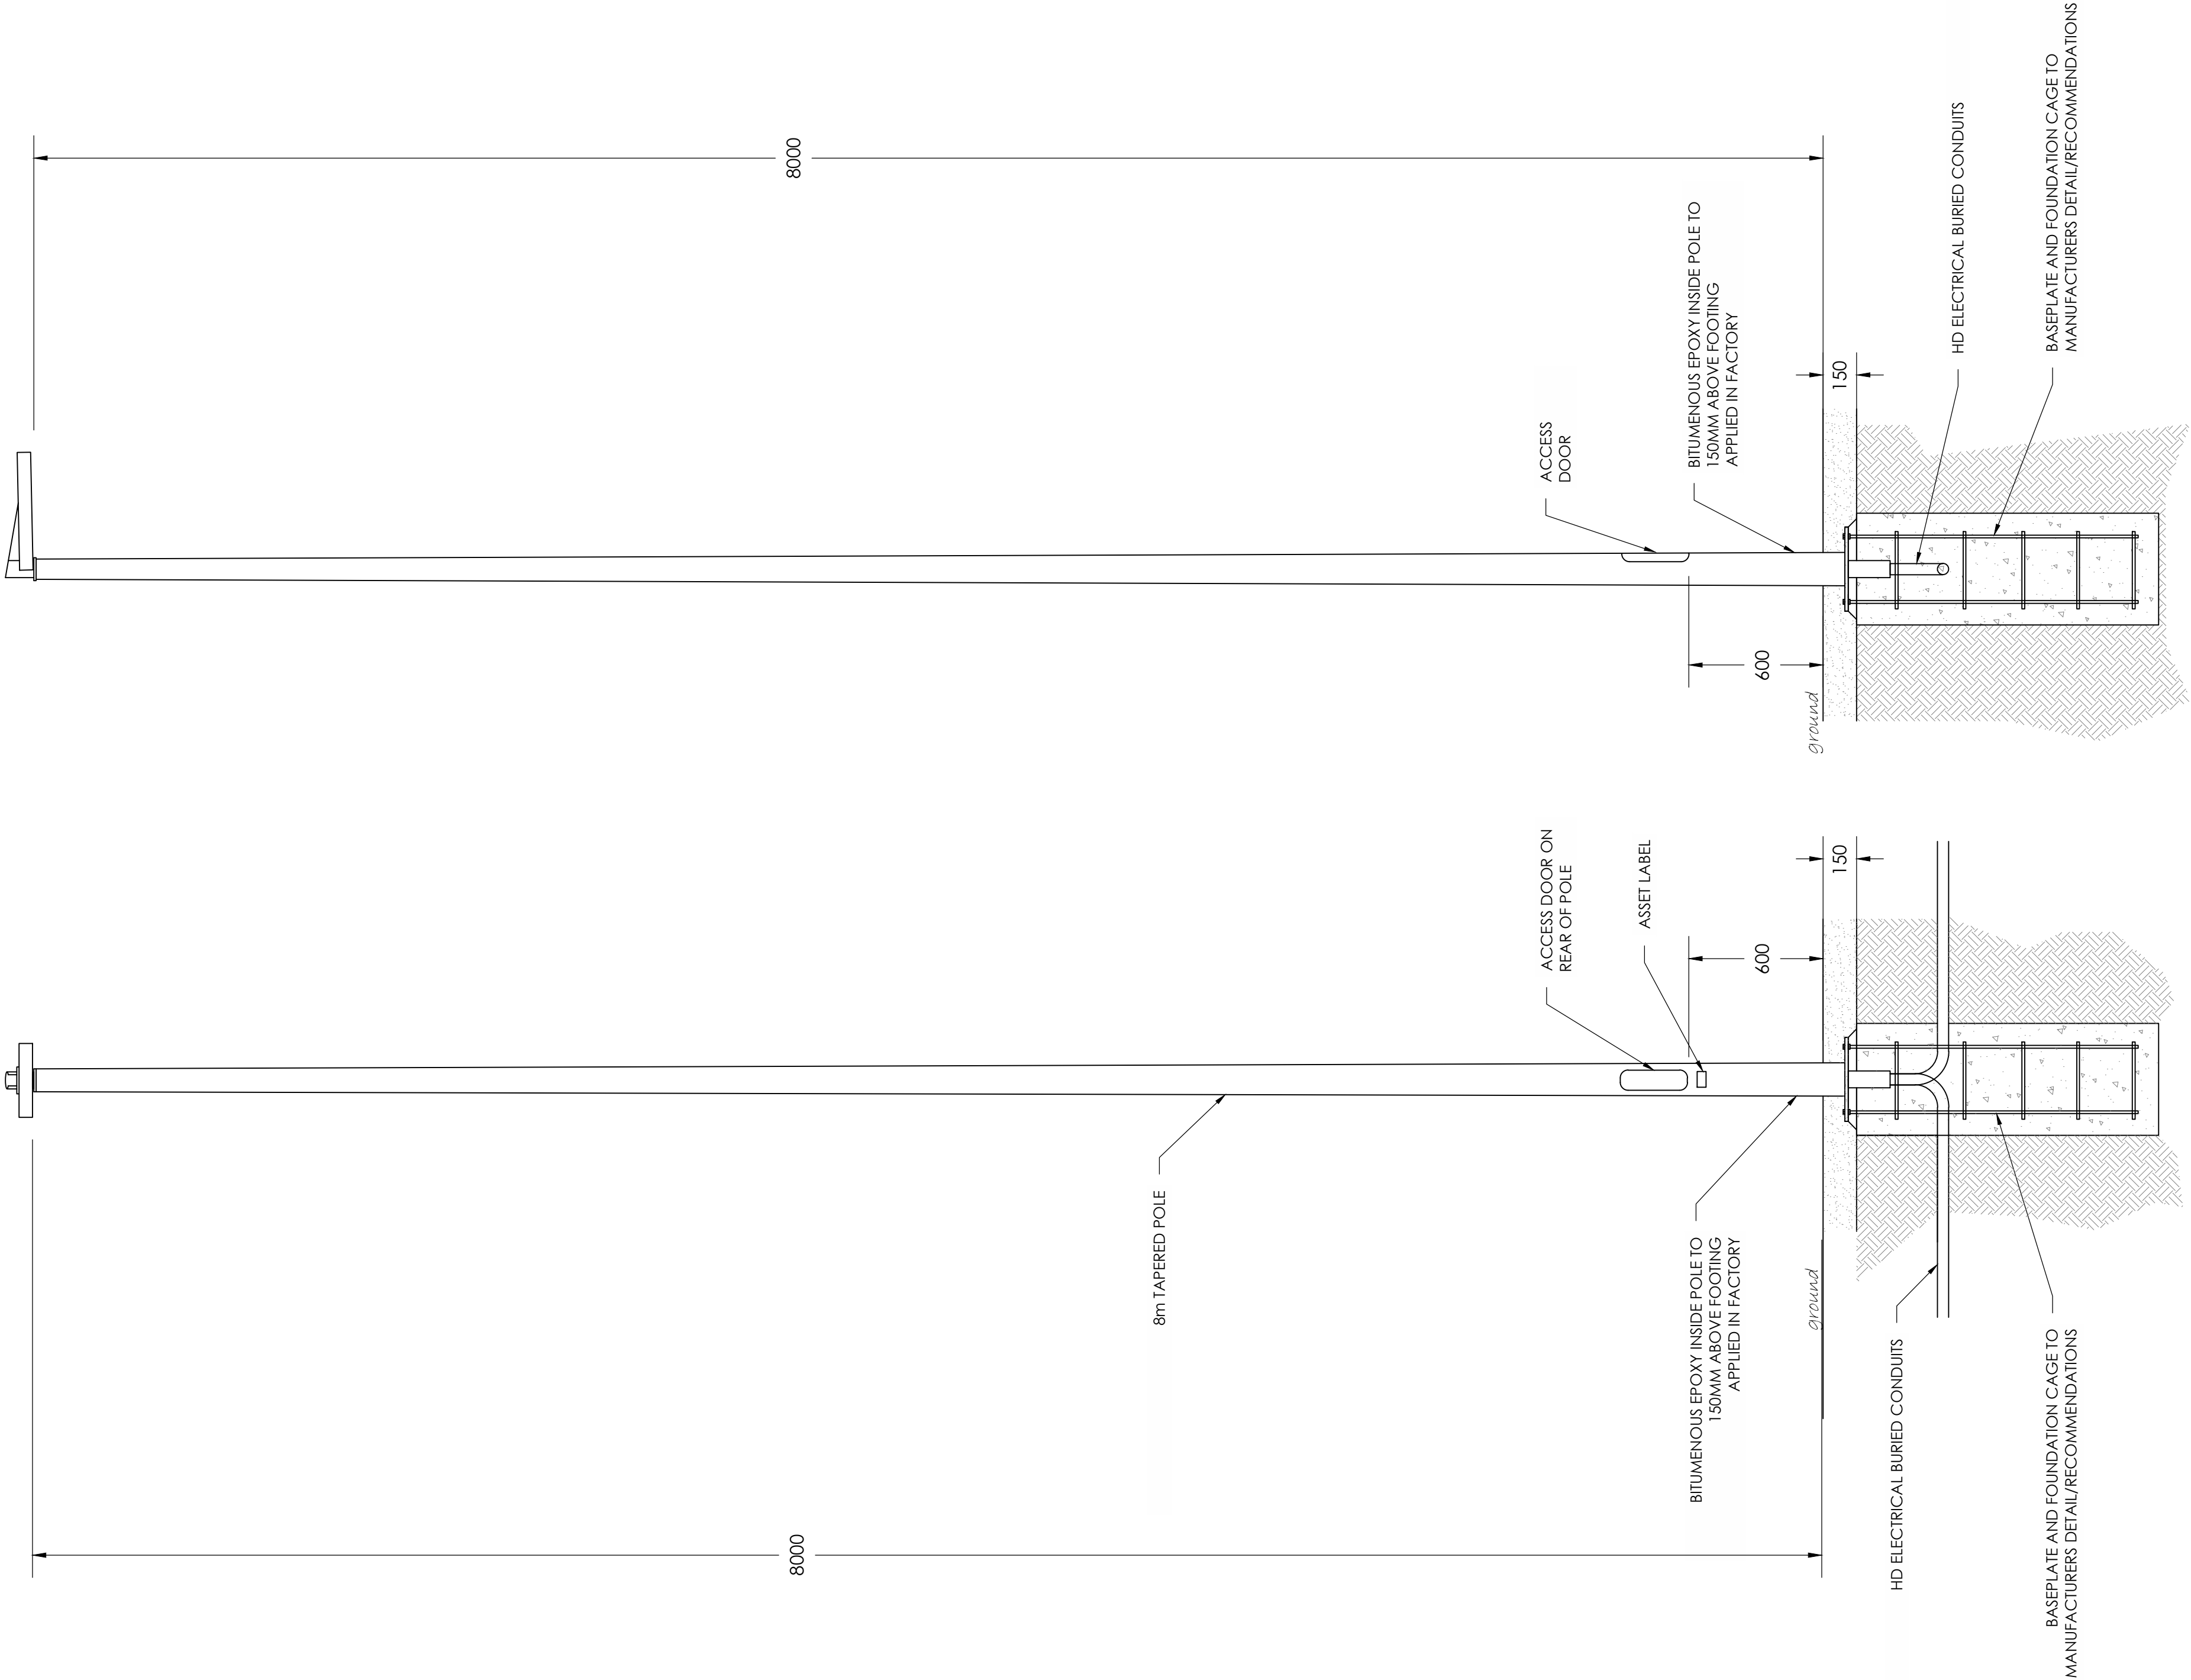

04

CARPARK LIGHT POLE DETAILS


1:20@A1

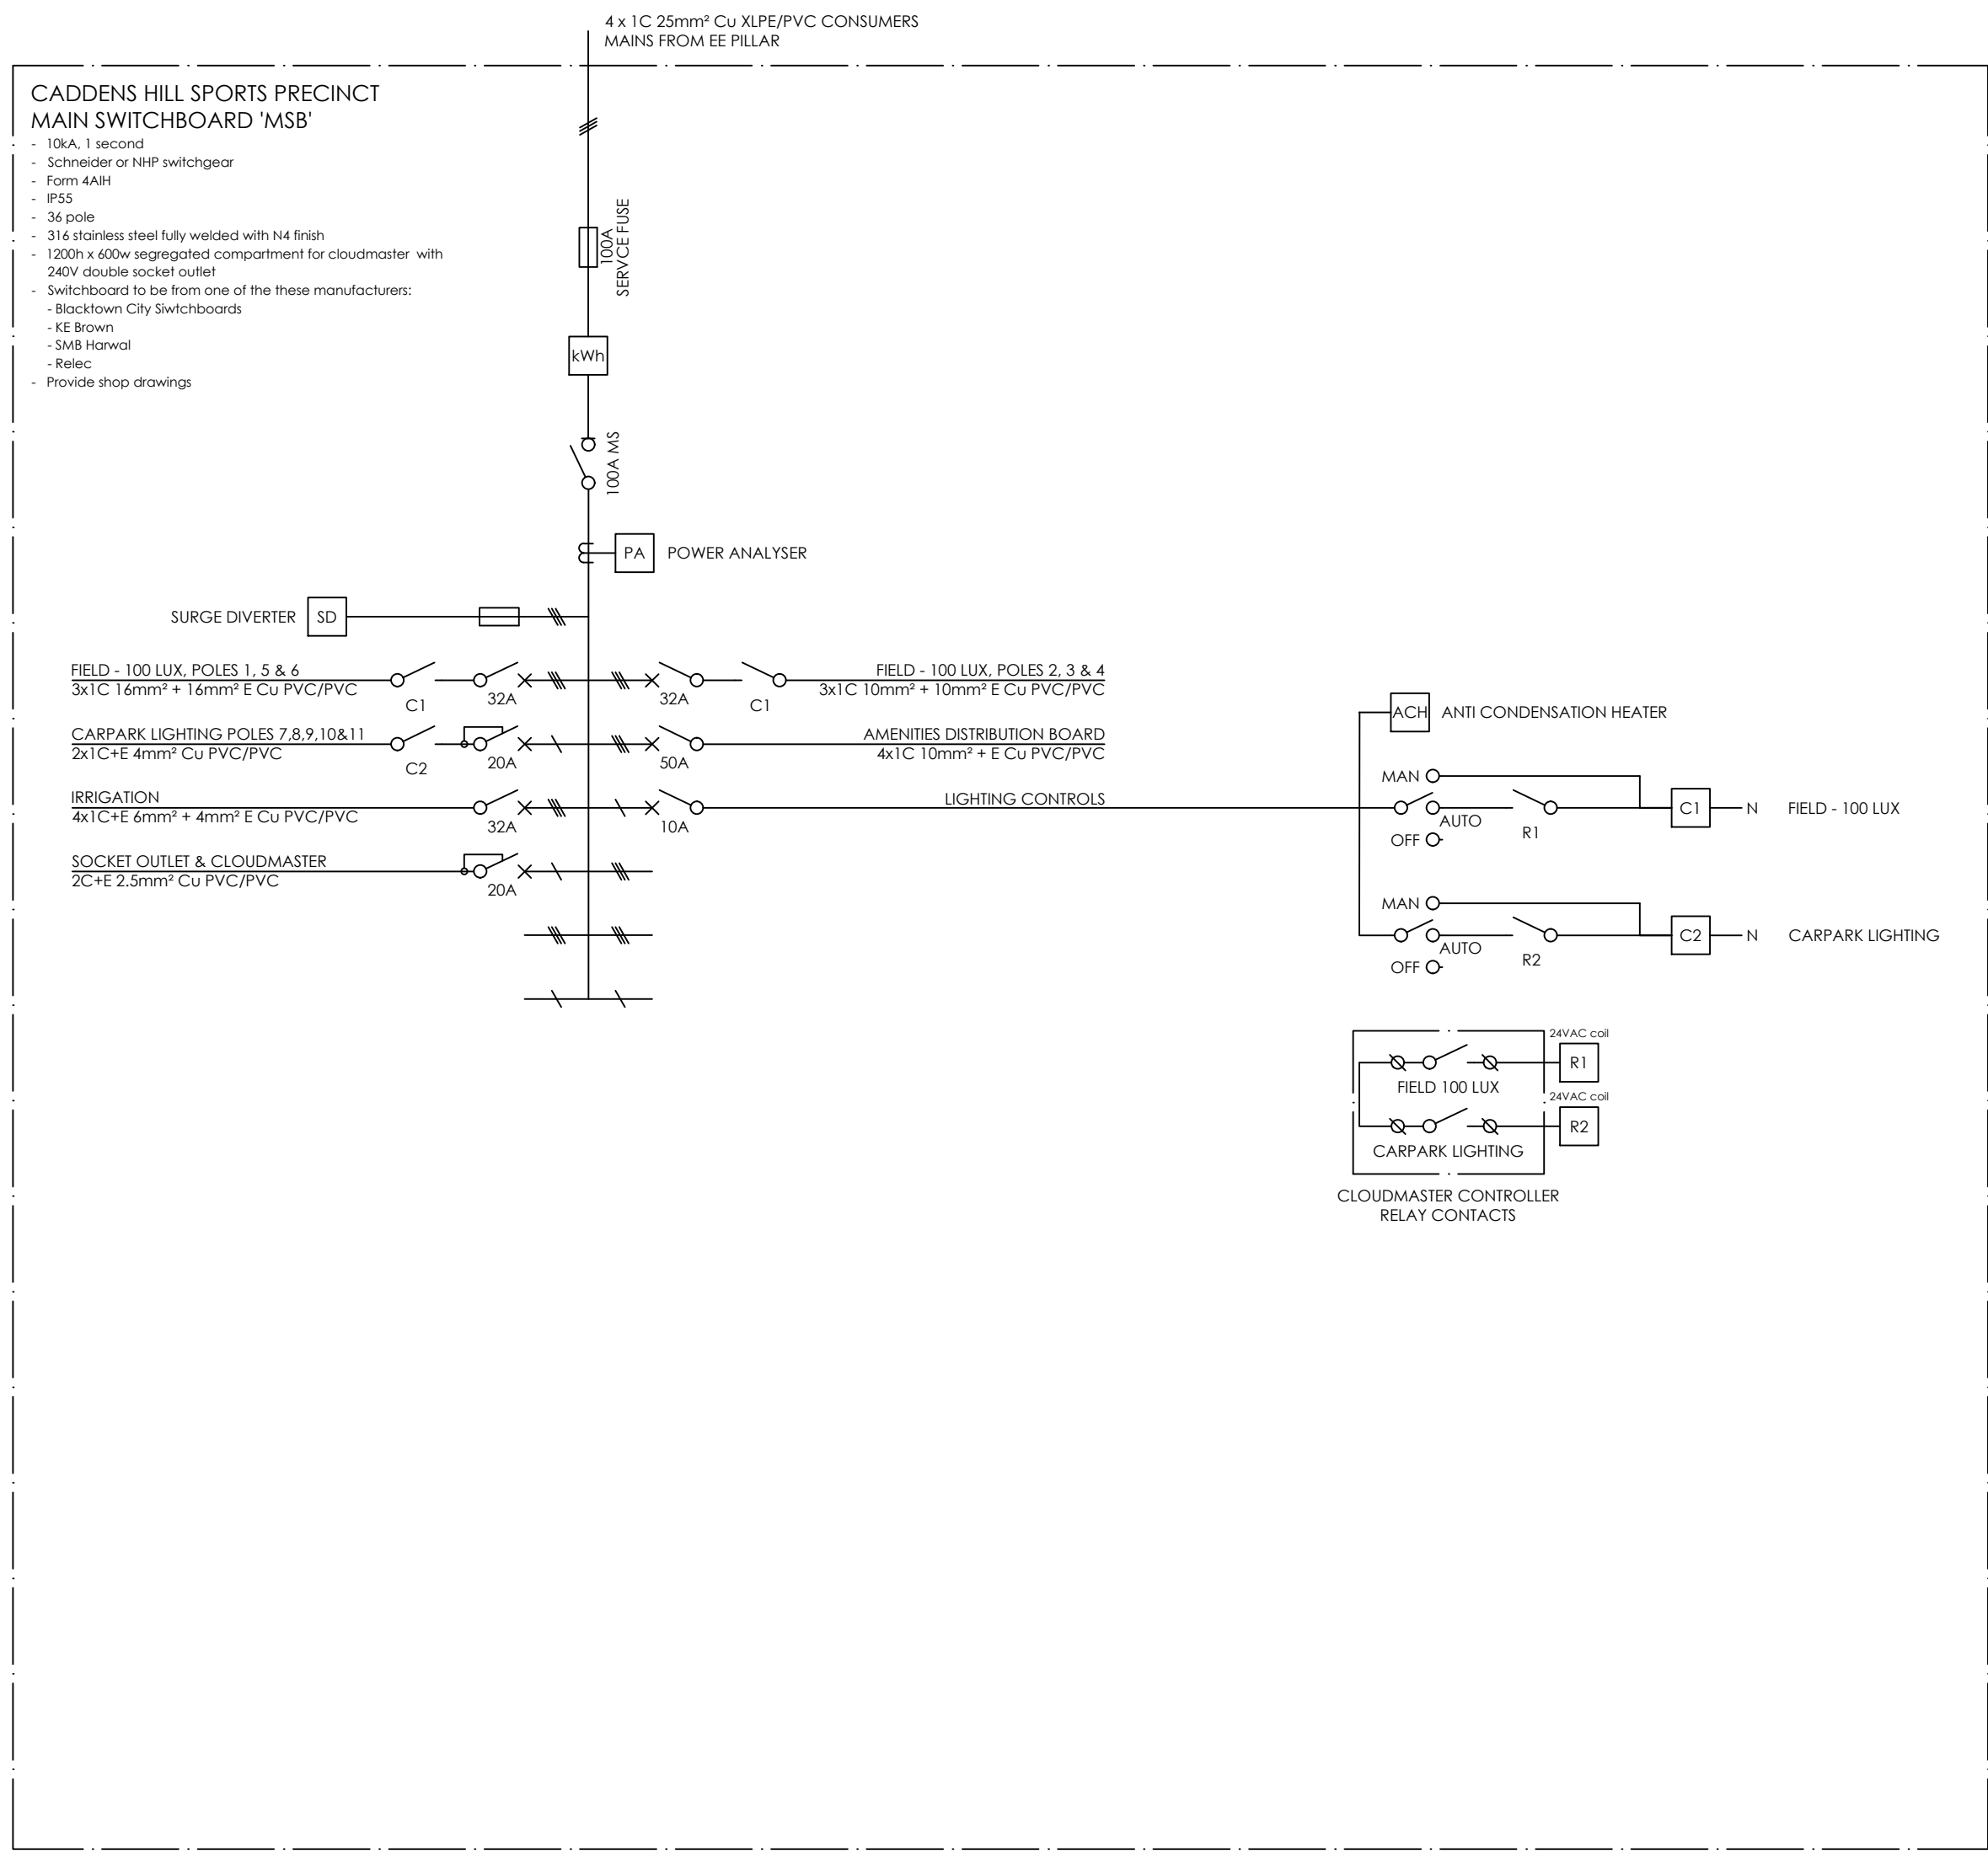

05

SINGLE LINE DIAGRAM

NTS

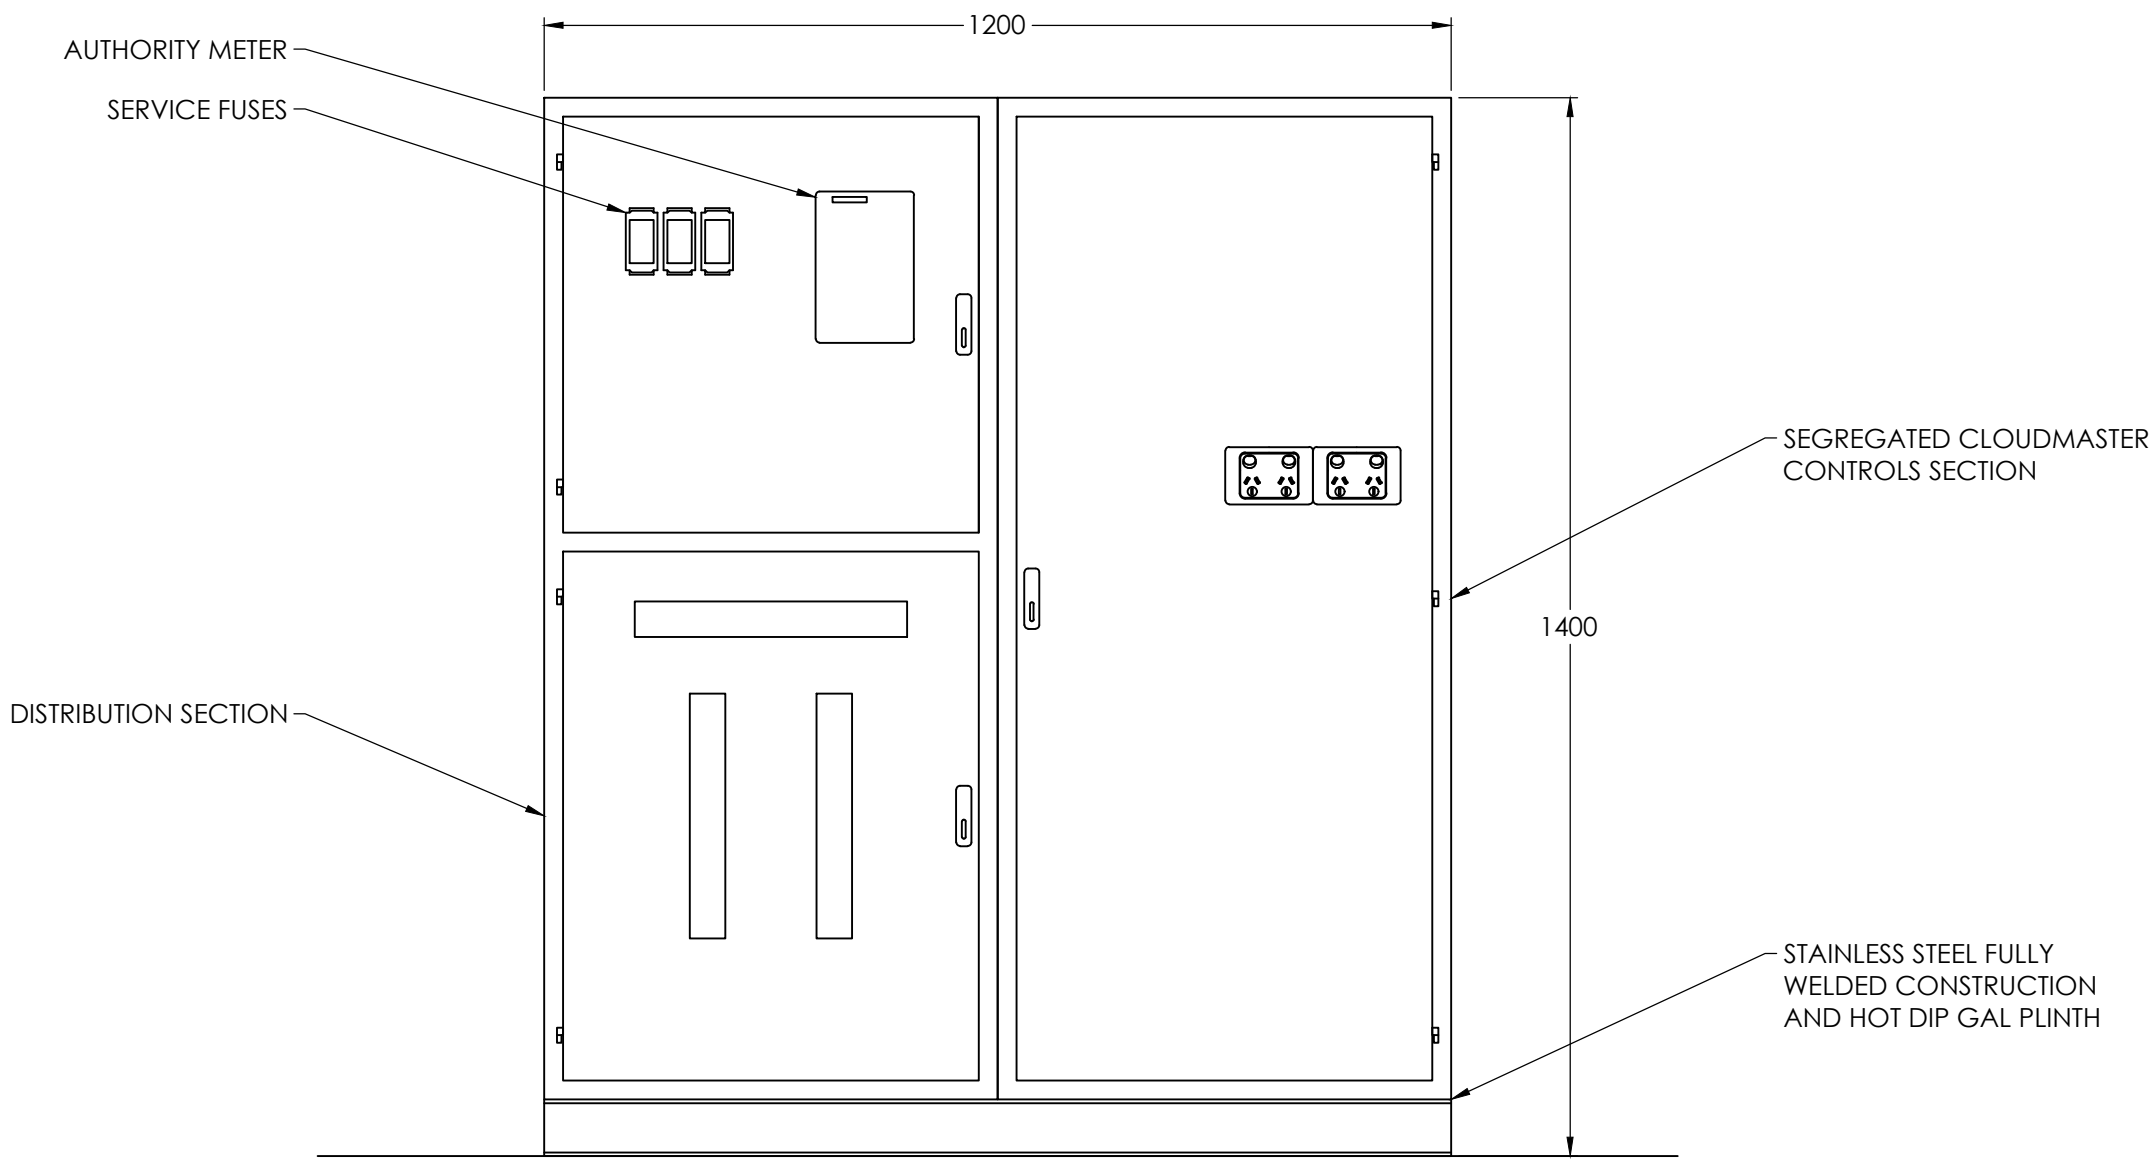

06

MAIN SWITCHBOARD ELEVATION

1:10@A1

Issue

Amendment

Date

T1

TENDER ISSUE

17-11-17

Notes:

1. Provide shop drawings
2. Pad lock handles & 3 point locking bars/pins for switchboard doors taller than 300mm

Lead Consultant
PLACE DESIGN GROUP

Client
LEGACY PROPERTY

Lighting, Art & Science
Lighting Consultants, Electrical Engineers
Level 1, 41 Hume St, Crows Nest NSW 2065
p: +61 2 9436 0998 e: mail@laands.com.au

Project CADDENS HILL SPORTS PRECINCT

Drawing SINGLE LINE DIAGRAM

Drawn RM

Approv. RM

Date
NOV 2017

Scale
N.T.S.

Project No

Drawing No

Rev

L150I

EL-300

T1

© Copyright 2017 Lighting, Art & Science Pty Limited ABN 64 152 715 921
All rights reserved. This drawing may not be reproduced or transmitted in any form or means in part or in whole without written permission of Lighting, Art & Science Pty Ltd



N.T.S.